
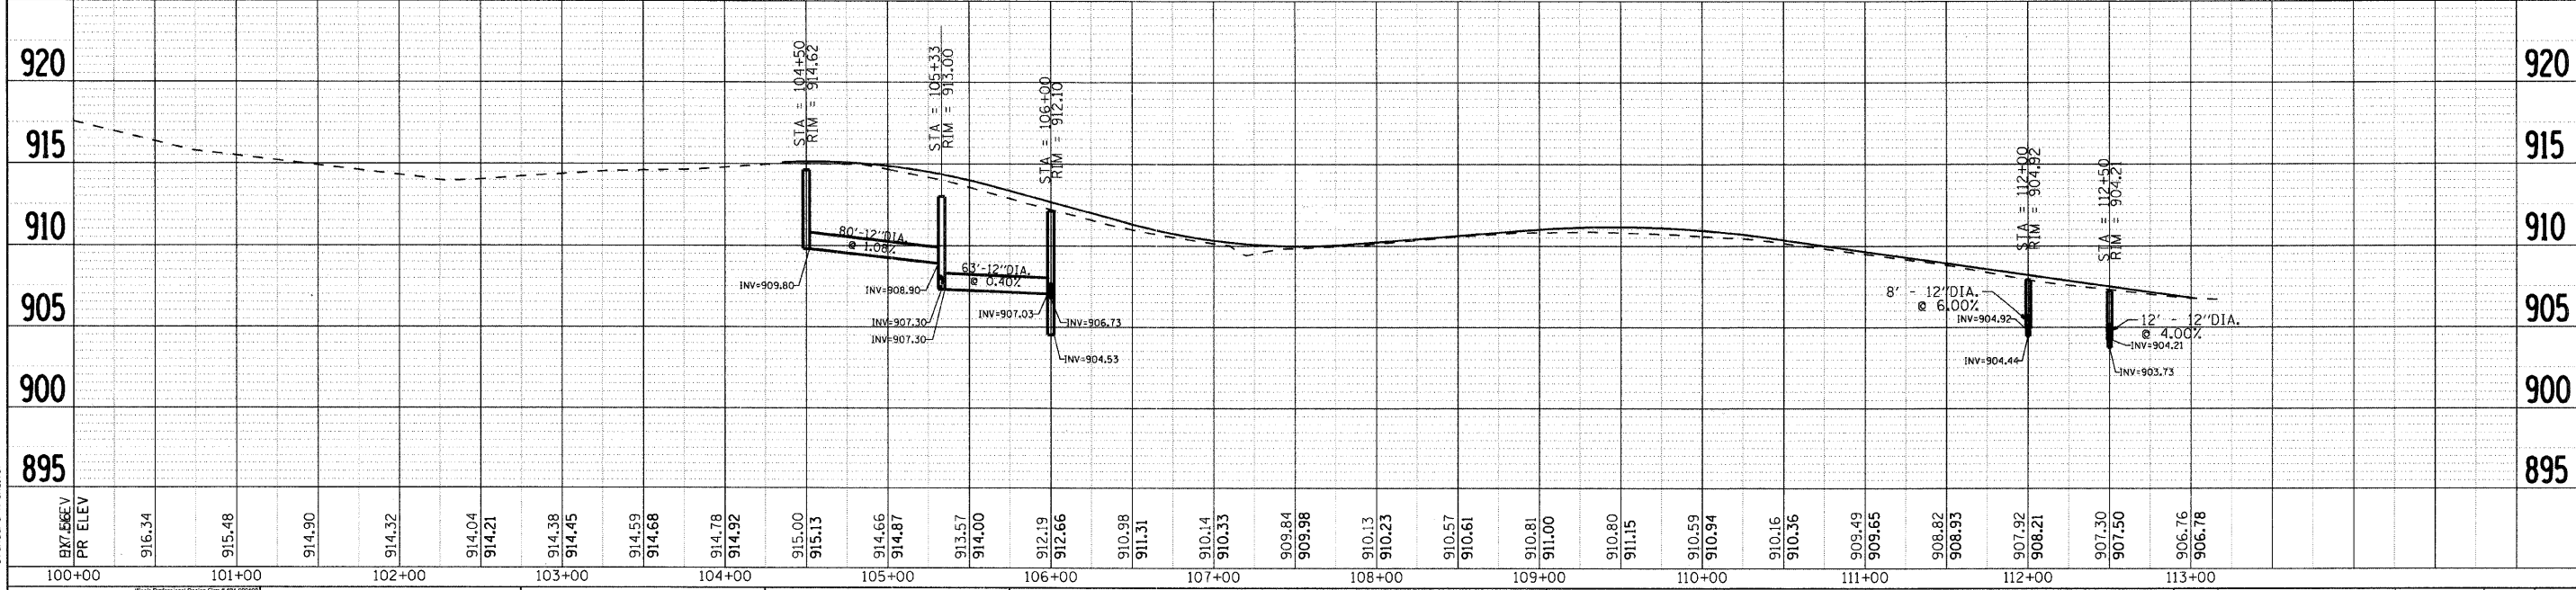
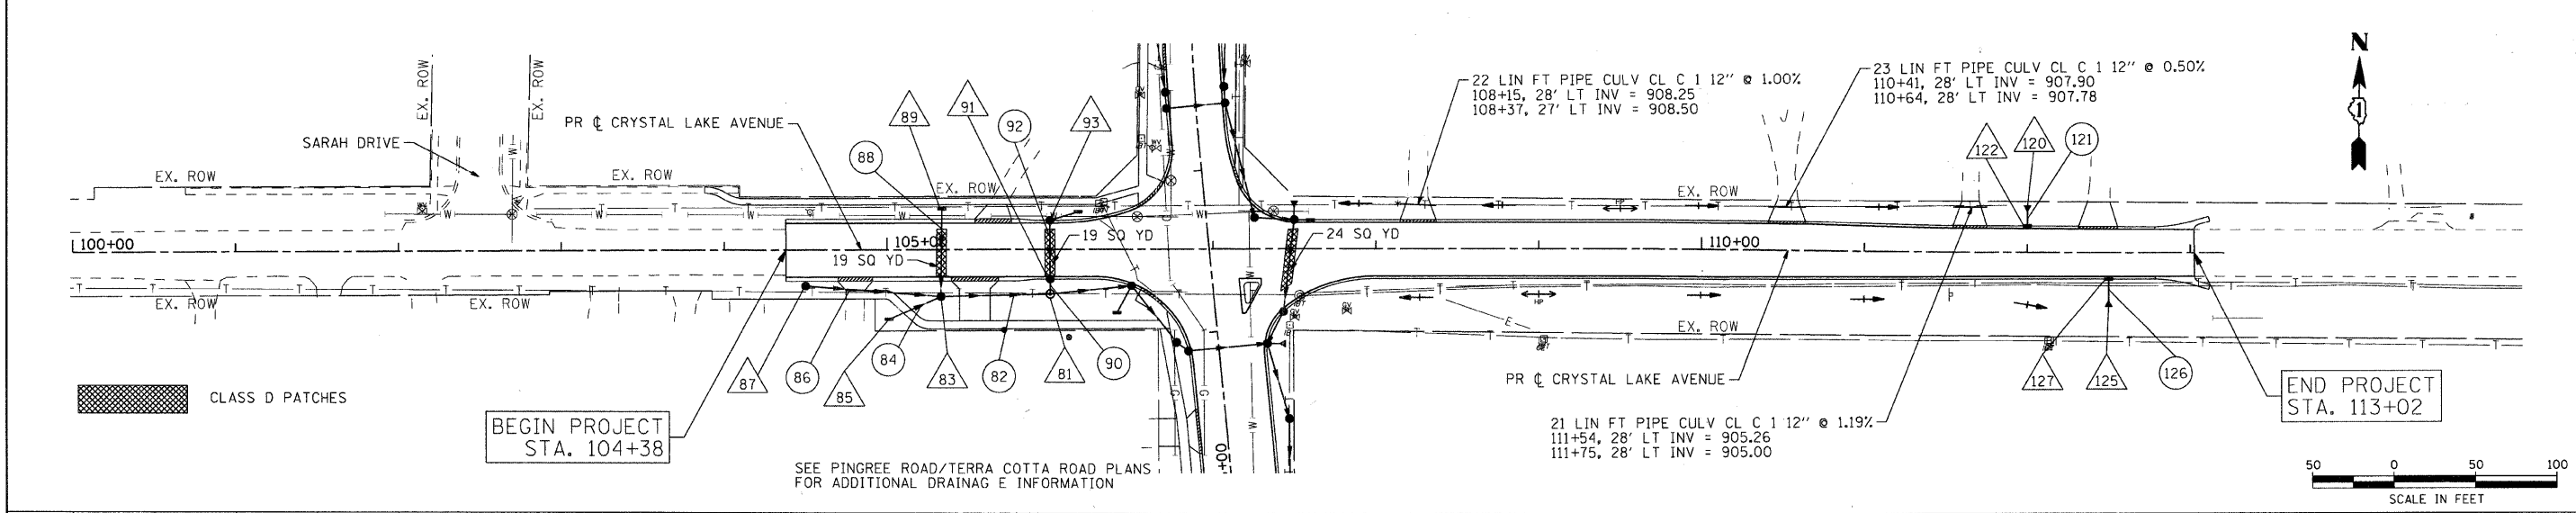


DATE	BY	SUBMITTED	CHECKED
DATE	BY	PLANNED	CHECKED
DATE	BY	NOTED	CHECKED

DATE	BY	PROFILES	CHECKED
DATE	BY	GRADES	CHECKED
DATE	BY	STRUCTURE	CHECKED

COMPANY NAME: J. MELNIISH  
 PROJECT CONTACT: ALGOMQUIN AND WANDA TOWNSHIP  
 CLIENTS: 2/13/2009 11:53:57 AM  
 DATE PLOTTED: 08/05/09-03:00:00  
 FILE NAME: 080509-03-00-00-01.dwg  
 PLOT SCALE: standard-trans.dwg

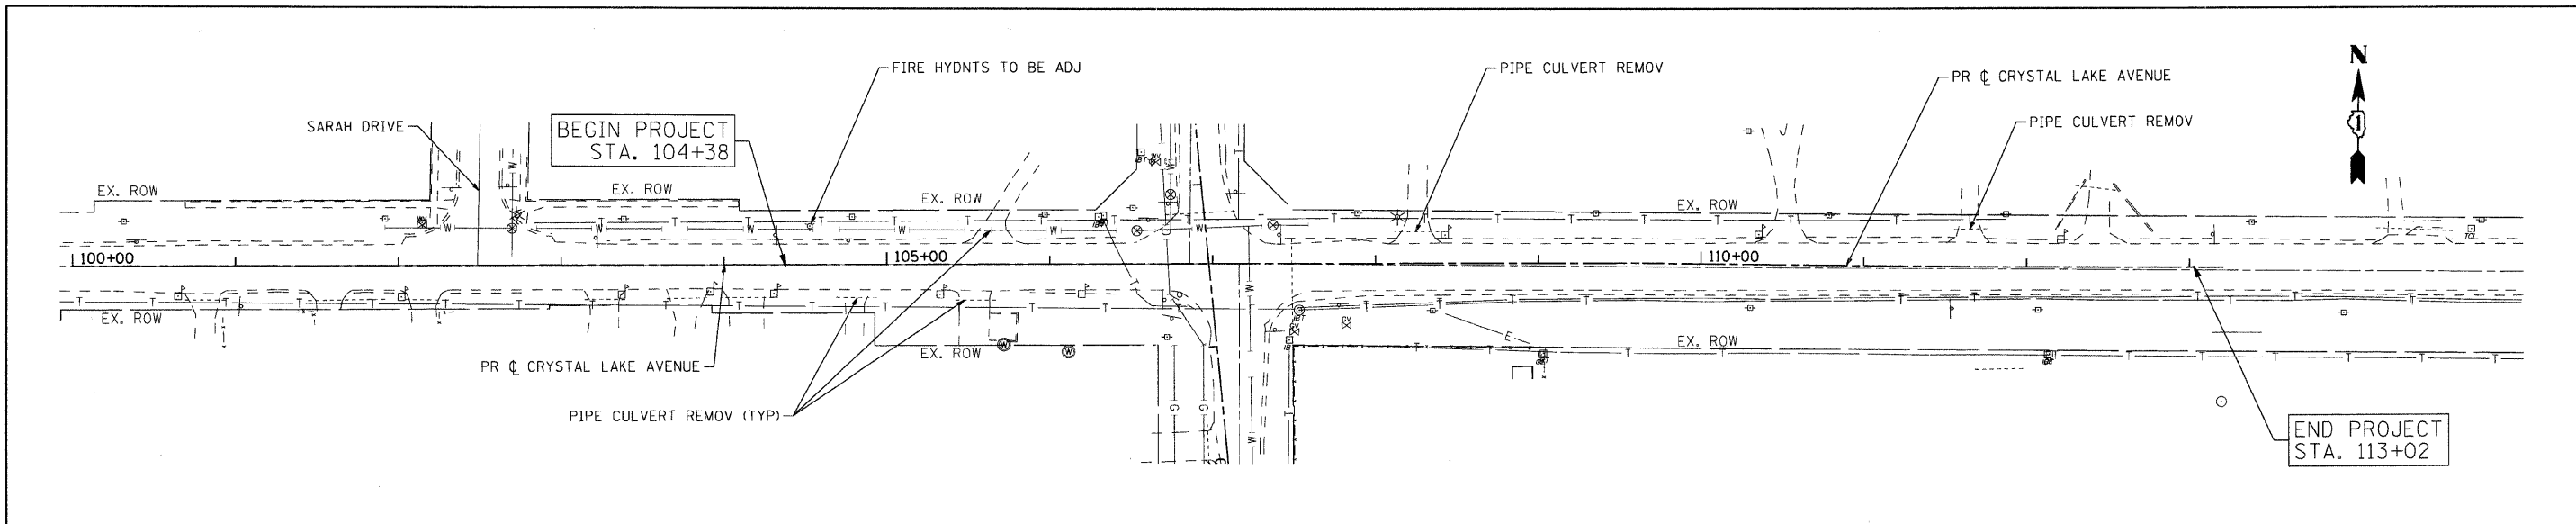

895	900	905	910	915	920																																										
100+00	101+00	102+00	103+00	104+00	105+00	106+00	107+00	108+00	109+00	110+00	111+00	112+00	113+00																																		
916.34	915.48	914.90	914.32	914.04	914.21	914.38	914.45	914.59	914.68	914.78	914.92	915.00	915.13	914.66	914.87	913.57	914.00	912.19	912.66	910.98	911.31	910.14	910.33	909.84	909.98	910.13	910.23	910.57	910.61	910.81	911.00	910.80	911.15	910.59	910.94	910.16	910.36	909.49	909.65	908.82	908.93	907.92	908.21	907.30	907.50	906.76	906.78

**SEC Group, Inc.**  
 Engineering  
 Planning  
 Landscaping/Architecture  
 McHenry • Yorkville • New Lenox • Chicago  
 www.secgroupinc.com

USER NAME = char-tke	DESIGNED - JJS	REVISED -
FILE NAME = 080154-dpp-03.dgn	DRAWN - JJS	REVISED -
PLOT SCALE = 1" = 50'	CHECKED - TCH	REVISED -
PLOT DATE = 2/13/2009	DATE - 2/13/09	REVISED -

**MCHENRY COUNTY**  
**DIVISION OF TRANSPORTATION**

**DRAINAGE AND UTILITY PLAN**  
**CRYSTAL LAKE AVENUE**  
 SCALE: 1" = 50' SHEET NO. 3 OF 5 SHEETS STA. BEGIN TO STA. END

F.A. RTE.	SECTION	COUNTY	TOTAL SHEETS	SHEET NO.
0116	08-00327-01-CH	MCHENRY	56	24
FED. ROAD DIST. NO.			ILLINOIS FED. AID PROJECT	
			CONTRACT NO. 63144	