 



SW 1/4 SEC. 22, T.19N., R.9E., 3rd P.M.
CHAMPAIGN COUNTY, ILLINOIS

CONTRACT NO. 91391



CITY OF URBANA
PUBLIC WORKS
ENGINEERING DIVISION

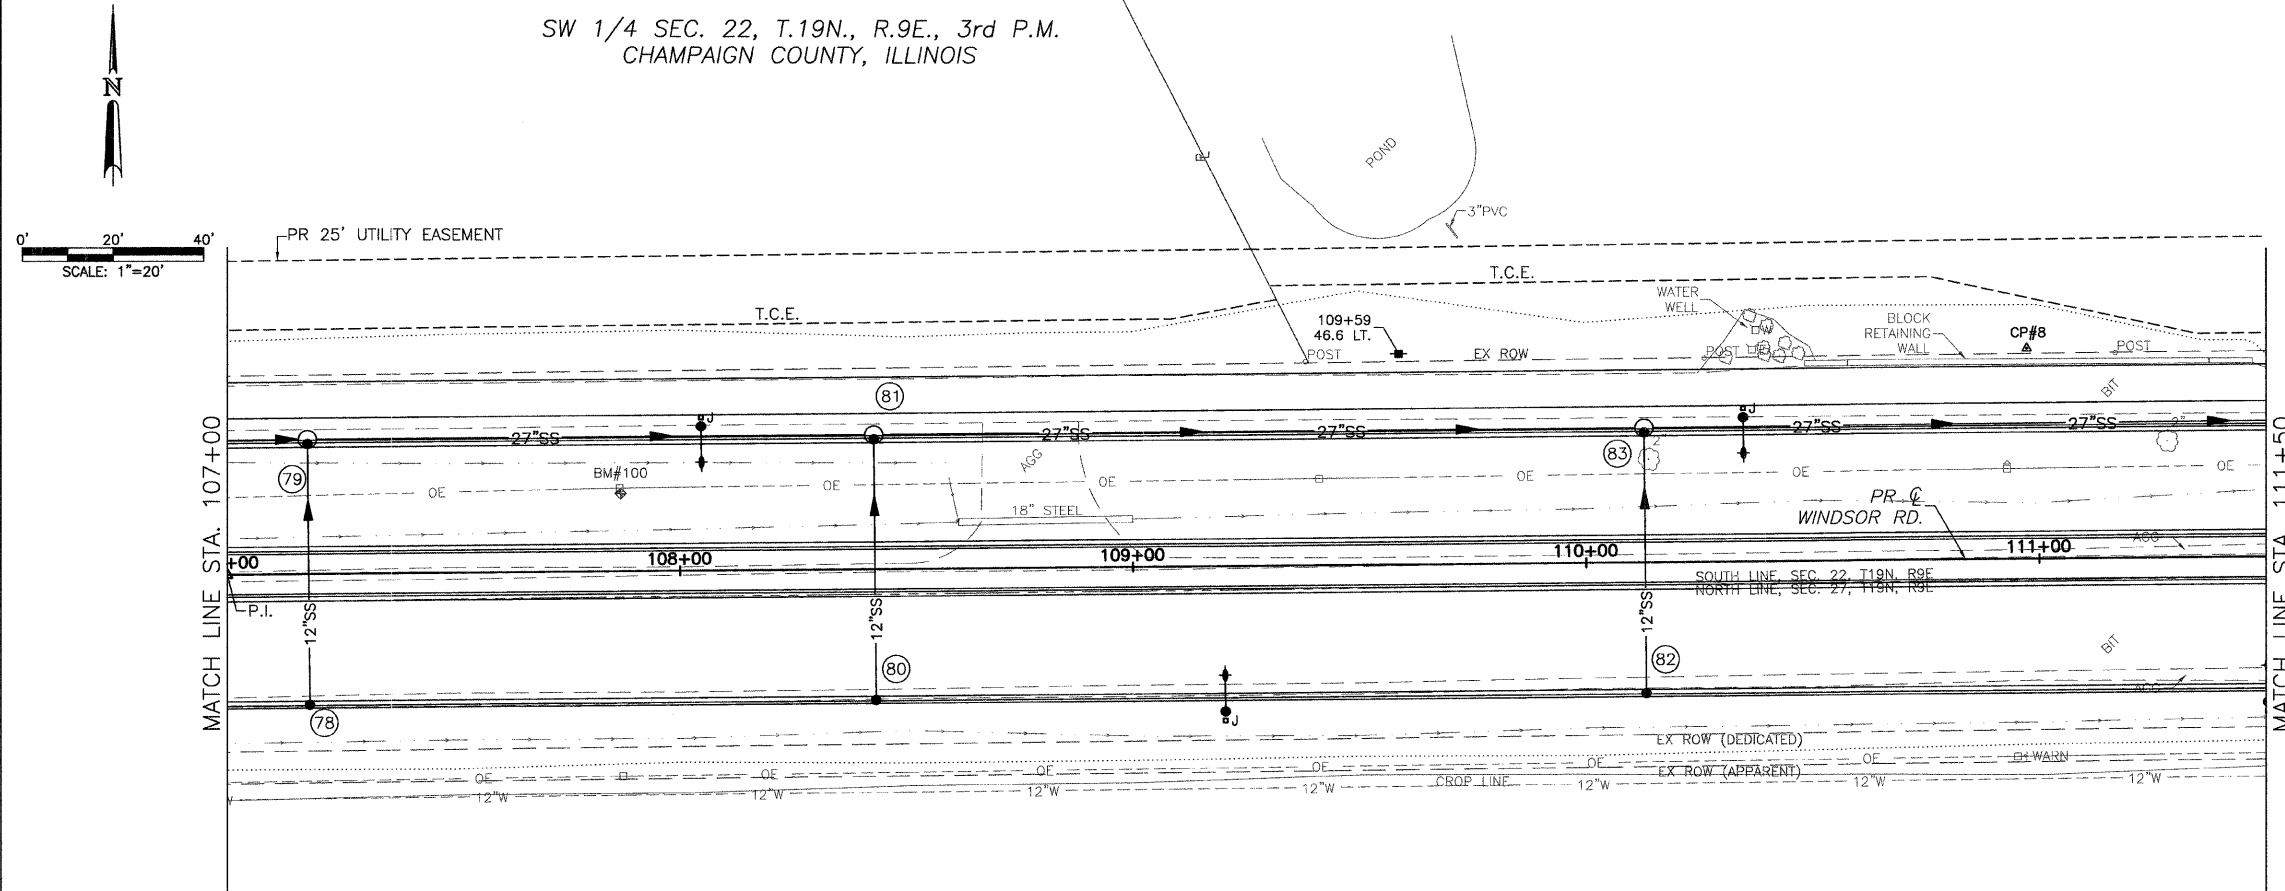

BM #100: STA. 107+87.00, 17.00'
LT. RR SPIKE IN TENTH POWER POLE
W. OF STONE CREEK BLVD.
ELEV.= 706.41

EX UNDERGROUND TELEPHONE NOT SHOWN
FROM STA. 94+00 TO STA. 114+00

NW 1/4 SEC. 27, T.19N., R.9E., 3rd P.M.
CHAMPAIGN COUNTY, ILLINOIS

STORM SEWER STRUCTURE SCHEDULE											
STR. NO.	STRUCTURE TYPE	OFF-SET SIDE	STA. OF C/L STR.	OFFSET OF C/L STR.	EX. T/O FRAME/GRATE ELEV.	PR. T/O FRAME/GRATE ELEV.	PR. T/O FLAT SLAB TOP ELEV.	INVERT IN ELEV.	U.S. STR. NO.	INVERT OUT ELEV.	D.S. STR. NO.
78	INLETS TA T11V F&G	RT	107+18.00	28.79	----	708.49	----	----	---	704.49	79
79	RD MAN 4 DIA T11V F&G	LT	107+18.00	29.79	----	708.49	706.99	703.31	77	703.11	81
								704.21	78		
80	INLETS TA T11V F&G	RT	108+43.00	28.79	----	706.88	----	----	---	702.88	81
81	RD MAN 4 DIA T11V F&G	LT	108+43.00	29.79	----	706.88	705.38	701.70	79	701.50	83
								702.60	80		
82	INLETS TA T11V F&G	RT	110+13.00	28.79	----	705.02	----	----	---	701.02	83
83	RD MAN 4 DIA T11V F&G	LT	110+13.00	29.79	----	705.02	703.52	699.84	81	699.64	86
								700.74	82		

STORM SEWER PIPE SCHEDULE				
LOCATION STR. - STR. OR STA., O.S.	STORM SEW CL A 1 12 (FOOT)	STORM SEW CL A 1 27 (FOOT)	GRADE %	TRENCH BACKFILL (CU YD)
78 - 79	56		0.50	8.4
79 - 81		121	1.17	28.4
80 - 81	56		0.50	8.4
81 - 83		166	1.00	39.0
82 - 83	56		0.50	8.4
83 - 86		158	0.86	34.8

DATED: 1/09
DESIGNED BY: CES
DRAWN BY: AUS
CHECKED BY: GLJ
CITY SECTION
00-00361-00-PV

WINDSOR ROAD IMPROVEMENTS
DRAINAGE PLANS
STA 107+00 TO STA 111+50

SHEET NO.
62
OF
145

JAN 09 2009 1:25PM DRAINAGE_STA107+00-111+50.DWG