


SE 1/4 SEC. 22, T.19N., R.9E., 3rd P.M.
CHAMPAIGN COUNTY, ILLINOIS

CONTRACT NO. 91391

 


CITY OF URBANA
PUBLIC WORKS
ENGINEERING DIVISION

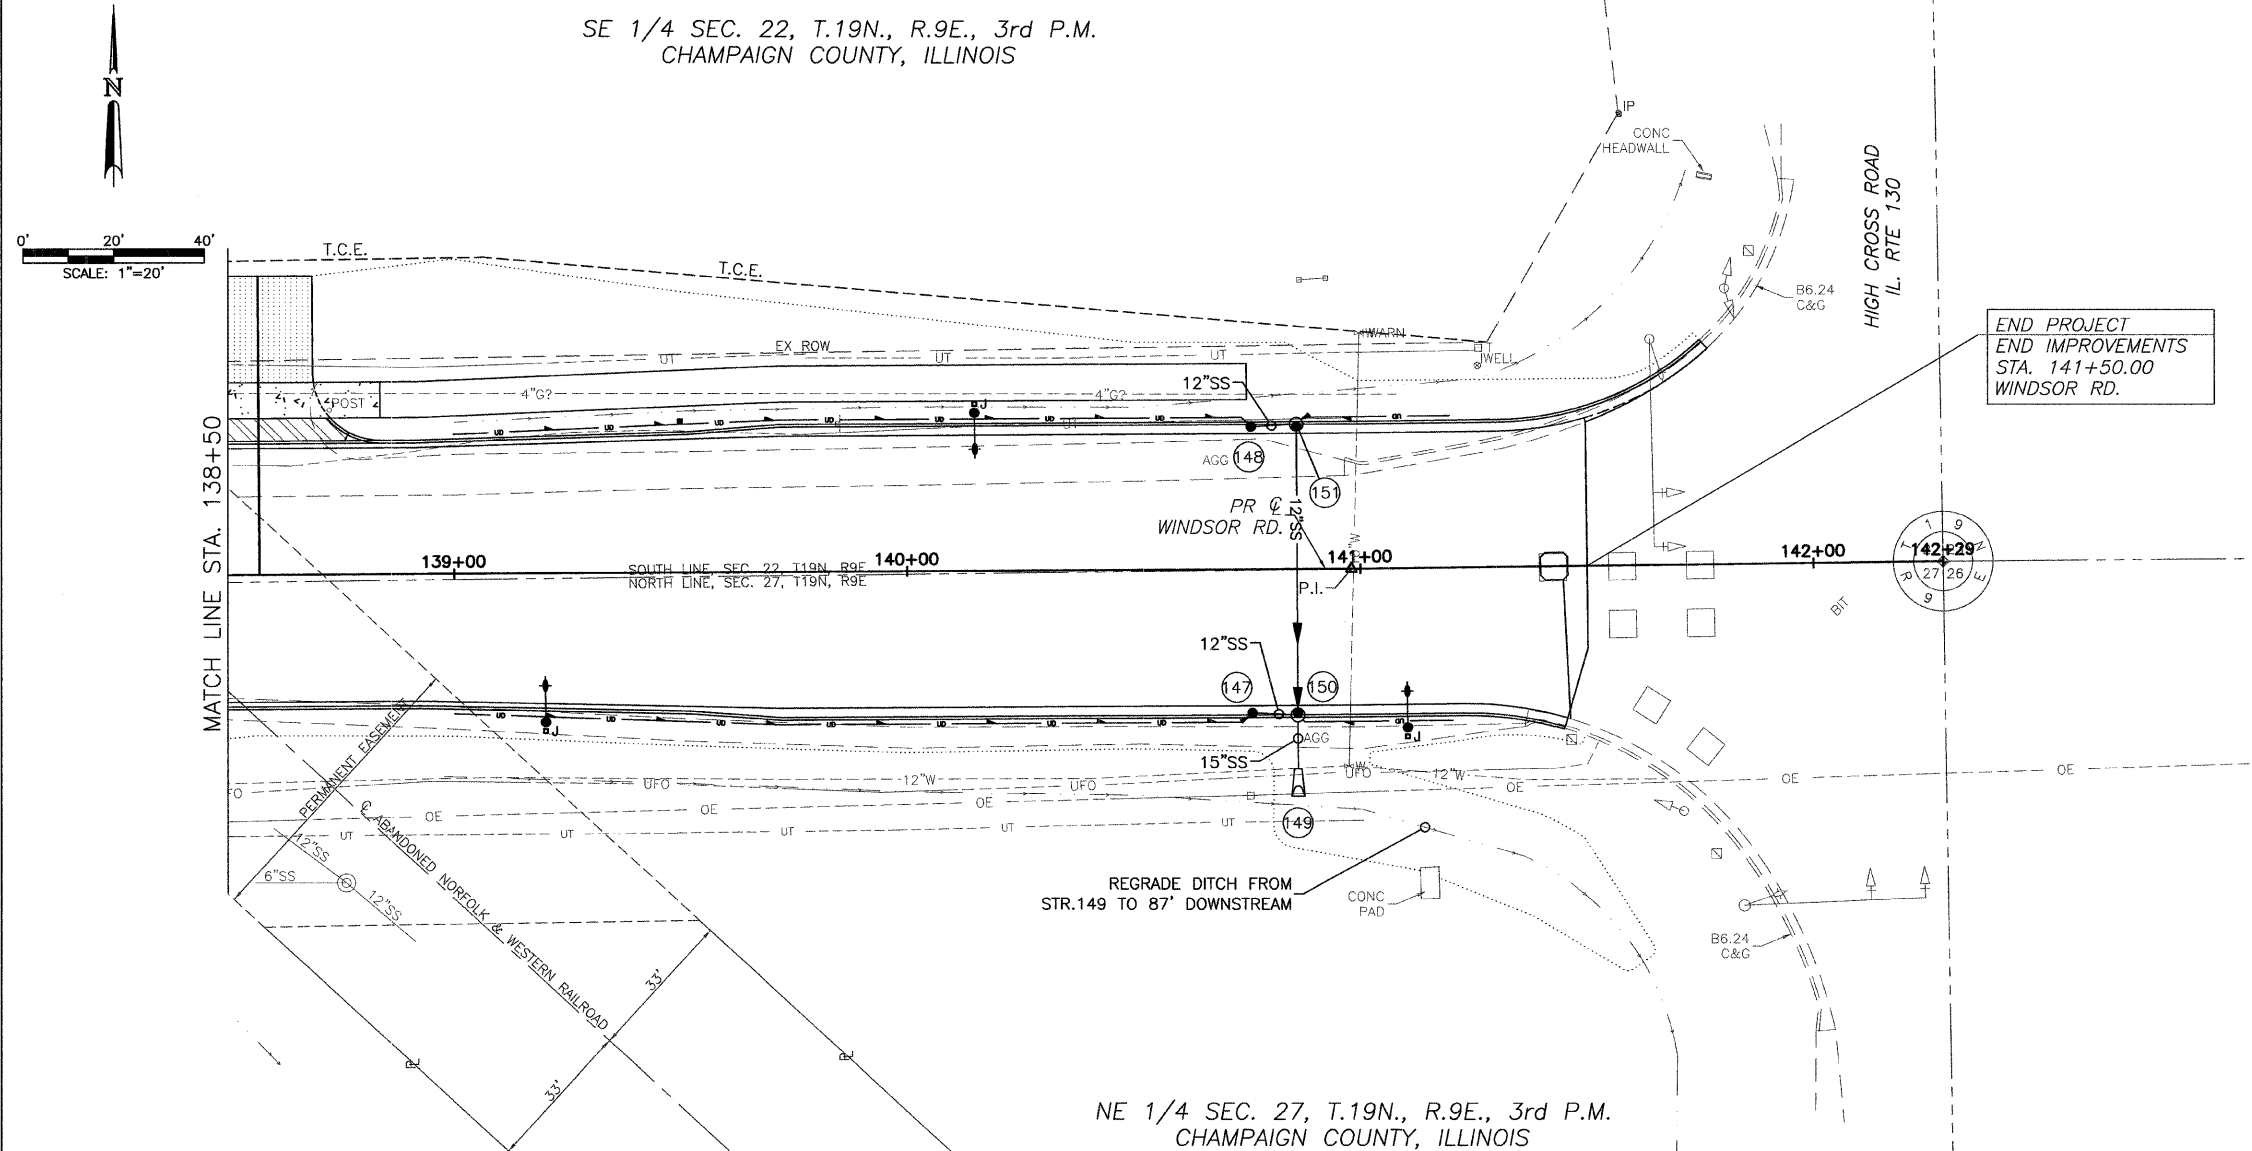

END PROJECT
END IMPROVEMENTS
STA. 141+50.00
WINDSOR RD.

NE 1/4 SEC. 27, T.19N., R.9E., 3rd P.M.
CHAMPAIGN COUNTY, ILLINOIS



MATCH LINE STA. 138+50

STORM SEWER STRUCTURE SCHEDULE											
STR. NO.	STRUCTURE TYPE	OFF-SET SIDE	STA. OF C/L STR.	OFFSET OF C/L STR.	EX. T/O FRAME/GRATE ELEV.	PR. T/O FRAME/GRATE ELEV.	PR. T/O FLAT SLAB TOP ELEV.	INVERT IN ELEV.	U.S. STR. NO.	INVERT OUT ELEV.	D.S. STR. NO.
147	INLETS TA T3 F&G	RT	140+76.00	31.56	----	694.08	----	----	---	690.96	150
148	INLETS TA T3 F&G	LT	140+76.00	31.56	----	694.08	----	----	---	691.18	151
149	PRC FLAR END SEC 15	RT	140+86.02	50.00	----	----	----	----	---	690.85	DITCH
150	RD INLET TY B T3 F&G	RT	140+86.02	32.06	----	694.07	692.57	690.94	147	690.90	149
151	RD INLET TY B T3 F&G	LT	140+86.02	32.06	----	694.07	692.57	691.16	148	691.12	150

D=DITCH
*STATION, OFFSET AND INVERT TO END OF END SECTION.

STORM SEWER PIPE SCHEDULE				
LOCATION STR. - STR. OR STA., O.S.	SS1 WMQ 12 (FOOT)	SS1 WMQ 15 (FOOT)	GRADE %	TRENCH BACKFILL (CU YD)
147 - 150	8		0.30	0.0
148 - 151	8		0.30	0.2
149 - 150		11	0.30	----
150 - 151	62		0.30	2.4

DATED: 1/09
DESIGNED BY: CES
DRAWN BY: AJS
CHECKED BY: GLJ
CITY SECTION
00-00361-00-PV

WINDSOR ROAD IMPROVEMENTS
DRAINAGE PLANS
STA 138+50 TO STA 142+29

SHEET NO.
69
OF
145

JAN 09 2009 1:28PM DRAINAGE_STA138+50-142+29.DWG