



HANSON PROFESSIONAL SERVICES INC.

815 Commerce Drive, Suite 200
Oak Brook, Illinois 60523
Telephone: 630.990.3800
Fax: 630.990.3801

Illinois Professional Design Firm
Registration No. 184-001084

© Copyright Hanson Professional Service Inc. 2008




JOLIET REGIONAL PORT DISTRICT

1 George Michas Drive
Romeoville, Illinois 60446
Telephone: 815.838.9497
Fax: 815.838.9524

COMPLETE TAXIWAY G

AIP PROJECT NO. 3-17-0140-B43
IDA PROJECT NO. LOT-3883

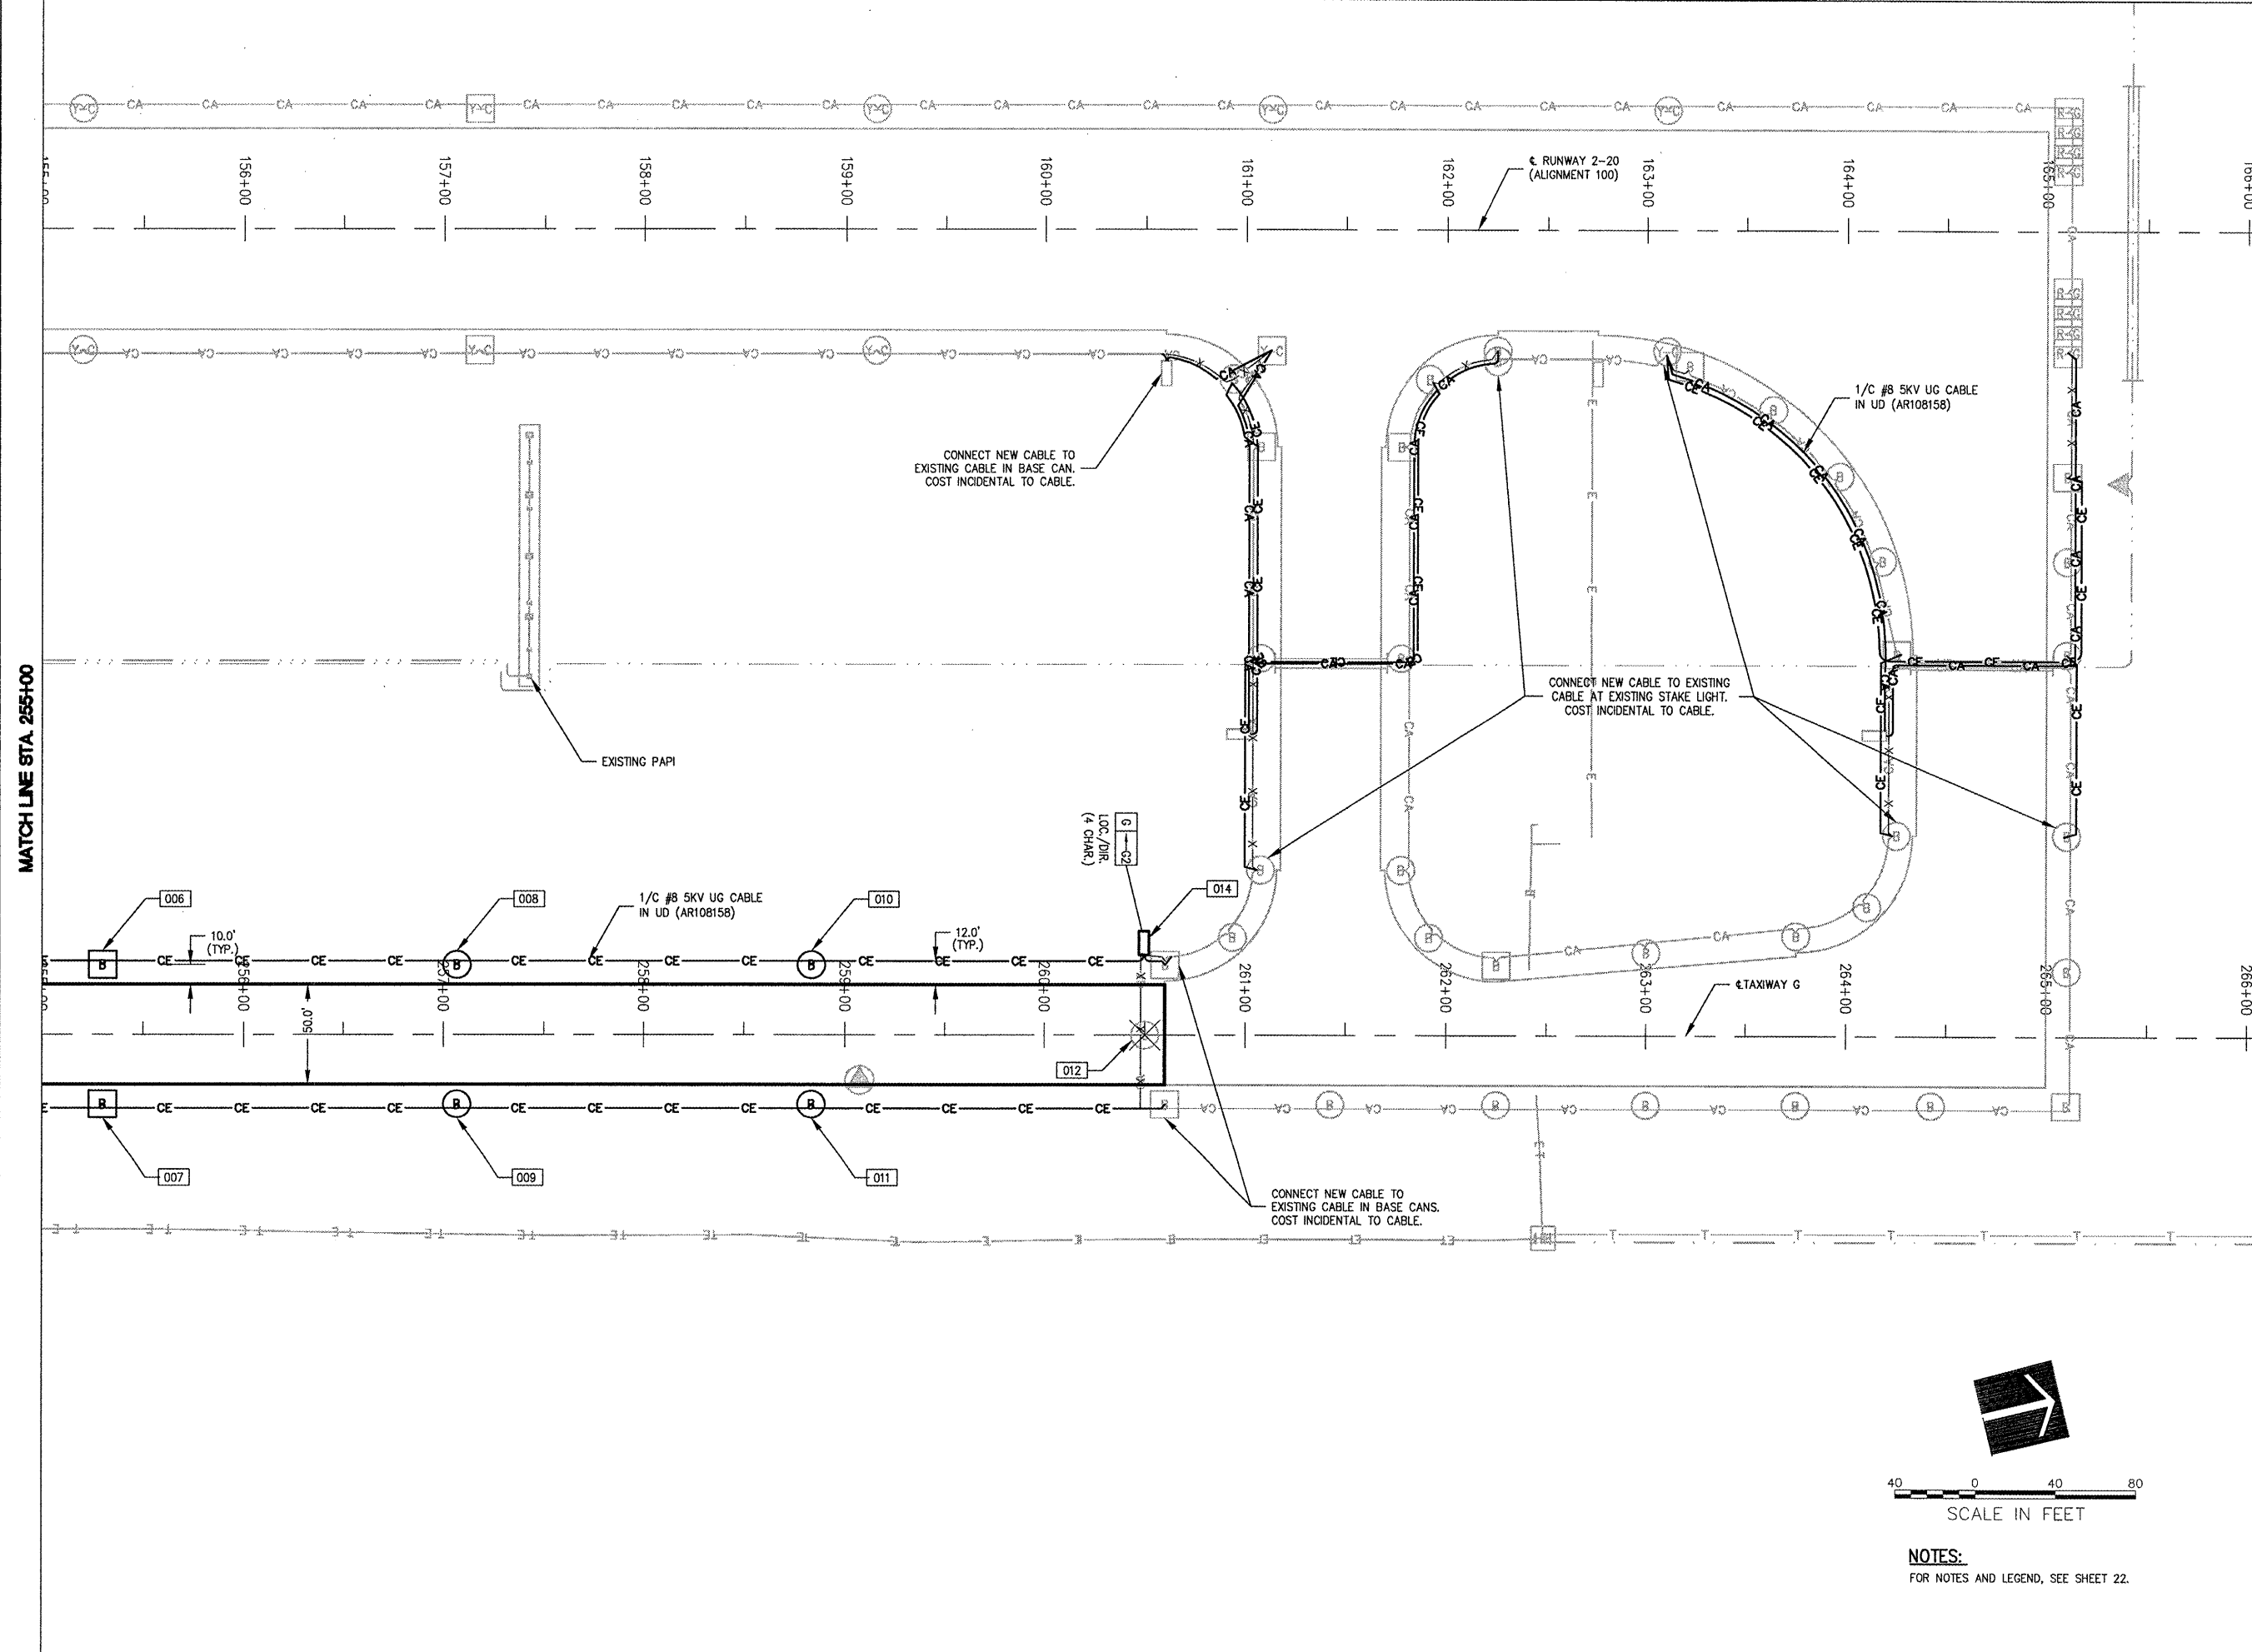

| No. | Drawing Issue Description | Date | By |
|-----|---------------------------|------|----|
| | | | |
| | | | |
Date
JANUARY 30, 2009
Sheet Title

LIGHTING PLAN
TAXIWAY G
STA. 255+00 THRU
STA. 266+00

08A0122
 Project Number
 LDH 06/18/08
 Layout By Date
 LDH 06/18/08
 Designed By Date
 RMH 01/30/09
 Reviewed By Date
 LDH
 Drawn By Sheet No.

I:\08\005\08A0122\DRAWINGS\SHEETS\23-LIGHTING PLAN\DWG FEB 27, 2009 11:03AM HANSON08082