


 
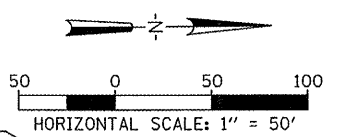
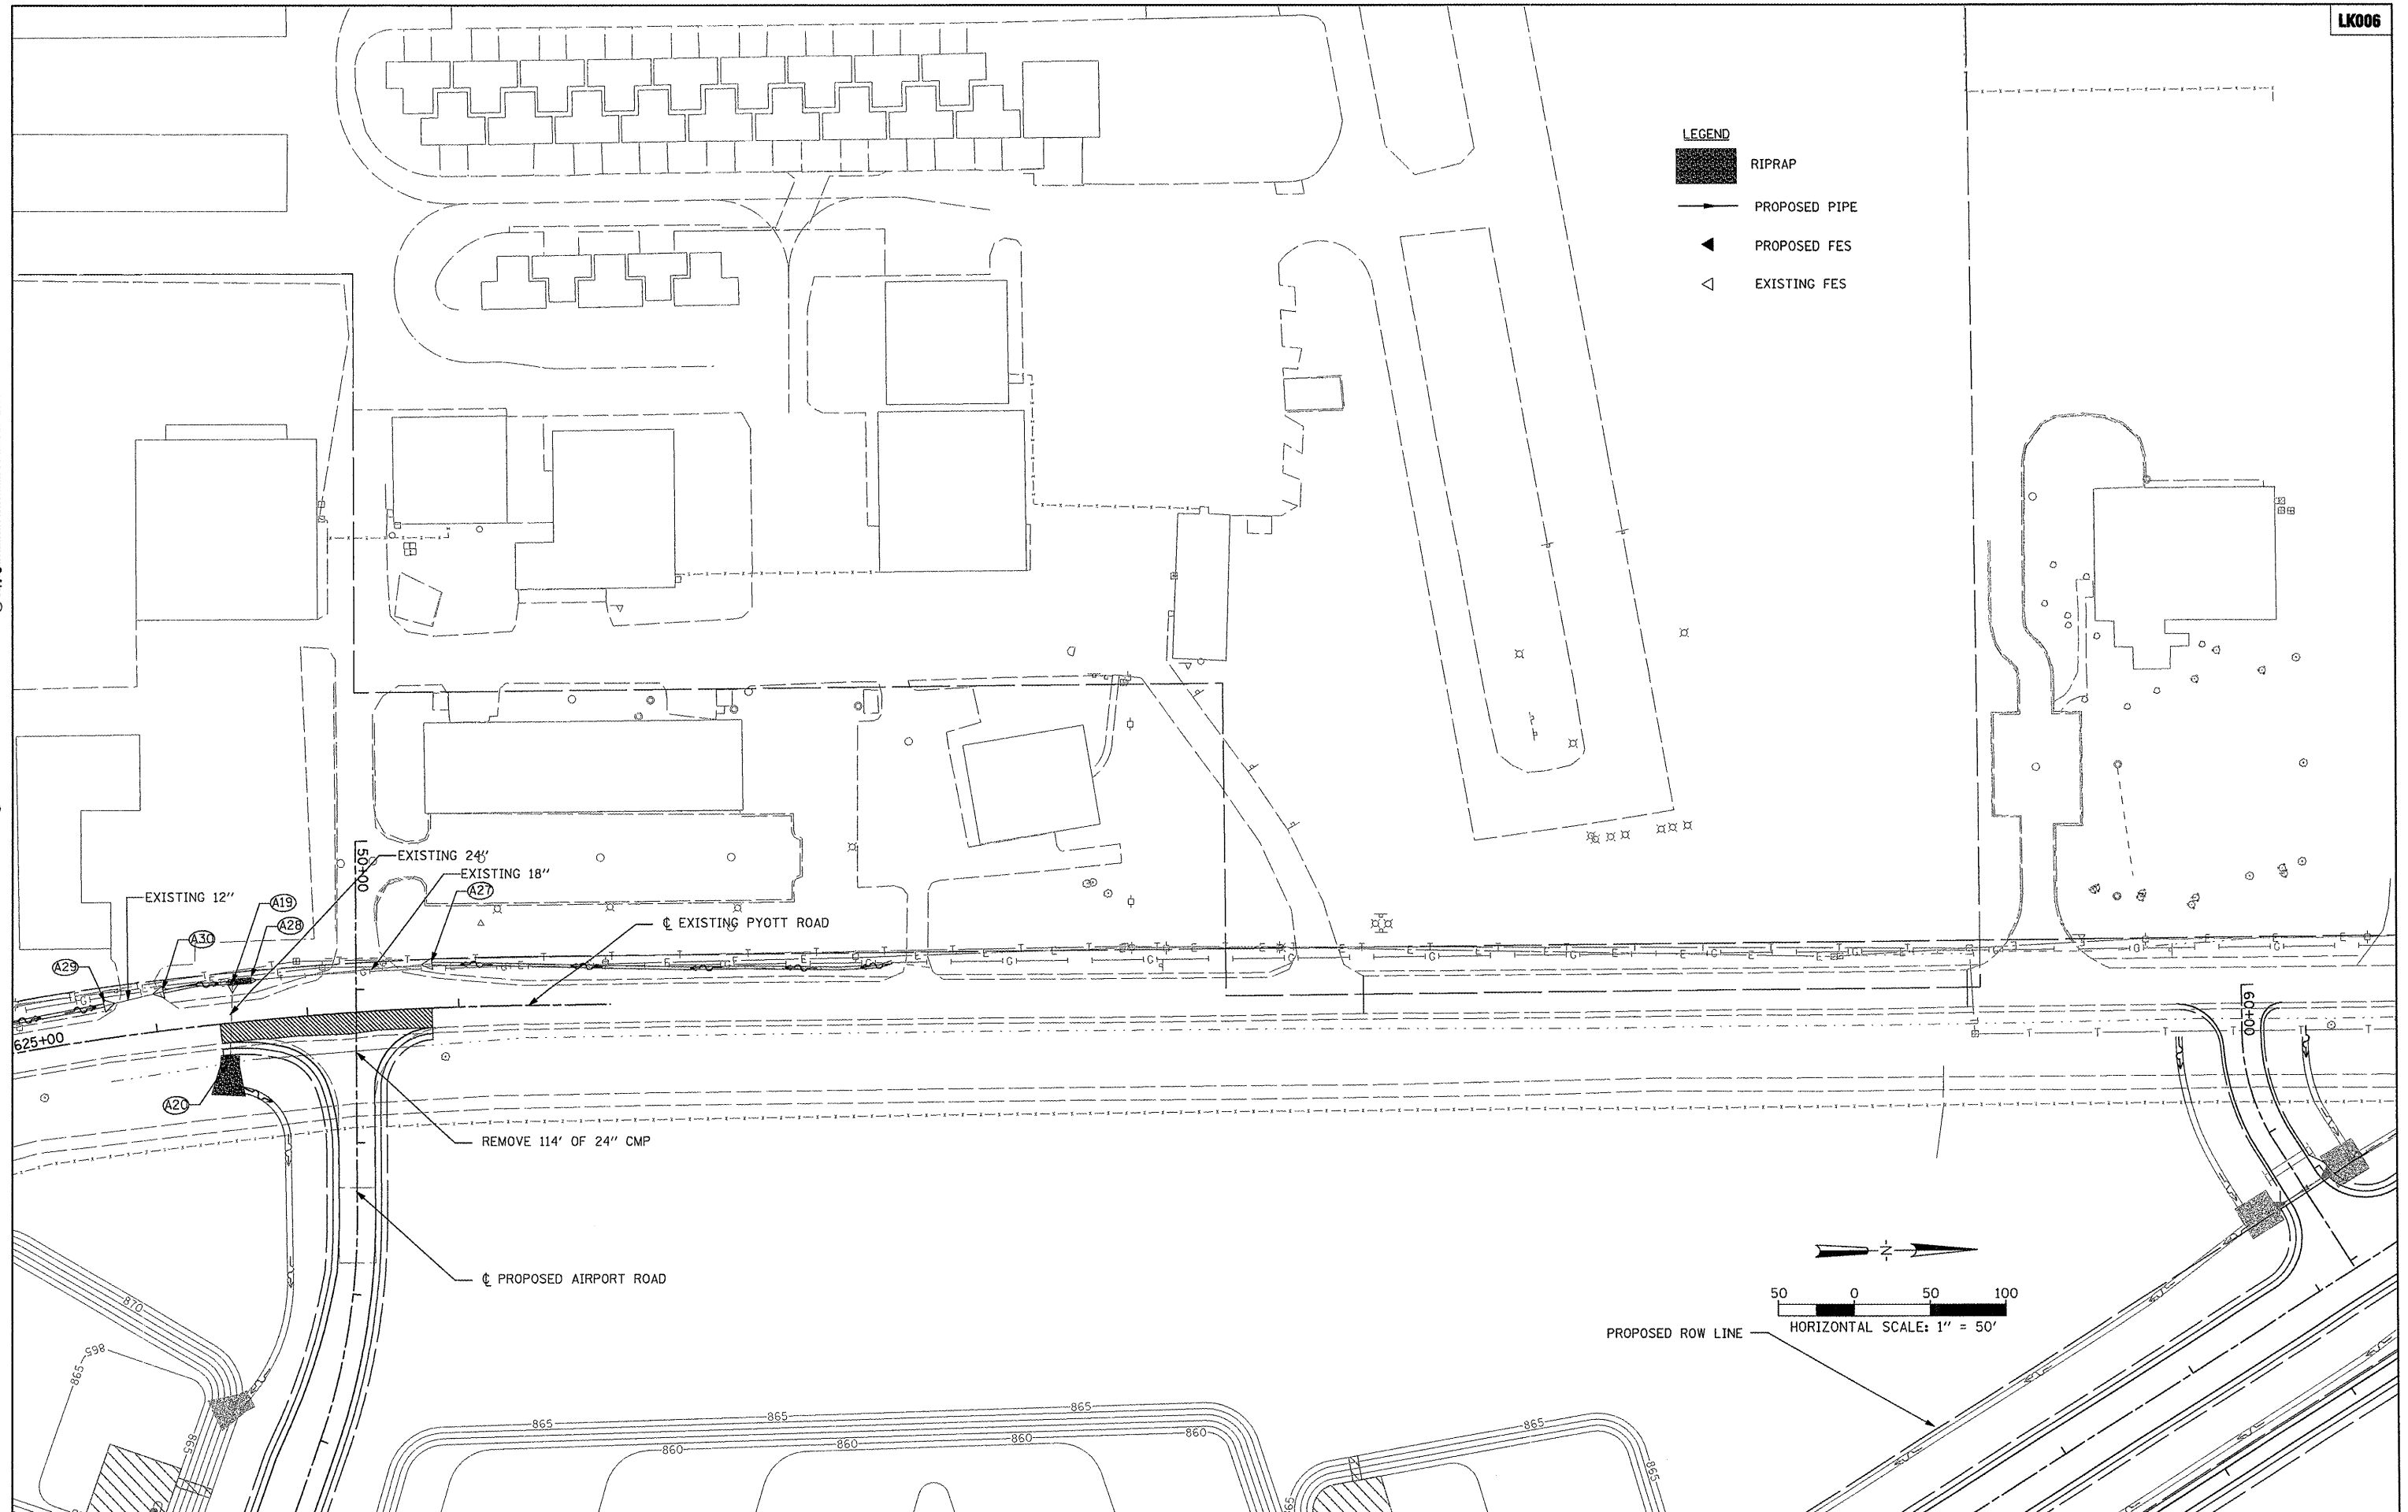


Hanson Professional Services Inc.
5000 S. 15th Street, Suite 200
Oak Brook, Illinois 60423
© Copyright Hanson Professional Services Inc. 2008



- LEGEND**
-  RIPRAP
 -  PROPOSED PIPE
 -  PROPOSED FES
 -  EXISTING FES



FILE NAME =	USER NAME = B1ein01219	DESIGNED - SJM	REVISED -	VILLAGE OF LAKE IN THE HILLS, ILLINOIS	PYOTT ROAD DRAINAGE PLAN	COUNTY	TOTAL SHEETS	SHEET NO.
\\05jobs\02041\05b021\civil part b\sheet\C-DRN2.aht	PLOT SCALE = 99.9998' / IN.	DRAWN - SJM	REVISED -			MCHENRY	143	44
PLOT DATE = 02/25/2009, 11:42 AM	DATE - 05/21/08	CHECKED - BLB	REVISED -			AIP NO. 3-17-0112-B10 [ILLINOIS] IDA NO. 3CK-3807		
		REVISOR -	REVISED -					