
 

 
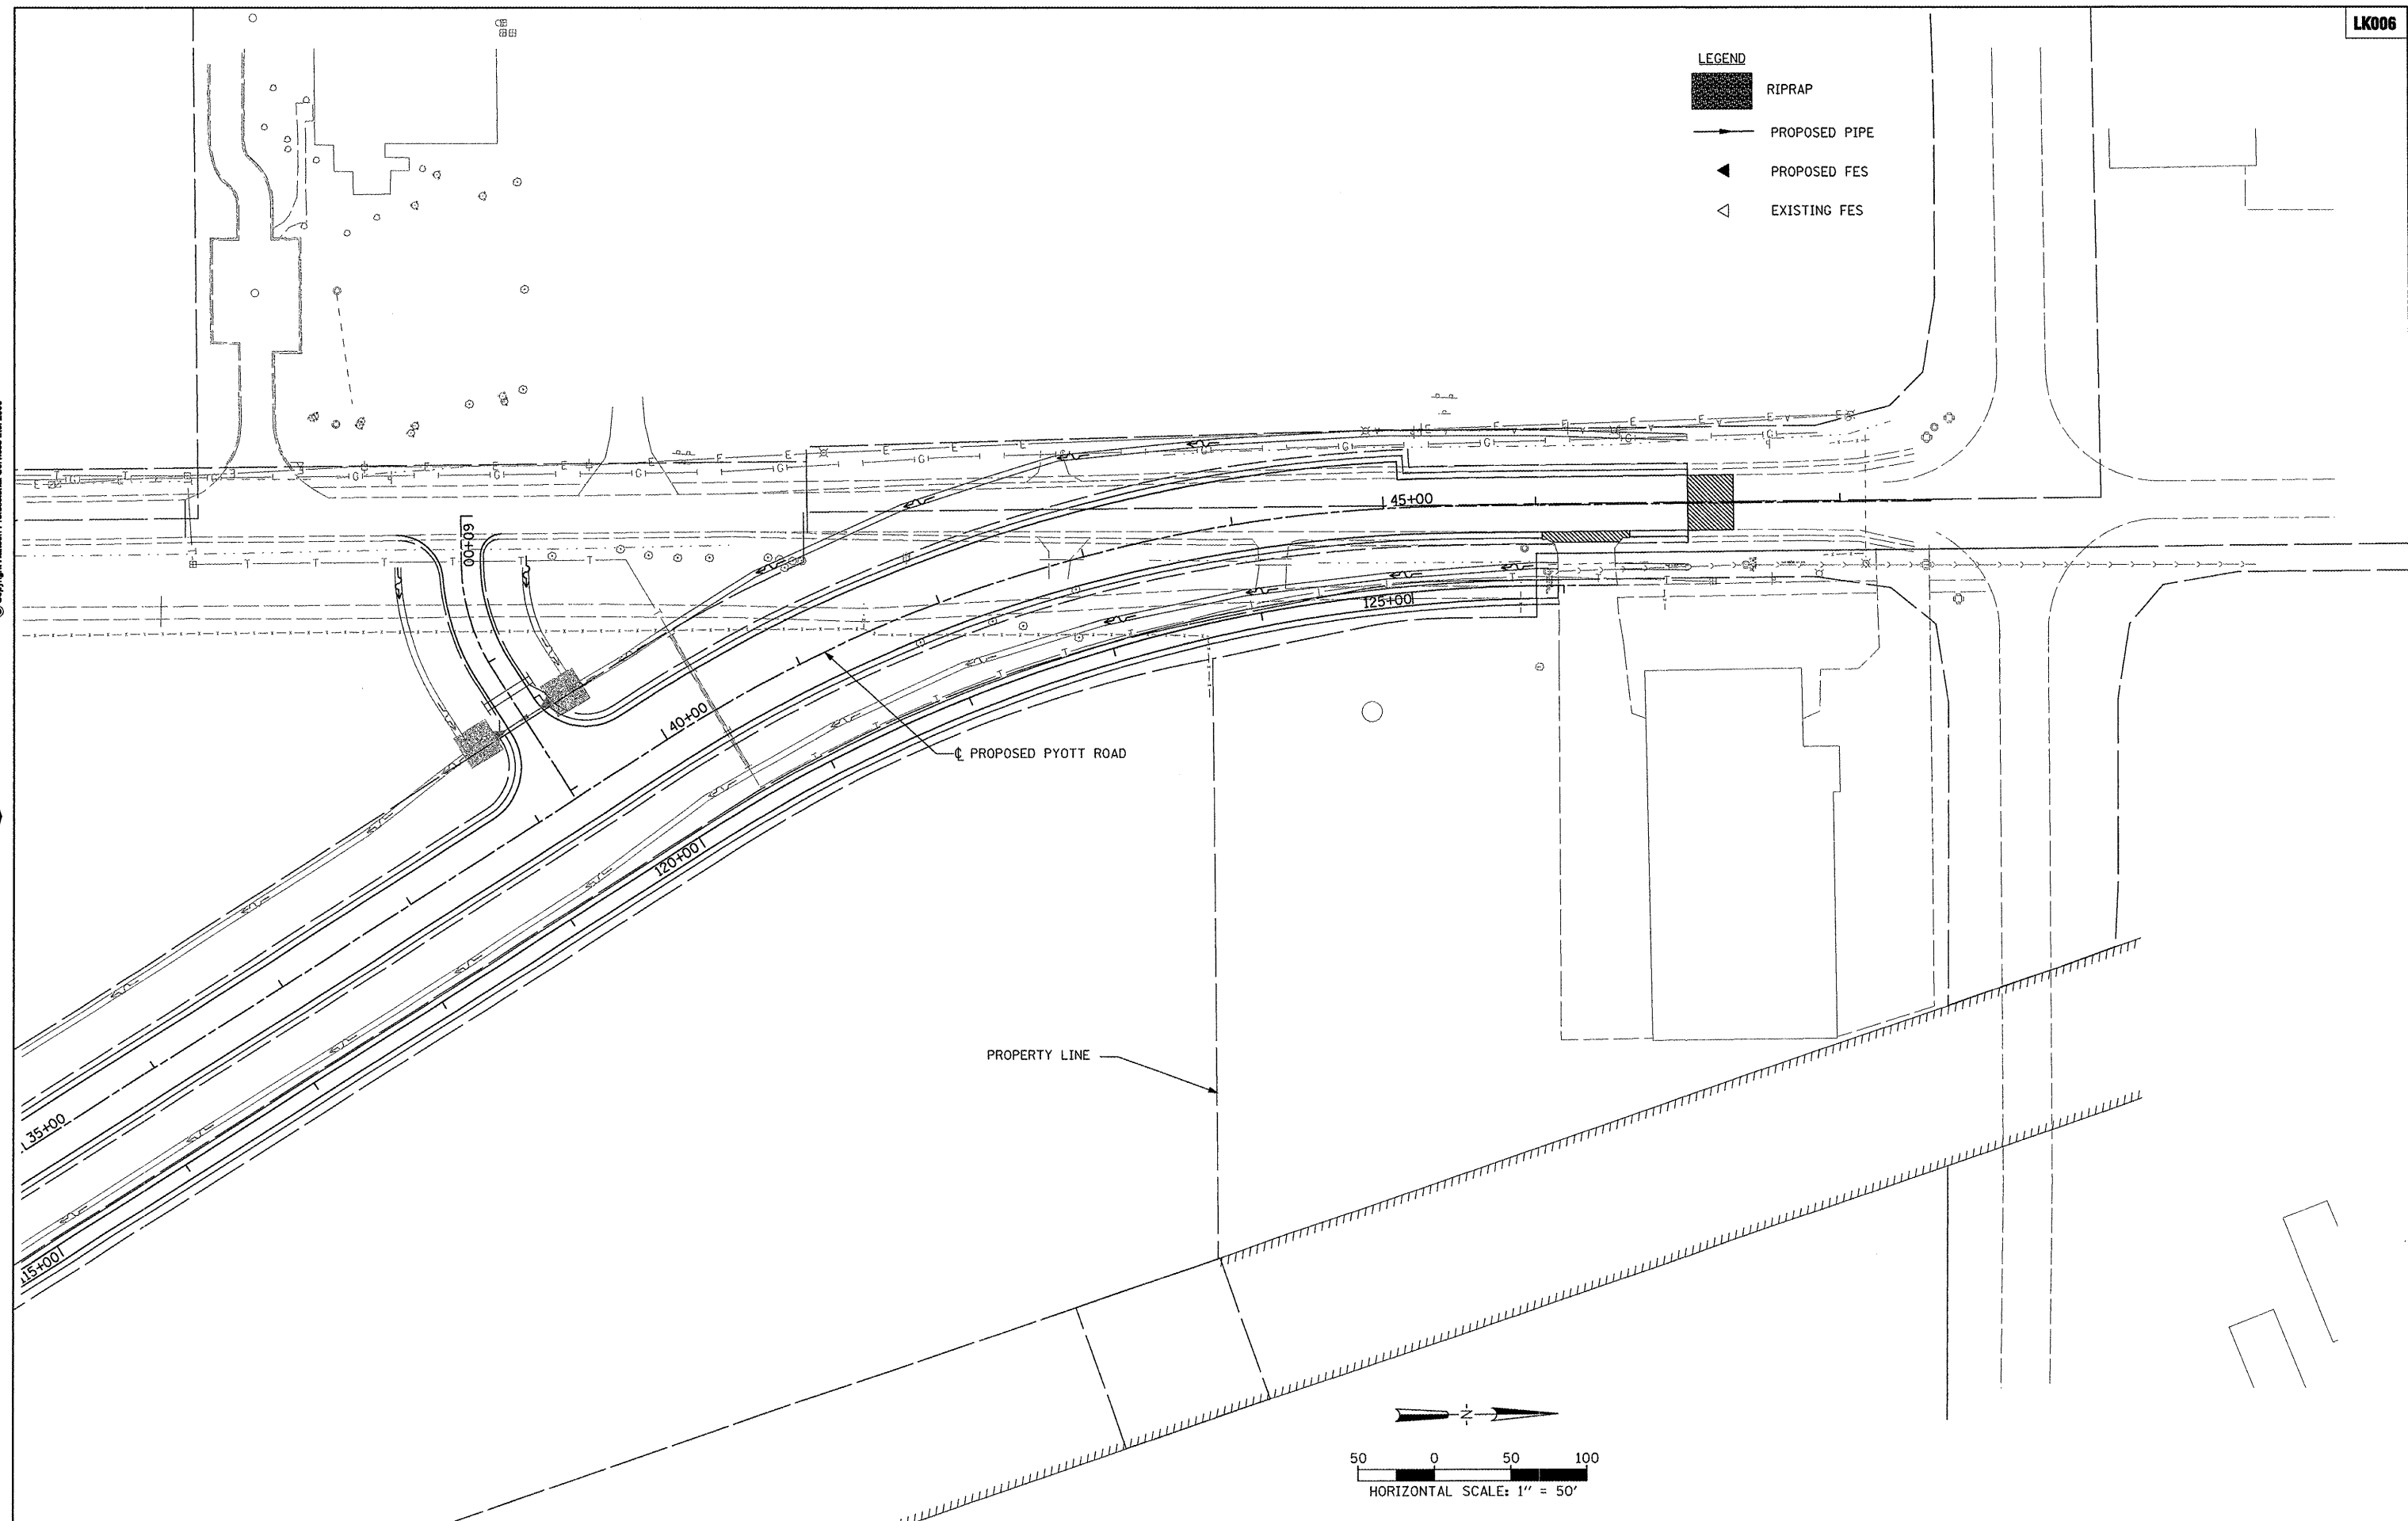


- LEGEND**
-  RIPRAP
 -  PROPOSED PIPE
 -  PROPOSED FES
 -  EXISTING FES

Hanson Professional Services Inc.
 Suite 200, 815 Commerce Drive
 Oak Brook, Illinois 60528
 © Copyright Hanson Professional Services Inc. 2008



FILE NAME =	USER NAME = Blein01219	DESIGNED - SJM	REVISED -
\\05jobs\00841\05b021\civil part b\sheet\C-DRM4.eht		DRAWN - SJM	REVISED -
		CHECKED - BLB	REVISED -
		DATE - 05/21/08	REVISED -

**VILLAGE OF
LAKE IN THE HILLS, ILLINOIS**

PYOTT ROAD DRAINAGE PLAN

COUNTY	TOTAL SHEETS	SHEET NO.
MCHENRY	143	46

AIP NO. 3-17-0112-810 ILLINOIS IDA NO. 3CX-3807

SCALE: 1"=50'