



CONTRACT NO. 89347			
F.A.U. RTE.	SECTION	COUNTY	TOTAL SHEET NO.
6761	04-00057-06-WR	TAZEWELL	154 80
STA. 55+00		TO STA. 61+00	
FED. ROAD DIST. NO. 4 ILLINOIS FED. AID PROJECT			

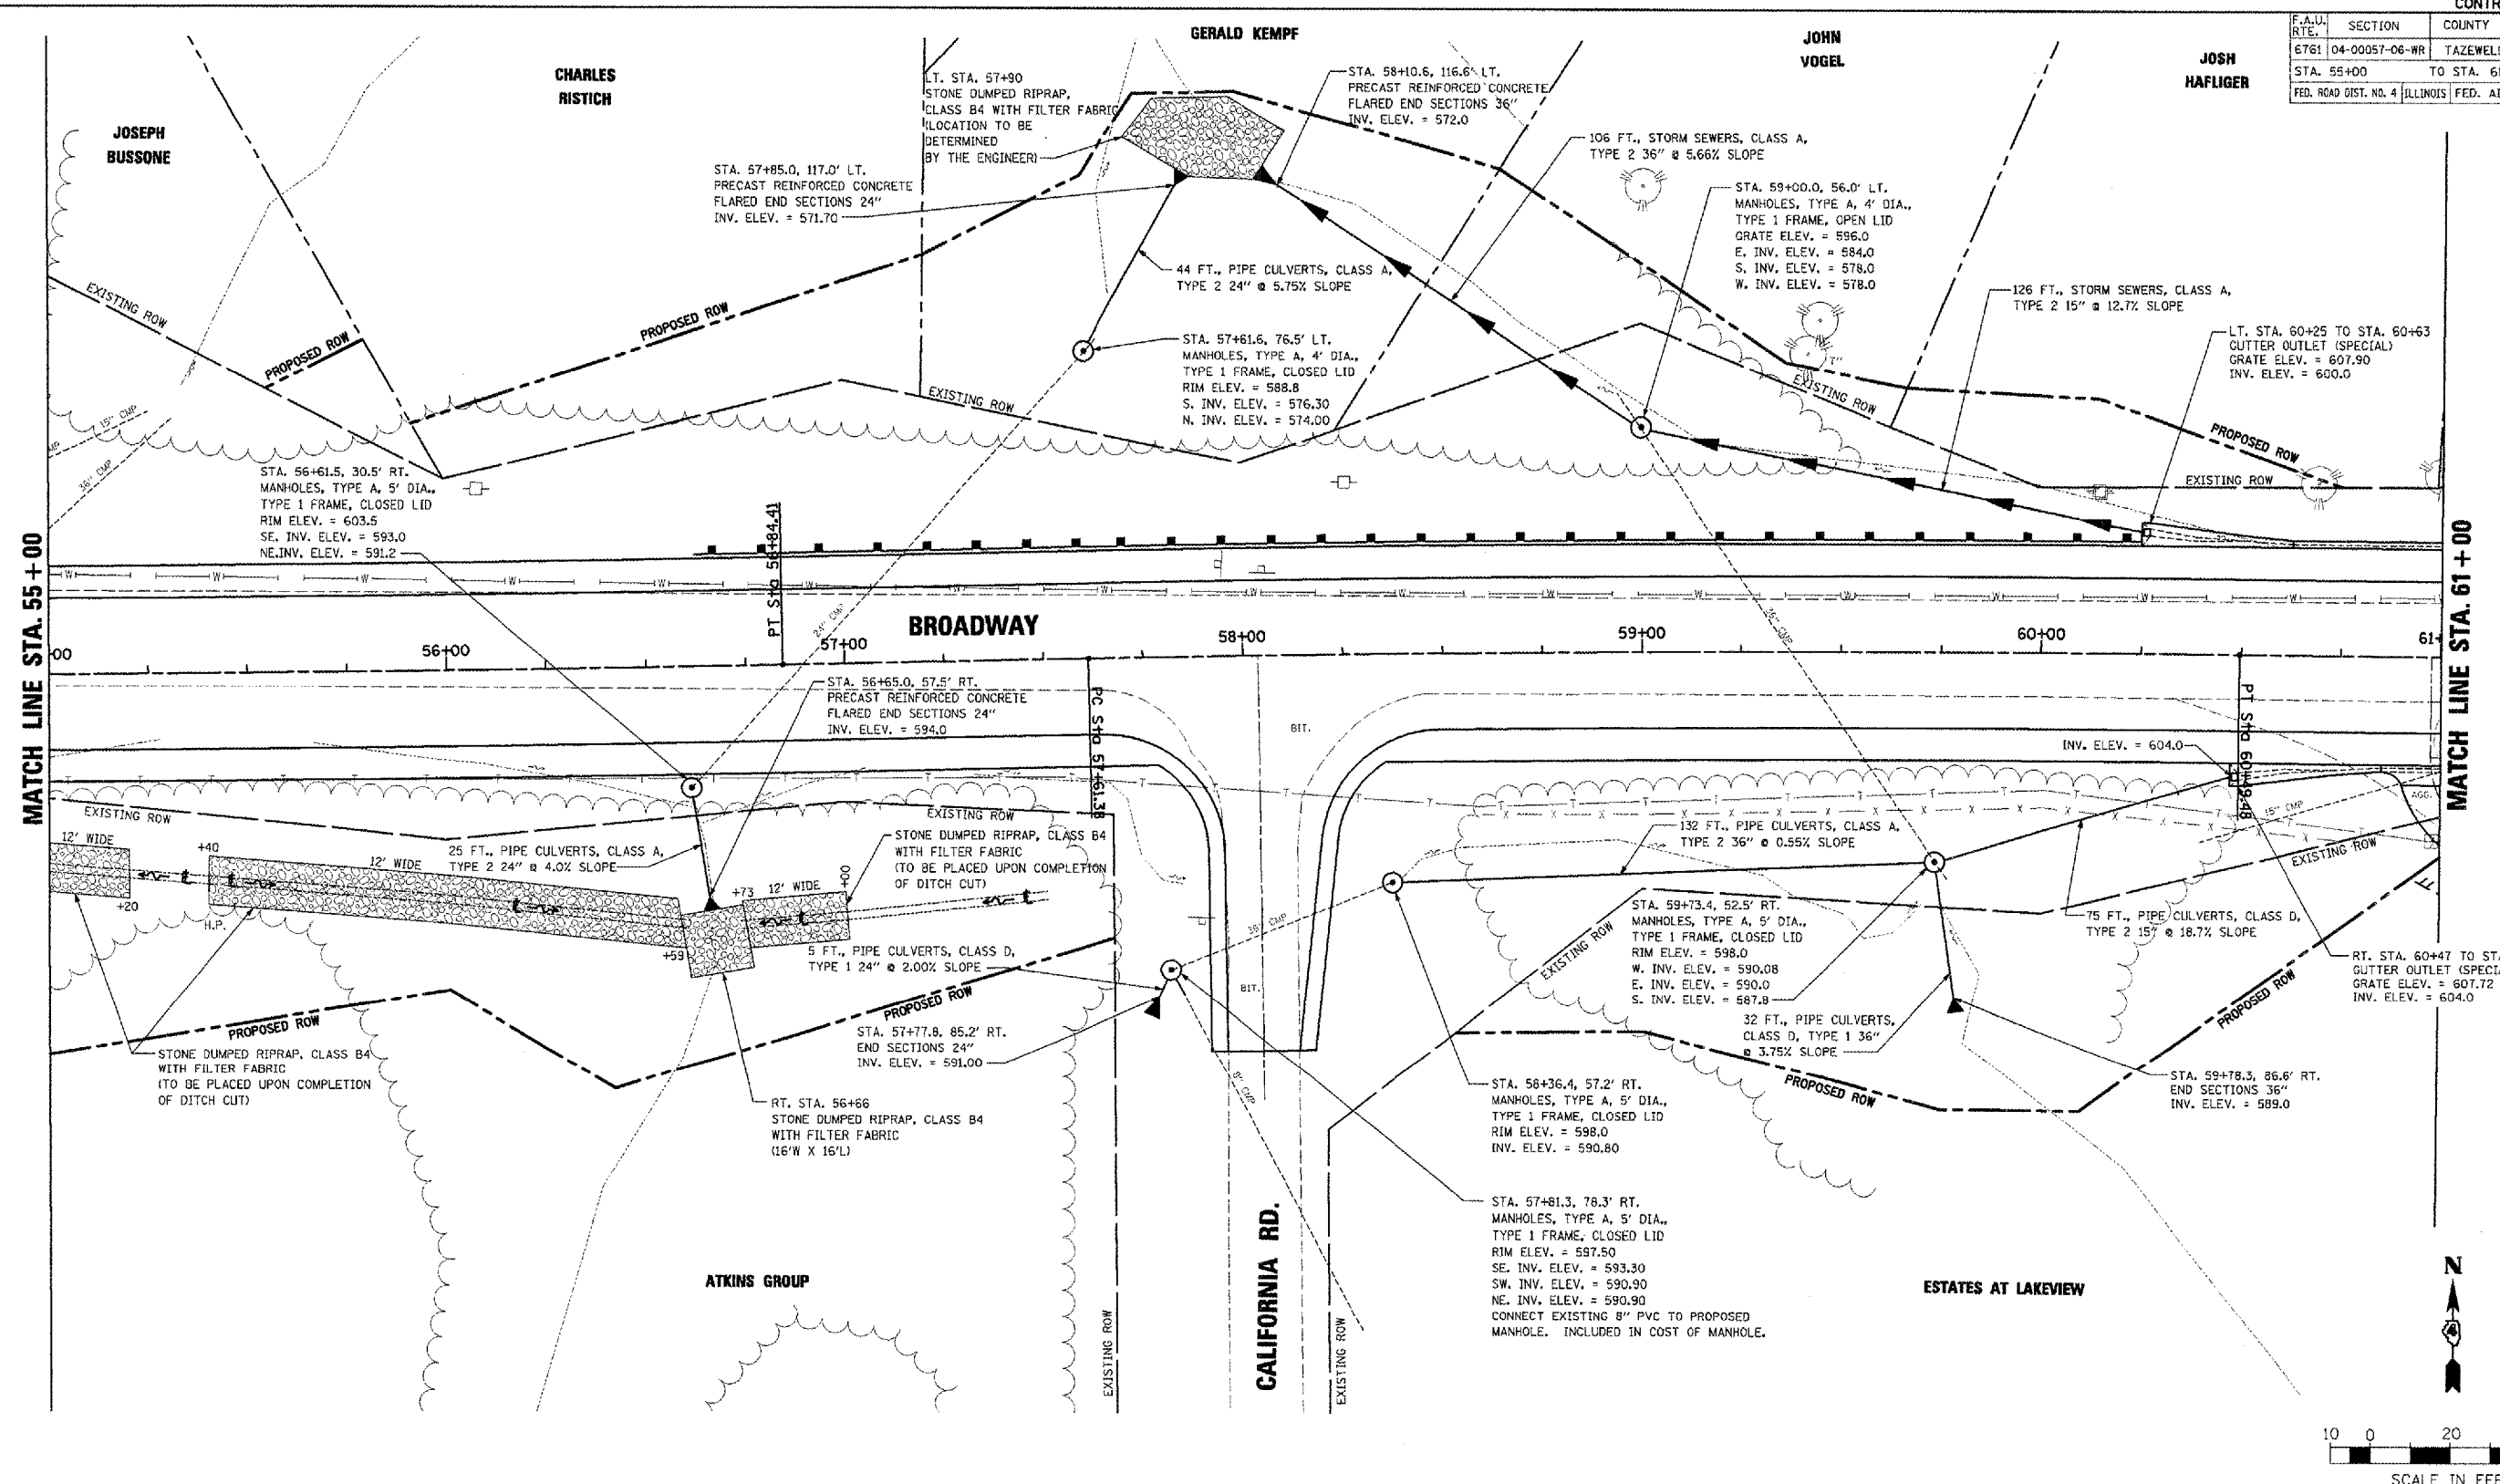

MATCH LINE STA. 55 + 00

MATCH LINE STA. 61 + 00

(SEE NEXT SHEET FOR PROFILE)

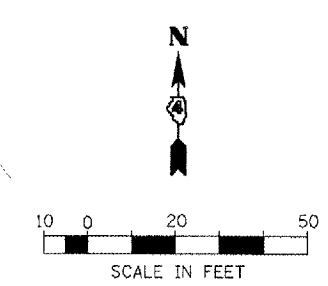

REVISIONS		ILLINOIS DEPARTMENT OF TRANSPORTATION
NAME	DATE	
		<p align="center"><b>BROADWAY DRAINAGE PLAN AND PROFILE STA. 55 + 00 TO STA. 61 + 00 SHEET 1 OF 2</b></p> <p>SCALE: AS SHOWN      DRAWN BY: DLC DATE: 12/07/2007      CHECKED BY: REW</p>

PLOT DATE = 2/07/2008  
 FILE NAME = I:\2008\86679\dwg\plan\UR-10 BR-61.dwg  
 PLOT SCALE = 20.0000 FT / IN  
 USER NAME = JDD