
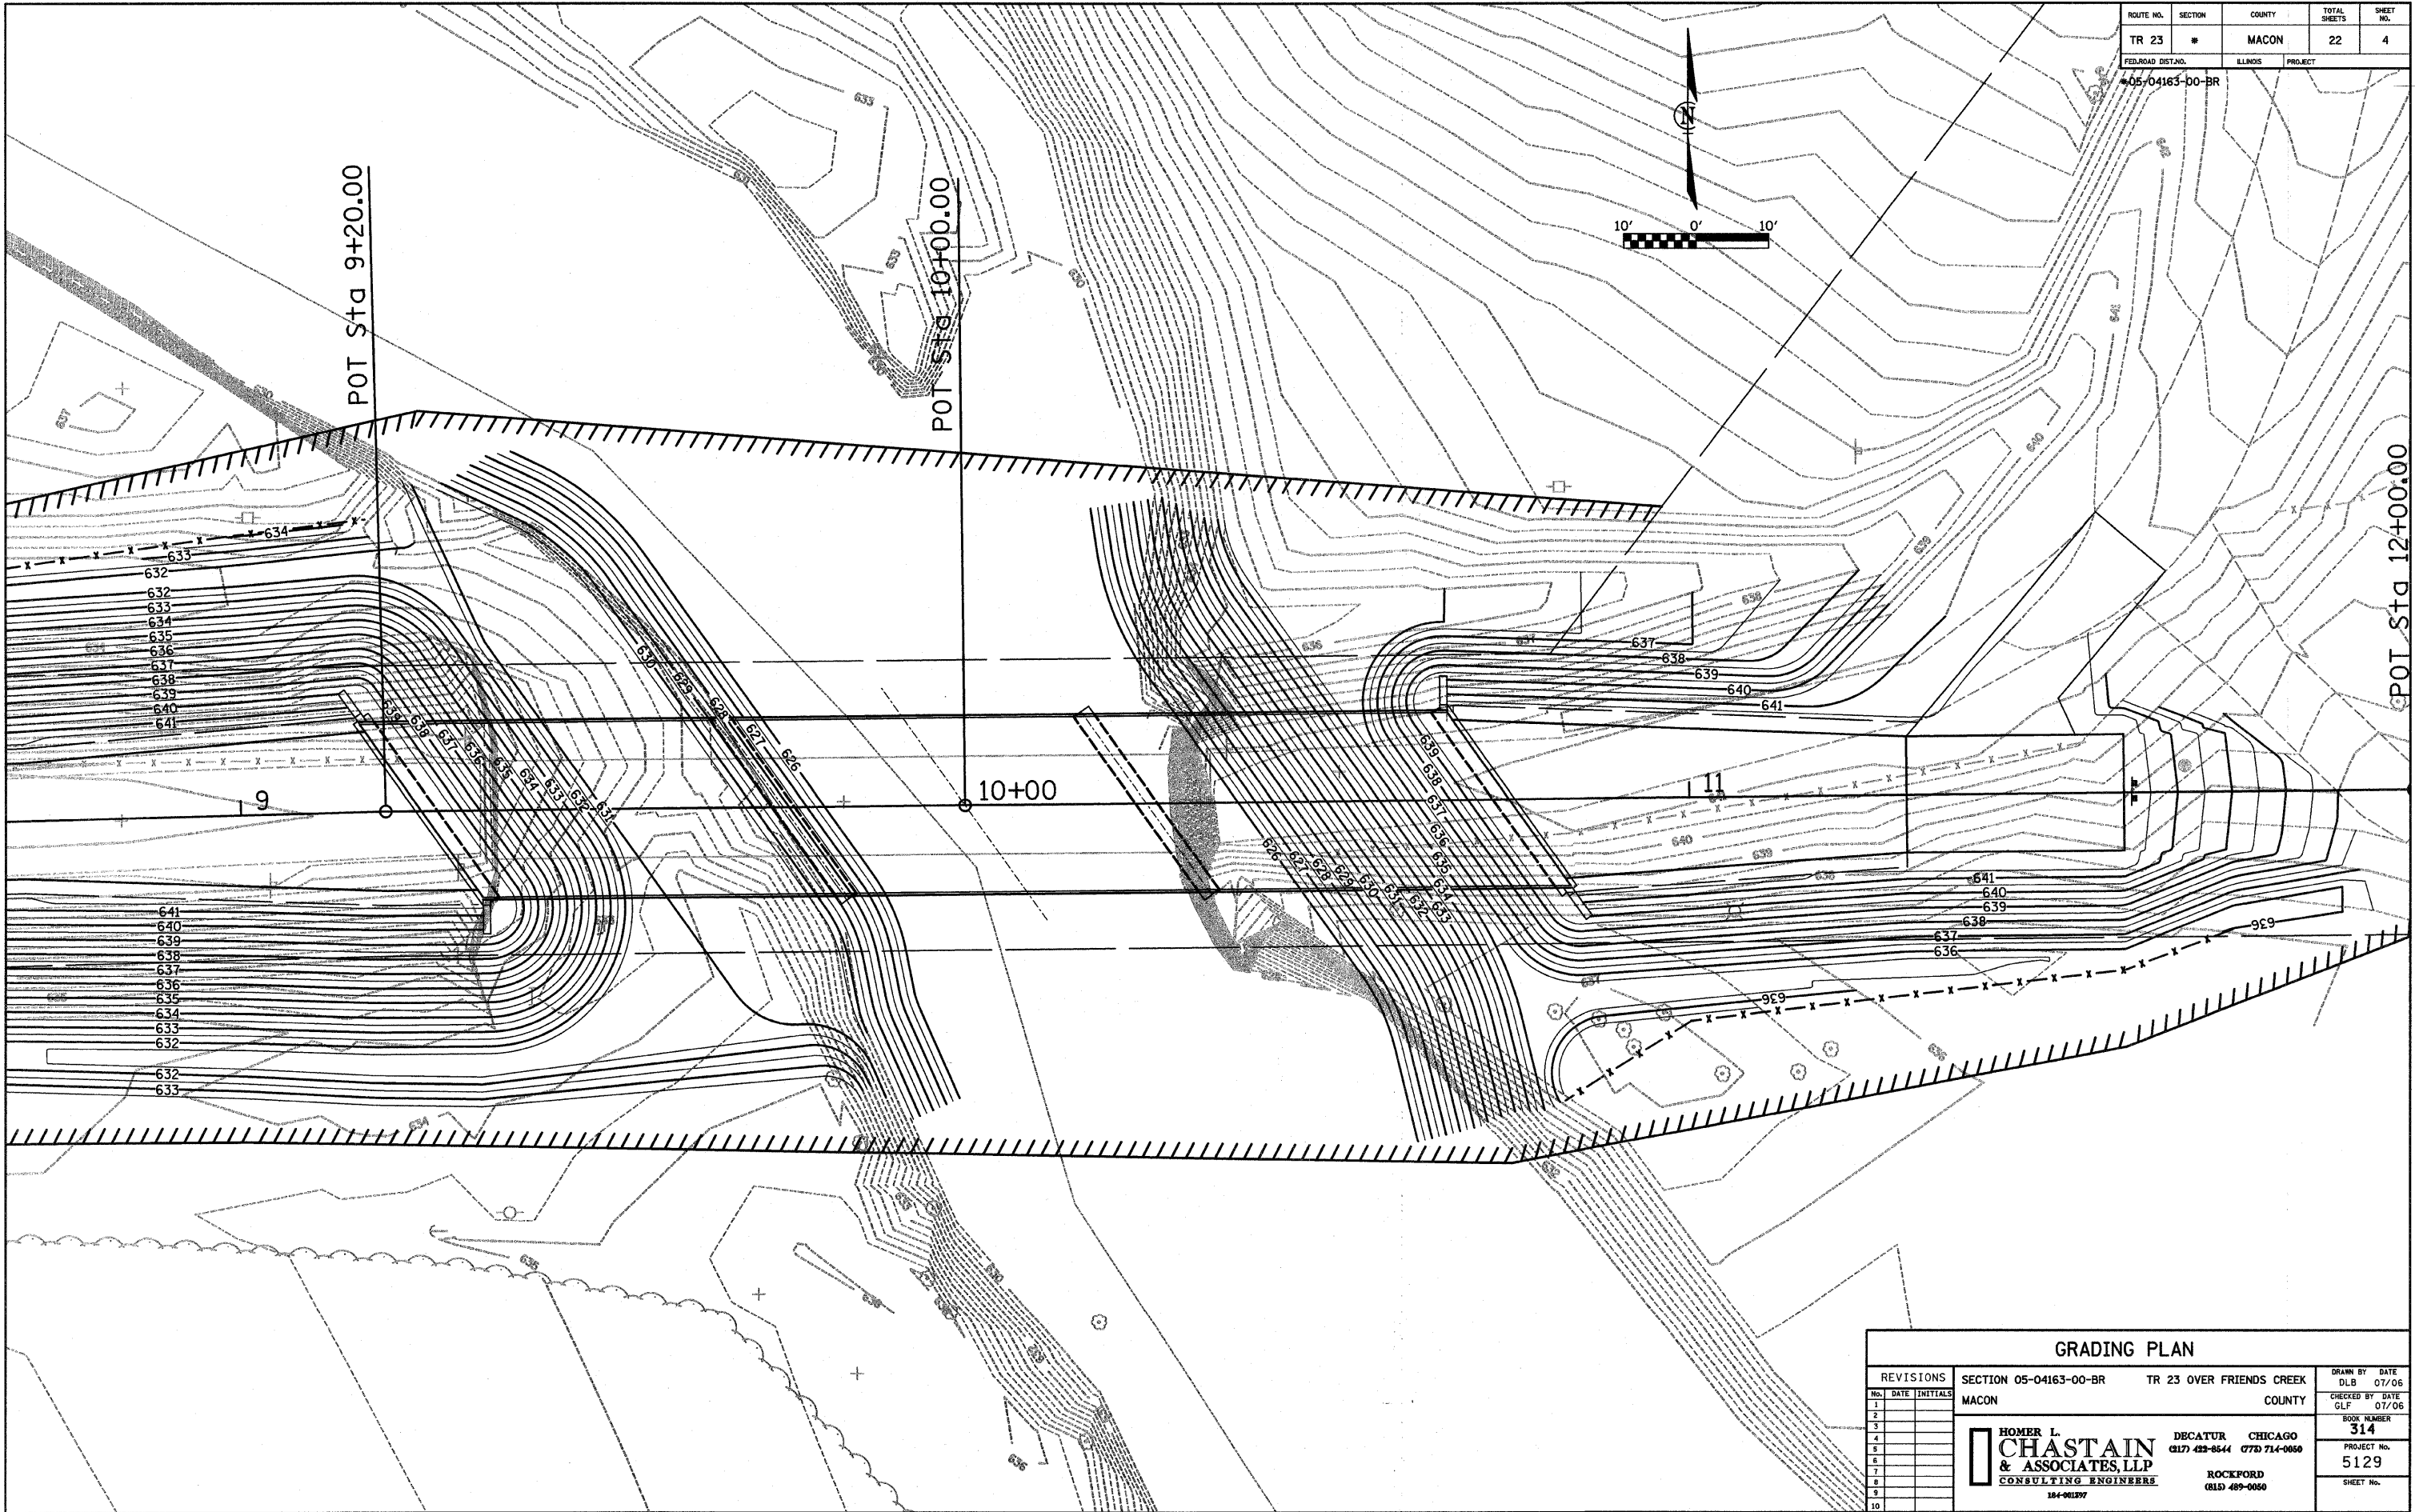


ROUTE NO.	SECTION	COUNTY	TOTAL SHEETS	SHEET NO.
TR 23	*	MACON	22	4
FED. ROAD DIST. NO.		ILLINOIS	PROJECT	
05/04163-00-BR				

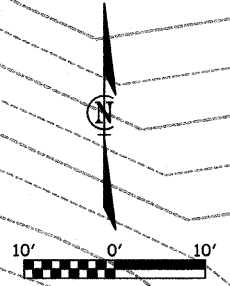

POT Sta 9+20.00

POT Sta 10+00.00

POT Sta 12+00.00

9

10+00

11

GRADING PLAN

REVISIONS			SECTION 05-04163-00-BR	TR 23 OVER FRIENDS CREEK	DRAWN BY DATE
No.	DATE	INITIALS	MACON	COUNTY	DLB 07/06
1					CHECKED BY DATE
2					GLF 07/06
3					BOOK NUMBER
4					314
5					PROJECT No.
6					5129
7					SHEET No.
8					
9					
10					

HOMER L. CHASTAIN & ASSOCIATES, LLP
 CONSULTING ENGINEERS
 184-001297

DECATUR CHICAGO
 (317) 422-8644 (773) 714-0050

ROCKFORD
 (815) 489-0050