
 


 



Hanson Professional Services Inc.
 Suite 200, 815 Commerce Drive
 Oak Brook, Illinois 60523
 © Copyright Hanson Professional Services Inc. 2008



- LEGEND**
-  RIPRAP
 -  TEMPORARY DITCH
 -  PROPOSED PIPE
 -  PROPOSED FES
 -  EXISTING FES

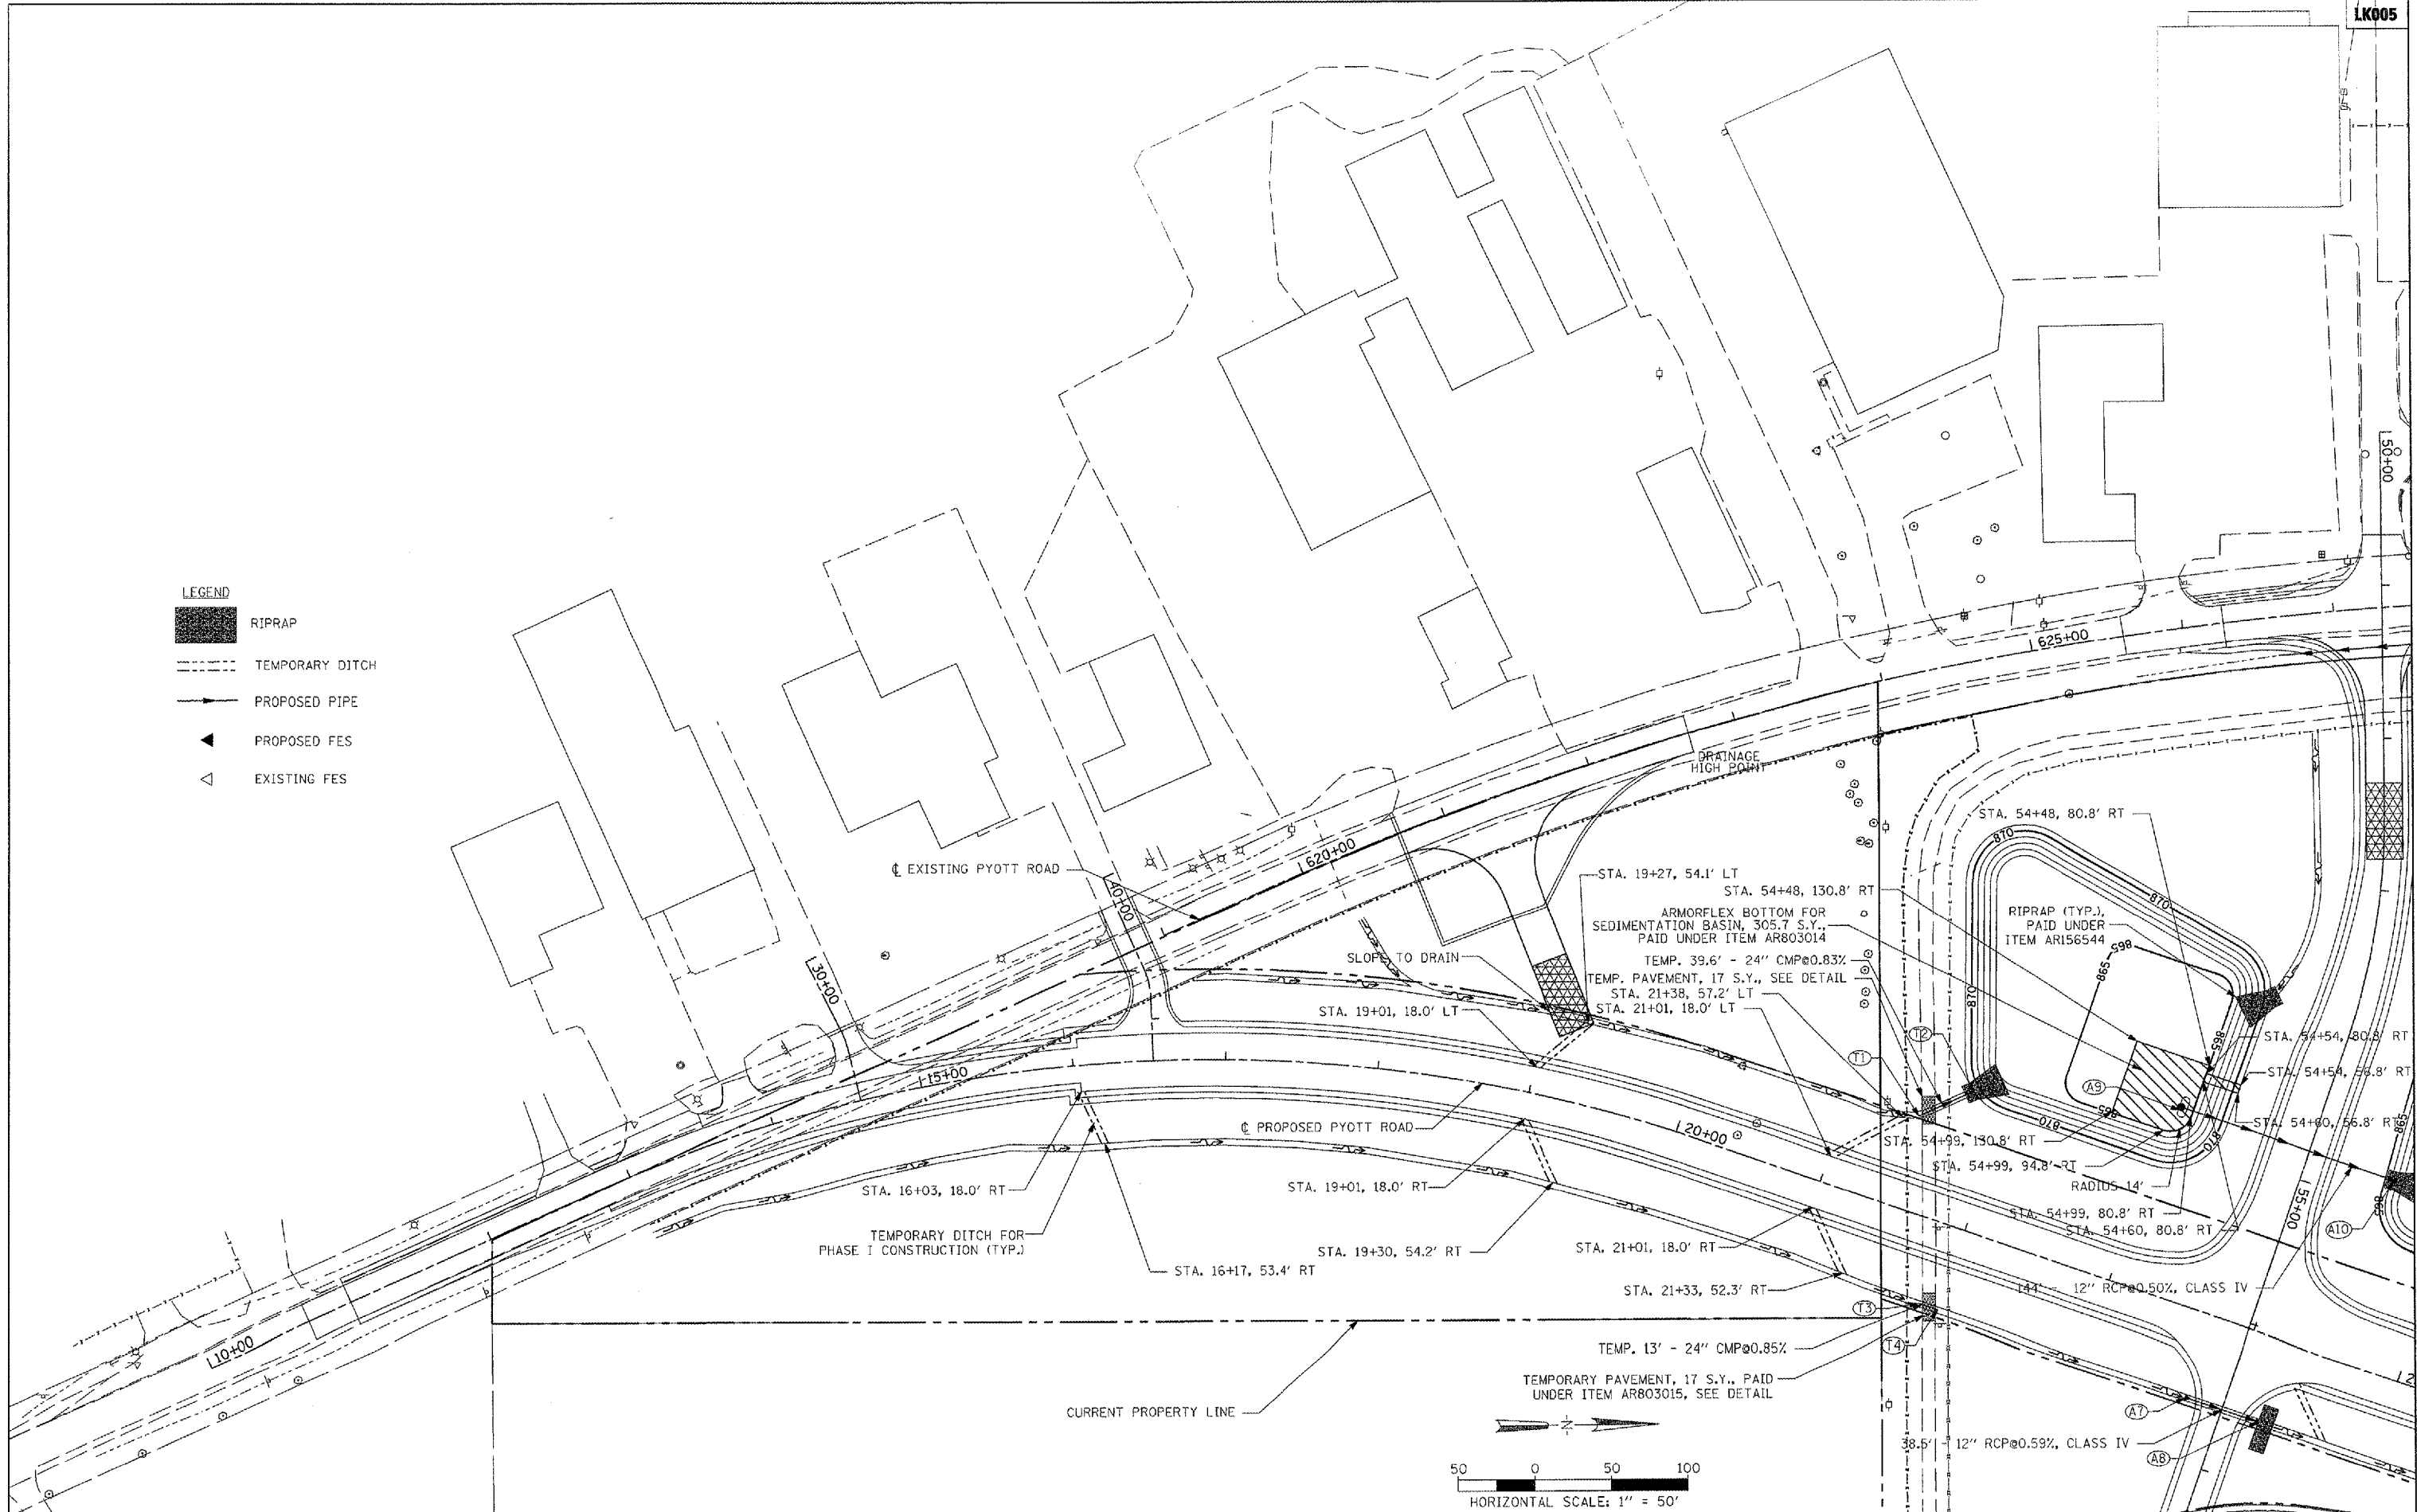

FILE NAME =	USER NAME = McLou01058	DESIGNED - SJM	REVISED -
I:\05Jobs\00041\0500021\Civil Part A\Sheet	tc\c-drn\lsh	DRAWN - SJM	REVISED -
	PLOT SCALE = 100.0000' / IN.	CHECKED - BLB	REVISED -
	PLOT DATE = 02/28/2008, 08:48 AM	DATE - 02/29/08	REVISED -

**VILLAGE OF
LAKE IN THE HILLS, ILLINOIS**

**DRAINAGE PLAN
PYOTT ROAD**

SCALE: 1"=50'	COUNTY	TOTAL SHEETS	SHEET NO.
	MCHENRY	120	26
FEDERAL AIP NO. 3-17-0112-BB ILLINOIS IDA NO. 3CK-3671			