
 



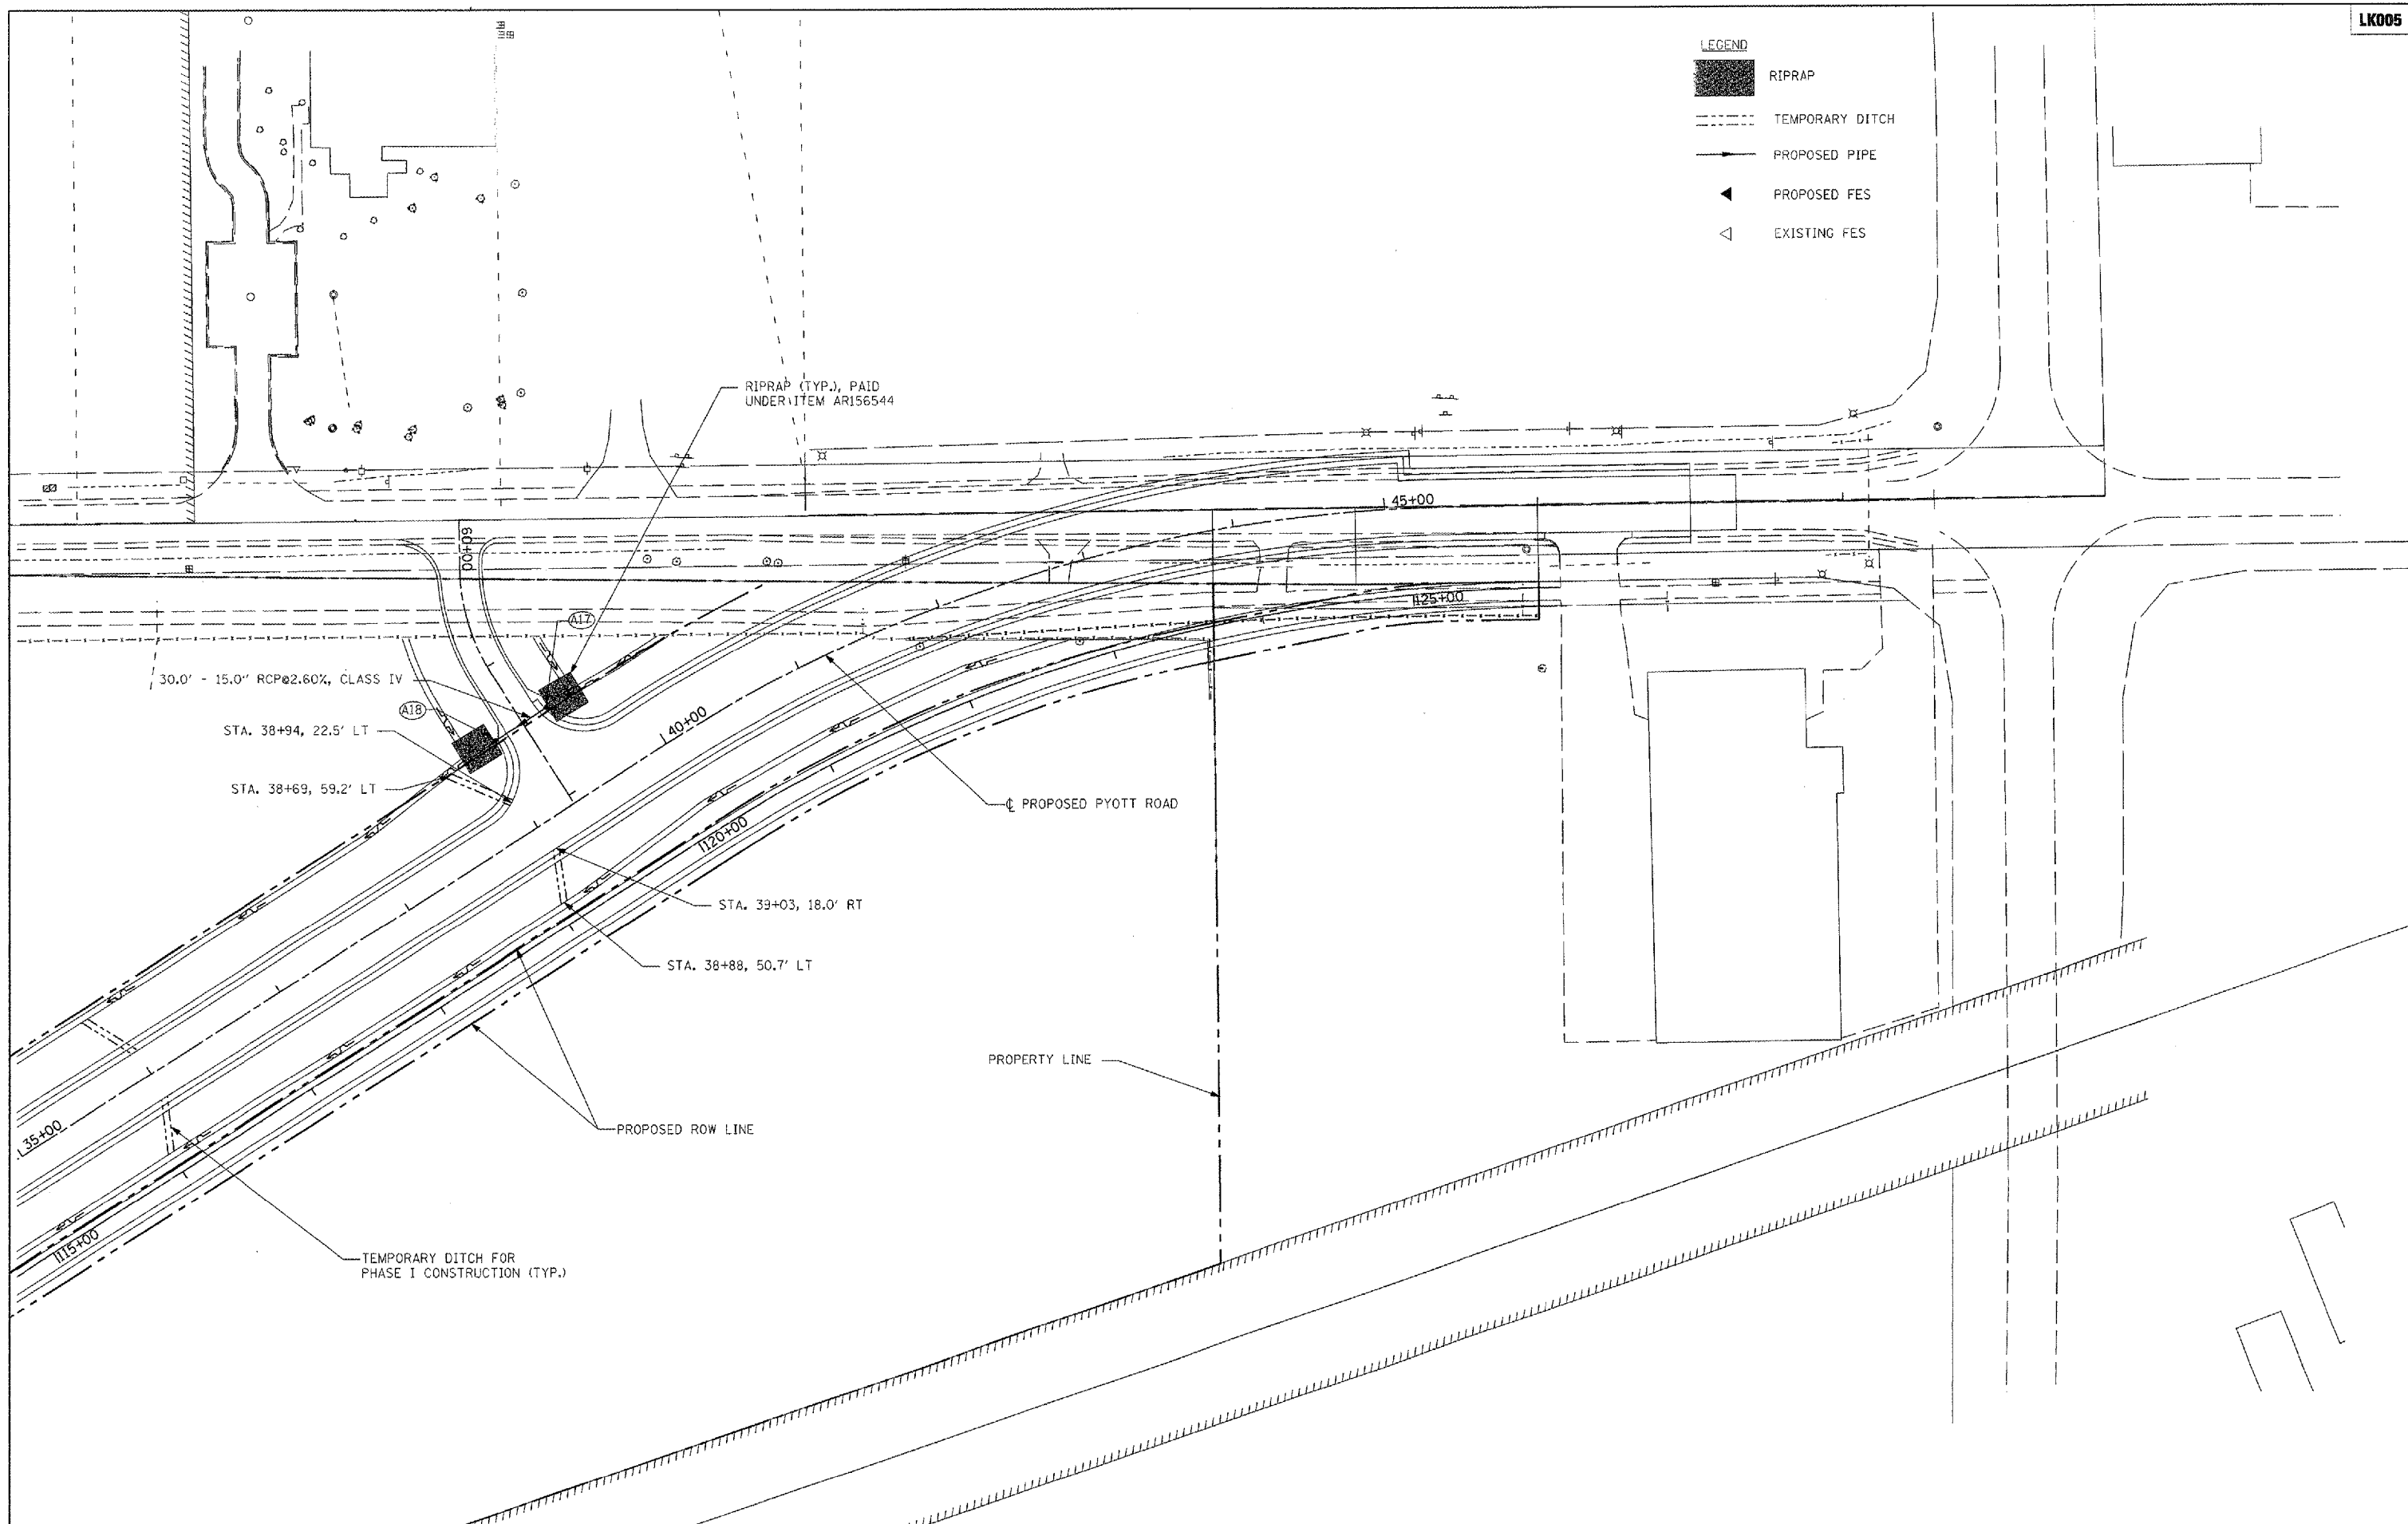


Hanson Professional Services Inc.
 Suite 200, 815 Commerce Drive
 Oak Brook, Illinois 60523
 © Copyright Hanson Professional Services Inc. 2008



- LEGEND**
-  RIPRAP
 -  TEMPORARY DITCH
 -  PROPOSED PIPE
 -  PROPOSED FES
 -  EXISTING FES



FILE NAME = I:\05Jobs\00641\0508021\Civil Part A\Sheets\CD-DRN4.sht	USER NAME = MoLu01058	DESIGNED - SJM	REVISED -	VILLAGE OF LAKE IN THE HILLS, ILLINOIS	DRAINAGE PLAN PYOTT ROAD	SCALE: 1"=50'	COUNTY	TOTAL SHEETS	SHEET NO.
	PLOT SCALE = 100.0000' / IN.	DRAWN - SJM	REVISED -				MCHENRY	120	29
PLOT DATE = 02/27/2008, 09:40 AM	CHECKED - BLB	DATE - 02/29/08	REVISED -	FEDERAL AIP NO. 3-17-0112-88 ILLINOIS IOA NO. 3CX-3671					