

REMOVING CATCH BASINS  
 94+54.2, 52.3 LT  
 94+54.5, 14.4 RT  
 98+26.0, 19.1 LT  
 98+33.1, 52.1 LT  
 98+34.1, 14.2 RT



REMOVING MANHOLES  
 94+84.6, 20.3 RT  
 98+44.8, 22.4 RT

STORM SEWER REMOVAL - 12"  
 STA. 94+54.2 TO 94+54.5 - 63'  
 STA. 94+54.5 TO 94+84.6 - 26'  
 STA. 98+33.1 TO 98+34.1 - 62'  
 STA. 98+34.1 TO 98+44.8 - 9'  
 STA. 98+26.0 TO 98+33.6 - 6'

STORM SEWER REMOVAL - 21"  
 STA. 94+84.6 TO 98+44.8 - 355'

SEE SHEET DU-12  
 MATCH LINE STA. 93+50.00

MATCH LINE STA. 99+50.00  
 SEE SHEET DU-14

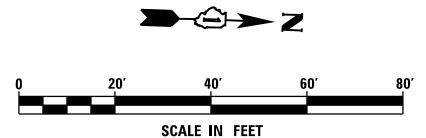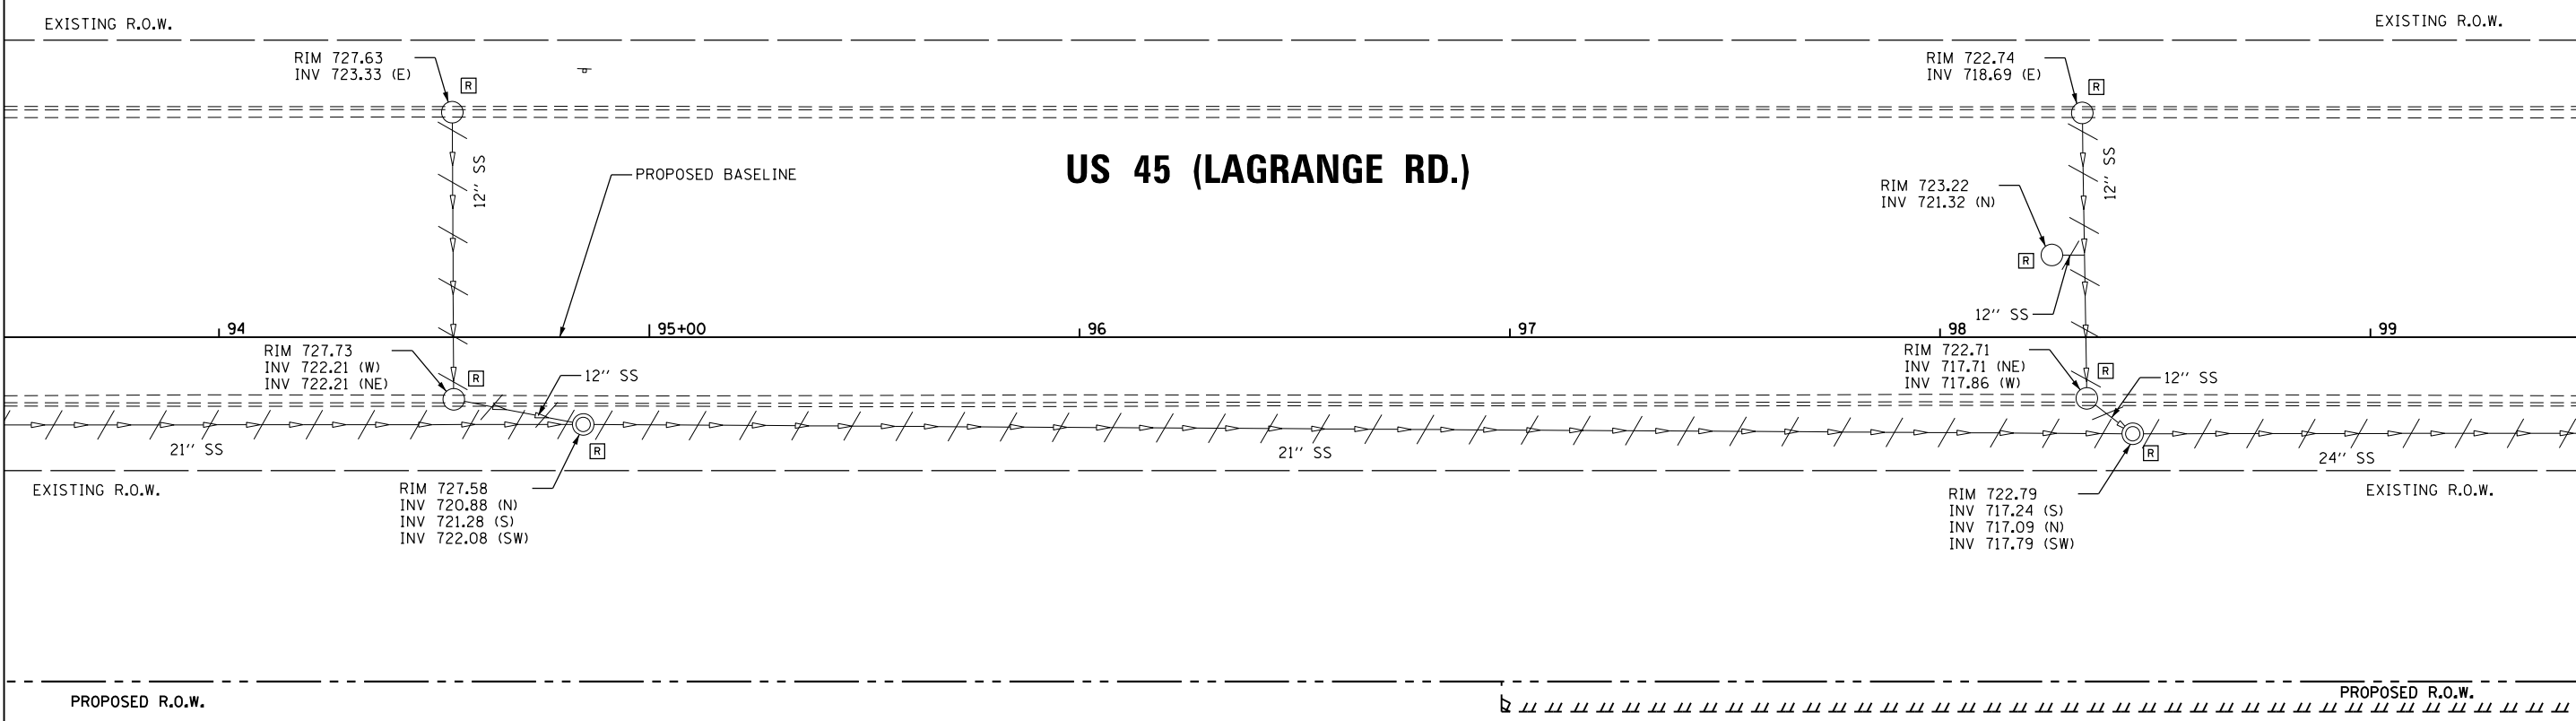

NOTE:  
 1. SEE DRAWING DN-01 FOR DRAINAGE LEGEND AND NOTES.  
 2. SEE DRAWINGS DS-01 THROUGH DS-11 FOR STRUCTURE AND PIPE INFORMATION

URS  
 100 S. WACKER DR.  
 SUITE 600  
 CHICAGO, IL 60606  
 TEL (312) 939-1000  
 FAX (312) 939-4998

|   |                             |                 |           |
|---|-----------------------------|-----------------|-----------|
| FILE NAME =<br>DI160F05-KEA-SHT-DRAINEX13.dgn | USER NAME = Frank_Stallone  | DESIGNED - MGS  | REVISED - |
| SHT.PLAN                                      | PLOT SCALE = 40.0001' / in. | DRAWN - REW     | REVISED - |
|   | PLOT DATE = 3/14/2013       | CHECKED - JRS   | REVISED - |
|   |                             | DATE - 03/13/13 | REVISED - |

STATE OF ILLINOIS  
 DEPARTMENT OF TRANSPORTATION

EXISTING DRAINAGE PLAN - US 45 (LAGRANGE ROAD)  
 SCALE: 1"=20' SHEET 13 OF 35 SHEETS STA. 93+50.00 TO STA. 99+50.00

|                           |                   |                |                     |                  |
|---------------------------|-------------------|----------------|---------------------|------------------|
| F.A.P. RTE.<br>330        | SECTION<br>103R-3 | COUNTY<br>COOK | TOTAL SHEETS<br>932 | SHEET NO.<br>269 |
| DU-13                     |                   |                | CONTRACT NO. 60F05  |                  |
| ILLINOIS FED. AID PROJECT |                   |                |                     |                  |