


REMOVING INLETS  
 119+22.4, 52.4 LT  
 119+22.8, 14.1 RT  
 122+19.4, 16.4 RT  
 122+24.5, 50.5 LT

REMOVING MANHOLES  
 119+31.2, 21.0 RT  
 122+81.4, 24.3 RT

REMOVING CATCH BASINS  
 122+15.6, 17.1 LT

STORM SEWER REMOVAL - 12"  
 STA. 119+22.4 TO 119+22.8 - 64'  
 STA. 119+22.8 TO 119+31.2 - 7'  
 STA. 122+24.5 TO 122+19.4 - 67'  
 STA. 122+19.4 TO 122+22.2 - 6'  
 STA. 122+15.6 TO 122+21.8 - 8'

STORM SEWER REMOVAL - 15"  
 STA. 119+31.2 TO 122+81.4 - 346'

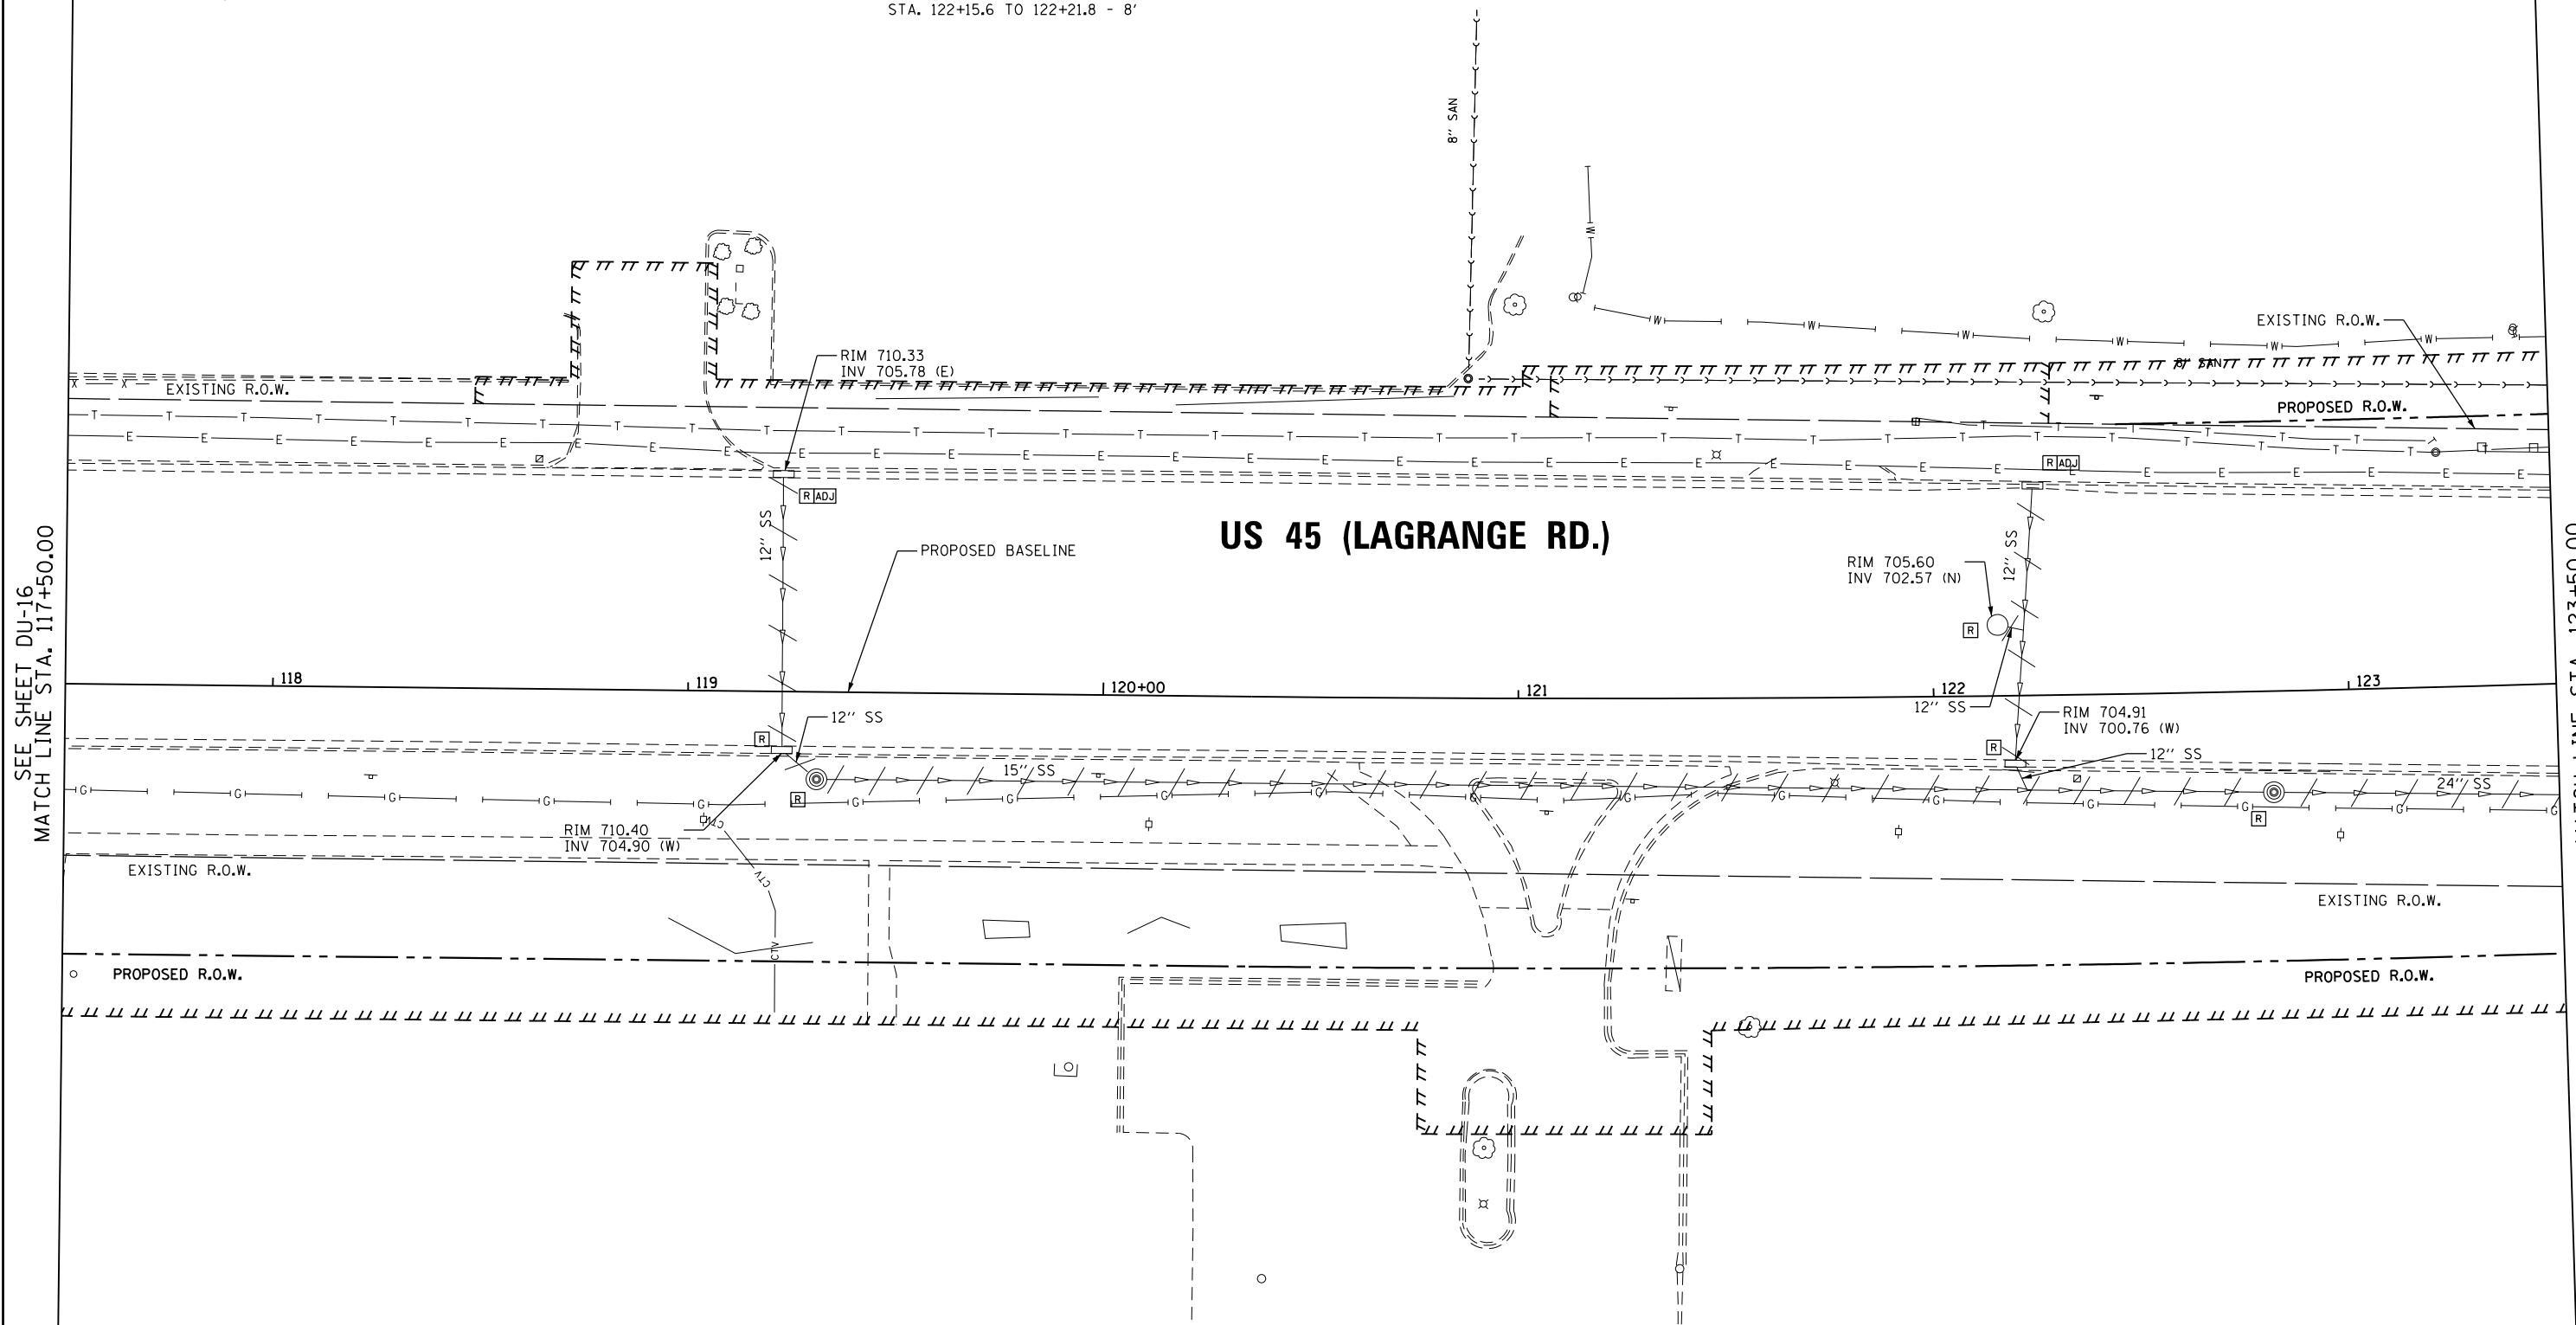


SEE SHEET DU-16  
 MATCH LINE STA. 117+50.00

MATCH LINE STA. 123+50.00  
 SEE SHEET DU-18

**US 45 (LAGRANGE RD.)**

NOTE:  
 1. SEE DRAWING DN-01 FOR DRAINAGE LEGEND AND NOTES.  
 2. SEE DRAWINGS DS-01 THROUGH DS-11 FOR STRUCTURE AND PIPE INFORMATION

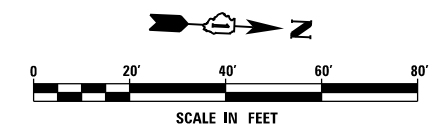

URS  
 100 S. WACKER DR.  
 SUITE 600  
 CHICAGO, IL 60606  
 TEL (312) 939-1000  
 FAX (312) 939-4198

FILE NAME = D160F05-KEA-SHT-DRAINEX17.dgn	USER NAME = Frank_Stallone	DESIGNED - MGS	REVISED -
SHT.PLAN	PLOT SCALE = 40.0001' / in.	DRAWN - REW	REVISED -
	PLOT DATE = 3/14/2013	CHECKED - JRS	REVISED -
		DATE - 03/13/13	REVISED -

STATE OF ILLINOIS  
 DEPARTMENT OF TRANSPORTATION

EXISTING DRAINAGE PLAN - US 45 (LAGRANGE ROAD)

SCALE: 1"=20' SHEET 17 OF 35 SHEETS STA. 117+50.00 TO STA. 123+50.00

F.A.P. RTE.	SECTION	COUNTY	TOTAL SHEETS	SHEET NO.
330	103R-3	COOK	932	273
<b>DU-17</b>			<b>CONTRACT NO. 60F05</b>	
ILLINOIS FED. AID PROJECT				