


REMOVING INLETS
 124+15.6, 23.9 RT
 124+16.8, 42.8 LT
 125+66.3, 29.9 RT
 125+66.7, 36.7 LT
 125+75.4, 30.2 RT
 125+76.6, 36.5 LT
 127+92.7, 33.3 LT
 127+96.7, 33.6 RT

FLARED END SECTION REMOVAL
 124+30.0, 53.7 RT
 126+19.3, 76.9 LT
 126+24.7, 76.9 LT
 127+15.5, 47.0 RT
 127+53.1, 47.9 RT

CONCRETE HEADWALL REMOVAL
 126+34.7, 43.6 RT

SEE DU-34 FOR 165TH ST. EXISTING DRAINAGE

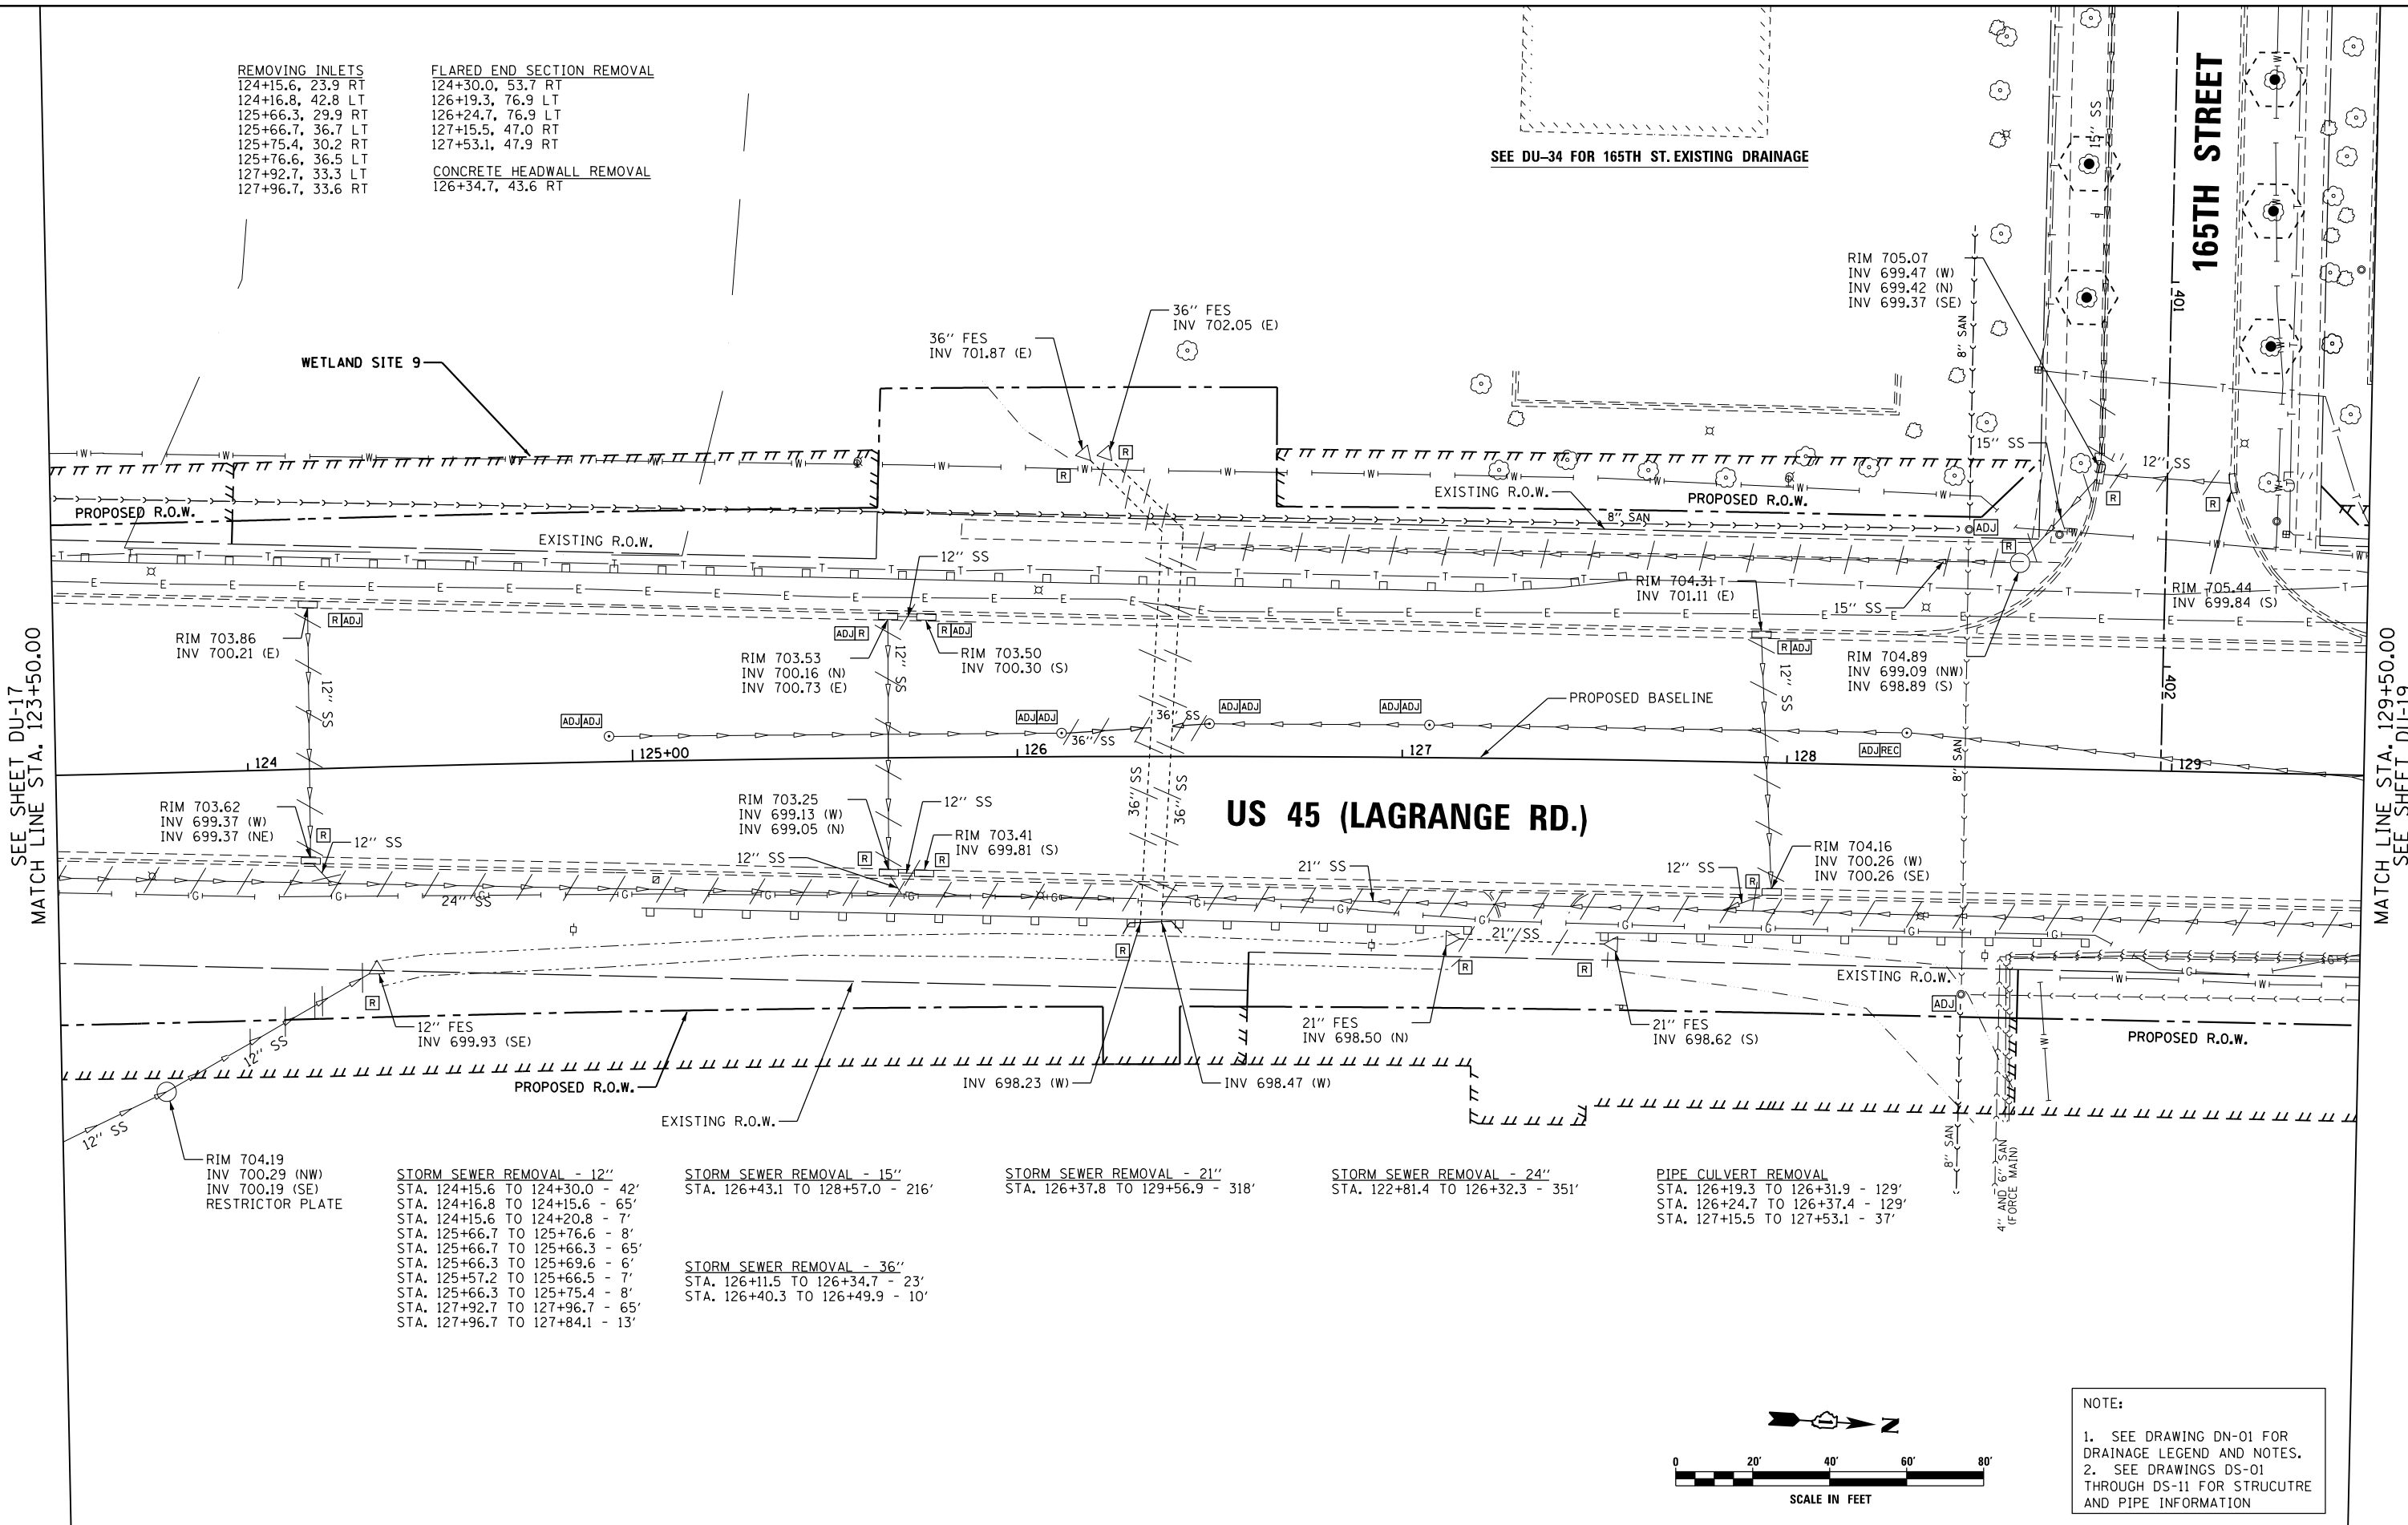

SEE SHEET DU-17
 MATCH LINE STA. 123+50.00

MATCH LINE STA. 129+50.00
 SEE SHEET DU-19

STORM SEWER REMOVAL - 12"
 STA. 124+15.6 TO 124+30.0 - 42'
 STA. 124+16.8 TO 124+15.6 - 65'
 STA. 124+15.6 TO 124+20.8 - 7'
 STA. 125+66.7 TO 125+76.6 - 8'
 STA. 125+66.7 TO 125+66.3 - 65'
 STA. 125+66.3 TO 125+69.6 - 6'
 STA. 125+72.2 TO 125+66.5 - 7'
 STA. 125+66.3 TO 125+75.4 - 8'
 STA. 127+92.7 TO 127+96.7 - 65'
 STA. 127+96.7 TO 127+84.1 - 13'

STORM SEWER REMOVAL - 15"
 STA. 126+43.1 TO 128+57.0 - 216'

STORM SEWER REMOVAL - 36"
 STA. 126+11.5 TO 126+34.7 - 23'
 STA. 126+40.3 TO 126+49.9 - 10'


STORM SEWER REMOVAL - 21"
 STA. 126+37.8 TO 129+56.9 - 318'

STORM SEWER REMOVAL - 24"
 STA. 122+81.4 TO 126+32.3 - 351'

PIPE CULVERT REMOVAL
 STA. 126+19.3 TO 126+31.9 - 129'
 STA. 126+24.7 TO 126+37.4 - 129'
 STA. 127+15.5 TO 127+53.1 - 37'

RIM 704.19
 INV 700.29 (NW)
 INV 700.19 (SE)
 RESTRICTOR PLATE

NOTE:
 1. SEE DRAWING DN-01 FOR DRAINAGE LEGEND AND NOTES.
 2. SEE DRAWINGS DS-01 THROUGH DS-11 FOR STRUCTURE AND PIPE INFORMATION

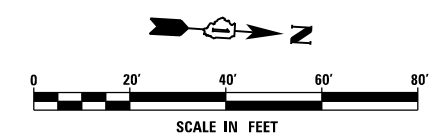

URS
 100 S. WACKER DR.
 10TH FLOOR
 CHICAGO, IL 60606
 TEL (312) 939-1000
 FAX (312) 939-4998

FILE NAME = D160F05-KEA-SHT-DRAINEX18.dgn	USER NAME = Frank.Stallone	DESIGNED - MGS	REVISED -	STATE OF ILLINOIS DEPARTMENT OF TRANSPORTATION	EXISTING DRAINAGE PLAN - US 45 (LAGRANGE ROAD)			F.A.P. RFE. 330	SECTION 103R-3	COUNTY COOK	TOTAL SHEETS 932	SHEET NO. 274
PLOT SCALE = 40.0001' / in.	CHECKED - JRS	DATE - 03/13/13	REVISED -		SCALE: 1"=20'	SHEET 18 OF 35 SHEETS	STA. 123+50.00 TO STA. 129+50.00	DU-18 CONTRACT NO. 60F05				
PLOT DATE = 3/14/2013	DATE - 03/13/13	REVISED -			ILLINOIS FED. AID PROJECT							
SHT. PLAN												