


REMOVING INLETS
 143+93.1, 40.9 LT
 143+93.7, 33.3 RT
 145+52.8, 33.2 LT
 145+54.2, 33.5 RT

REMOVING MANHOLES
 144+09.0, 40.8 RT

STORM SEWER REMOVAL - 12"
 STA. 143+93.1 TO 143+93.7 - 72'
 STA. 143+93.7 TO 144+09.0 - 14'
 STA. 145+52.8 TO 145+54.2 - 65'
 STA. 145+54.2 TO 145+54.3 - 7'

STORM SEWER REMOVAL - 15"
 STA. 144+09.0 TO 147+63.5 - 350'

 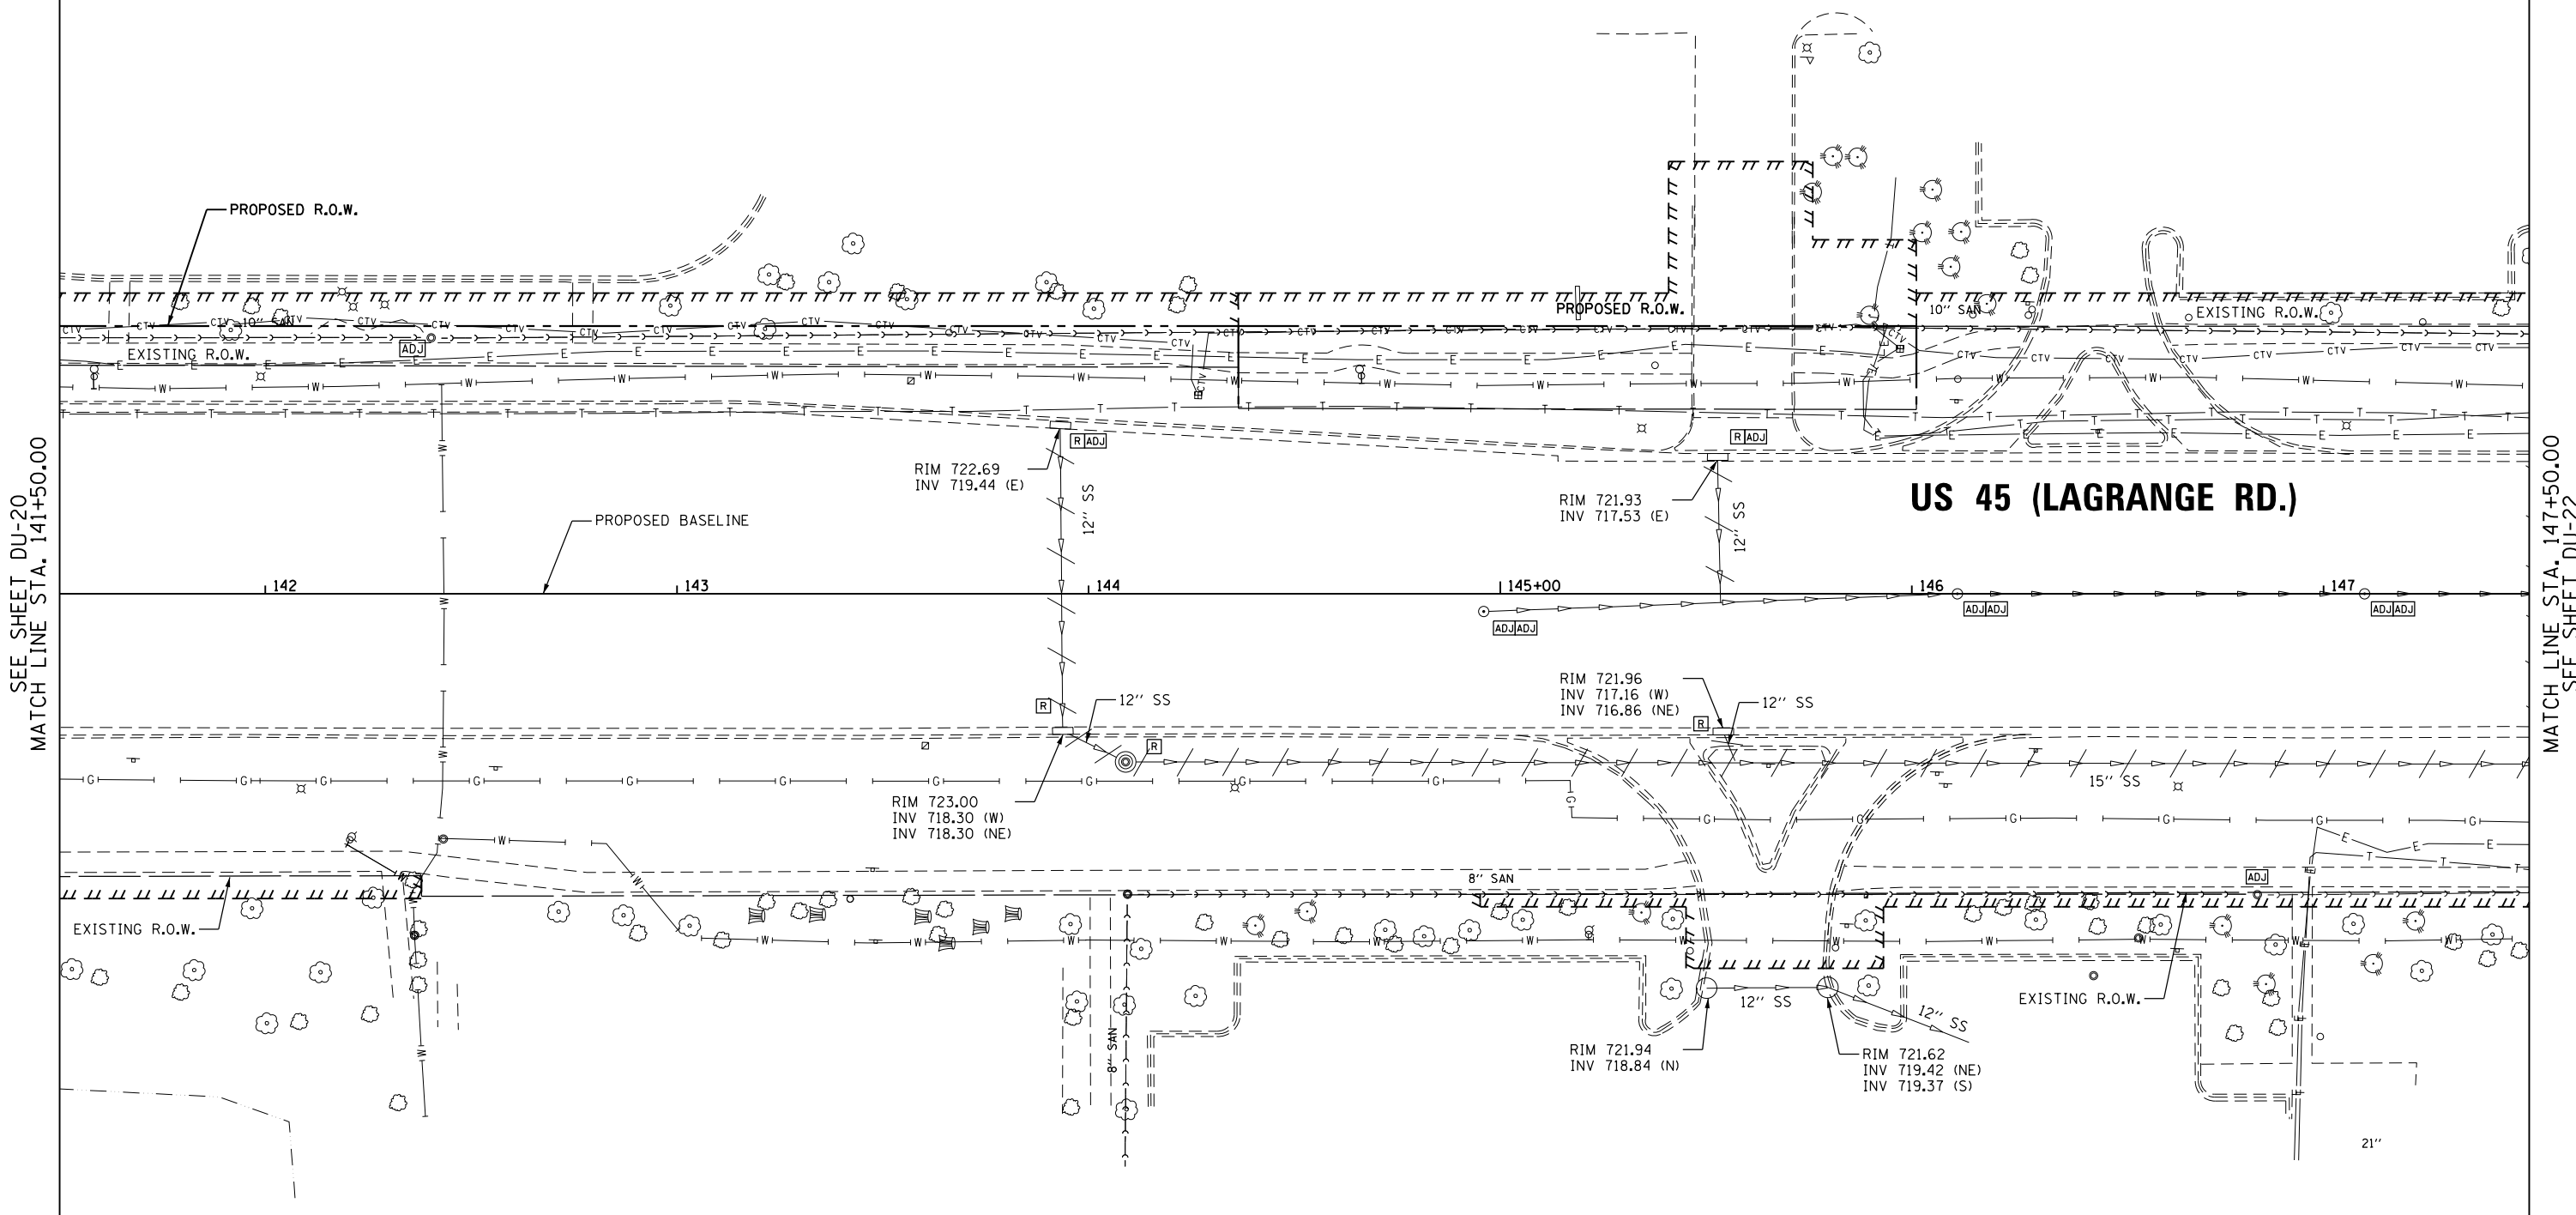


SEE SHEET DU-20
 MATCH LINE STA. 141+50.00

MATCH LINE STA. 147+50.00
 SEE SHEET DU-22

US 45 (LAGRANGE RD.)

NOTE:
 1. SEE DRAWING DN-01 FOR DRAINAGE LEGEND AND NOTES.
 2. SEE DRAWINGS DS-01 THROUGH DS-11 FOR STRUCTURE AND PIPE INFORMATION



URS
 100 S. WACKER DR.
 CHICAGO, IL 60606
 TEL (312) 939-1000
 FAX (312) 939-4998

FILE NAME = D160F05-KEA-SHT-DRAINEX21.dgn	USER NAME = Frank.Stallone	DESIGNED - MGS	REVISED -
SHT.PLAN	PLOT SCALE = 40.0001' / in.	DRAWN - REW	REVISED -
	PLOT DATE = 3/14/2013	CHECKED - JRS	REVISED -
		DATE - 03/13/13	REVISED -

**STATE OF ILLINOIS
 DEPARTMENT OF TRANSPORTATION**

EXISTING DRAINAGE PLAN - US 45 (LAGRANGE ROAD)

SCALE: 1"=20' SHEET 21 OF 35 SHEETS STA. 141+50.00 TO STA. 147+50.00

F.A.P. RTE. 330	SECTION 103R-3	COUNTY COOK	TOTAL SHEETS 932	SHEET NO. 277
DU-21		CONTRACT NO. 60F05		
ILLINOIS FED. AID PROJECT				