

FILE NAME =	USER NAME = Frank.Stallone
D:\160F05-KEA-SHT-DRAINEX29.dgn	
SHT.PLAN	

DESIGNED - MGS	REVISD -
DRAWN - REW	REVISD -
CHECKED - JRS	REVISD -
DATE - 03/13/13	REVISD -


DESIGNED - MGS	REVISD -
DRAWN - REW	REVISD -
CHECKED - JRS	REVISD -
DATE - 03/13/13	REVISD -

**STATE OF ILLINOIS
 DEPARTMENT OF TRANSPORTATION**

EXISTING DRAINAGE PLAN - 175TH STREET

SCALE: 1"=20' SHEET 29 OF 35 SHEETS STA. TO STA.

F.A.P. RTE.	SECTION	COUNTY	TOTAL SHEETS	SHEET NO.
330	103R-3	COOK	932	285
DU-29		CONTRACT NO. 60F05		
ILLINOIS FED. AID PROJECT				

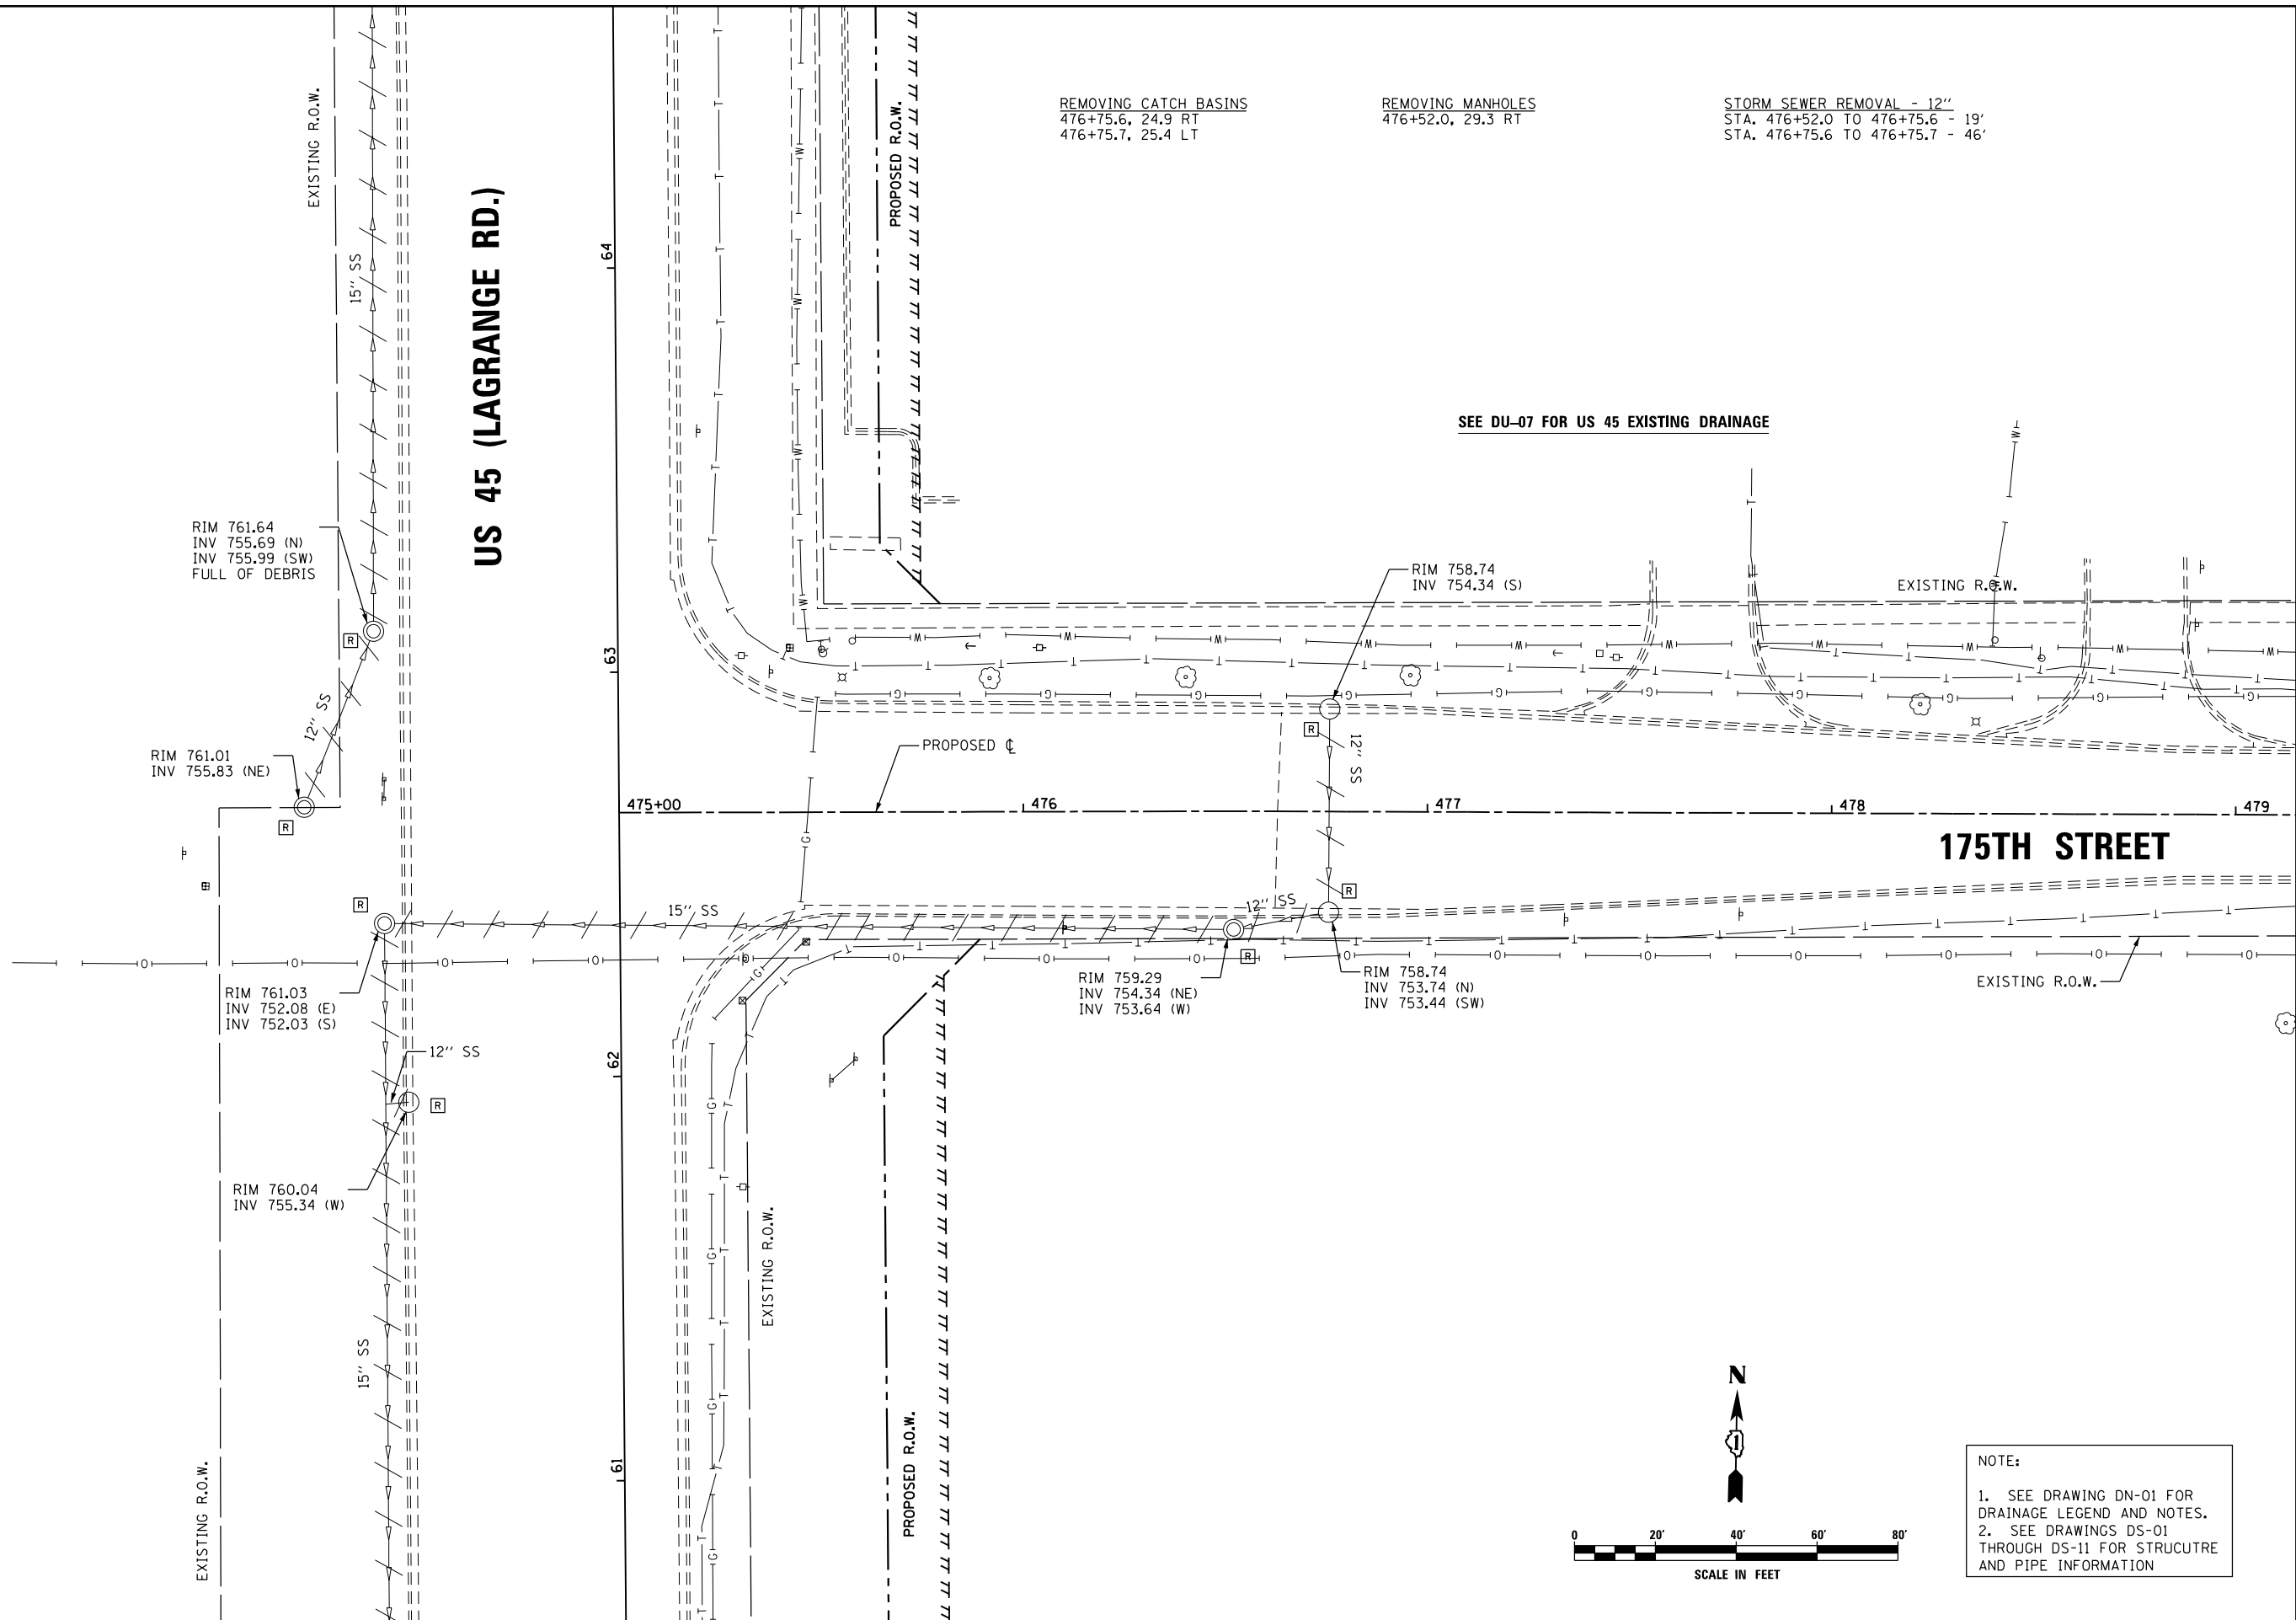

NOTE:

- SEE DRAWING DN-01 FOR DRAINAGE LEGEND AND NOTES.
- SEE DRAWINGS DS-01 THROUGH DS-11 FOR STRUCTURE AND PIPE INFORMATION