



SEE SHEET DU-48  
 MATCH LINE STA. 99+50.00

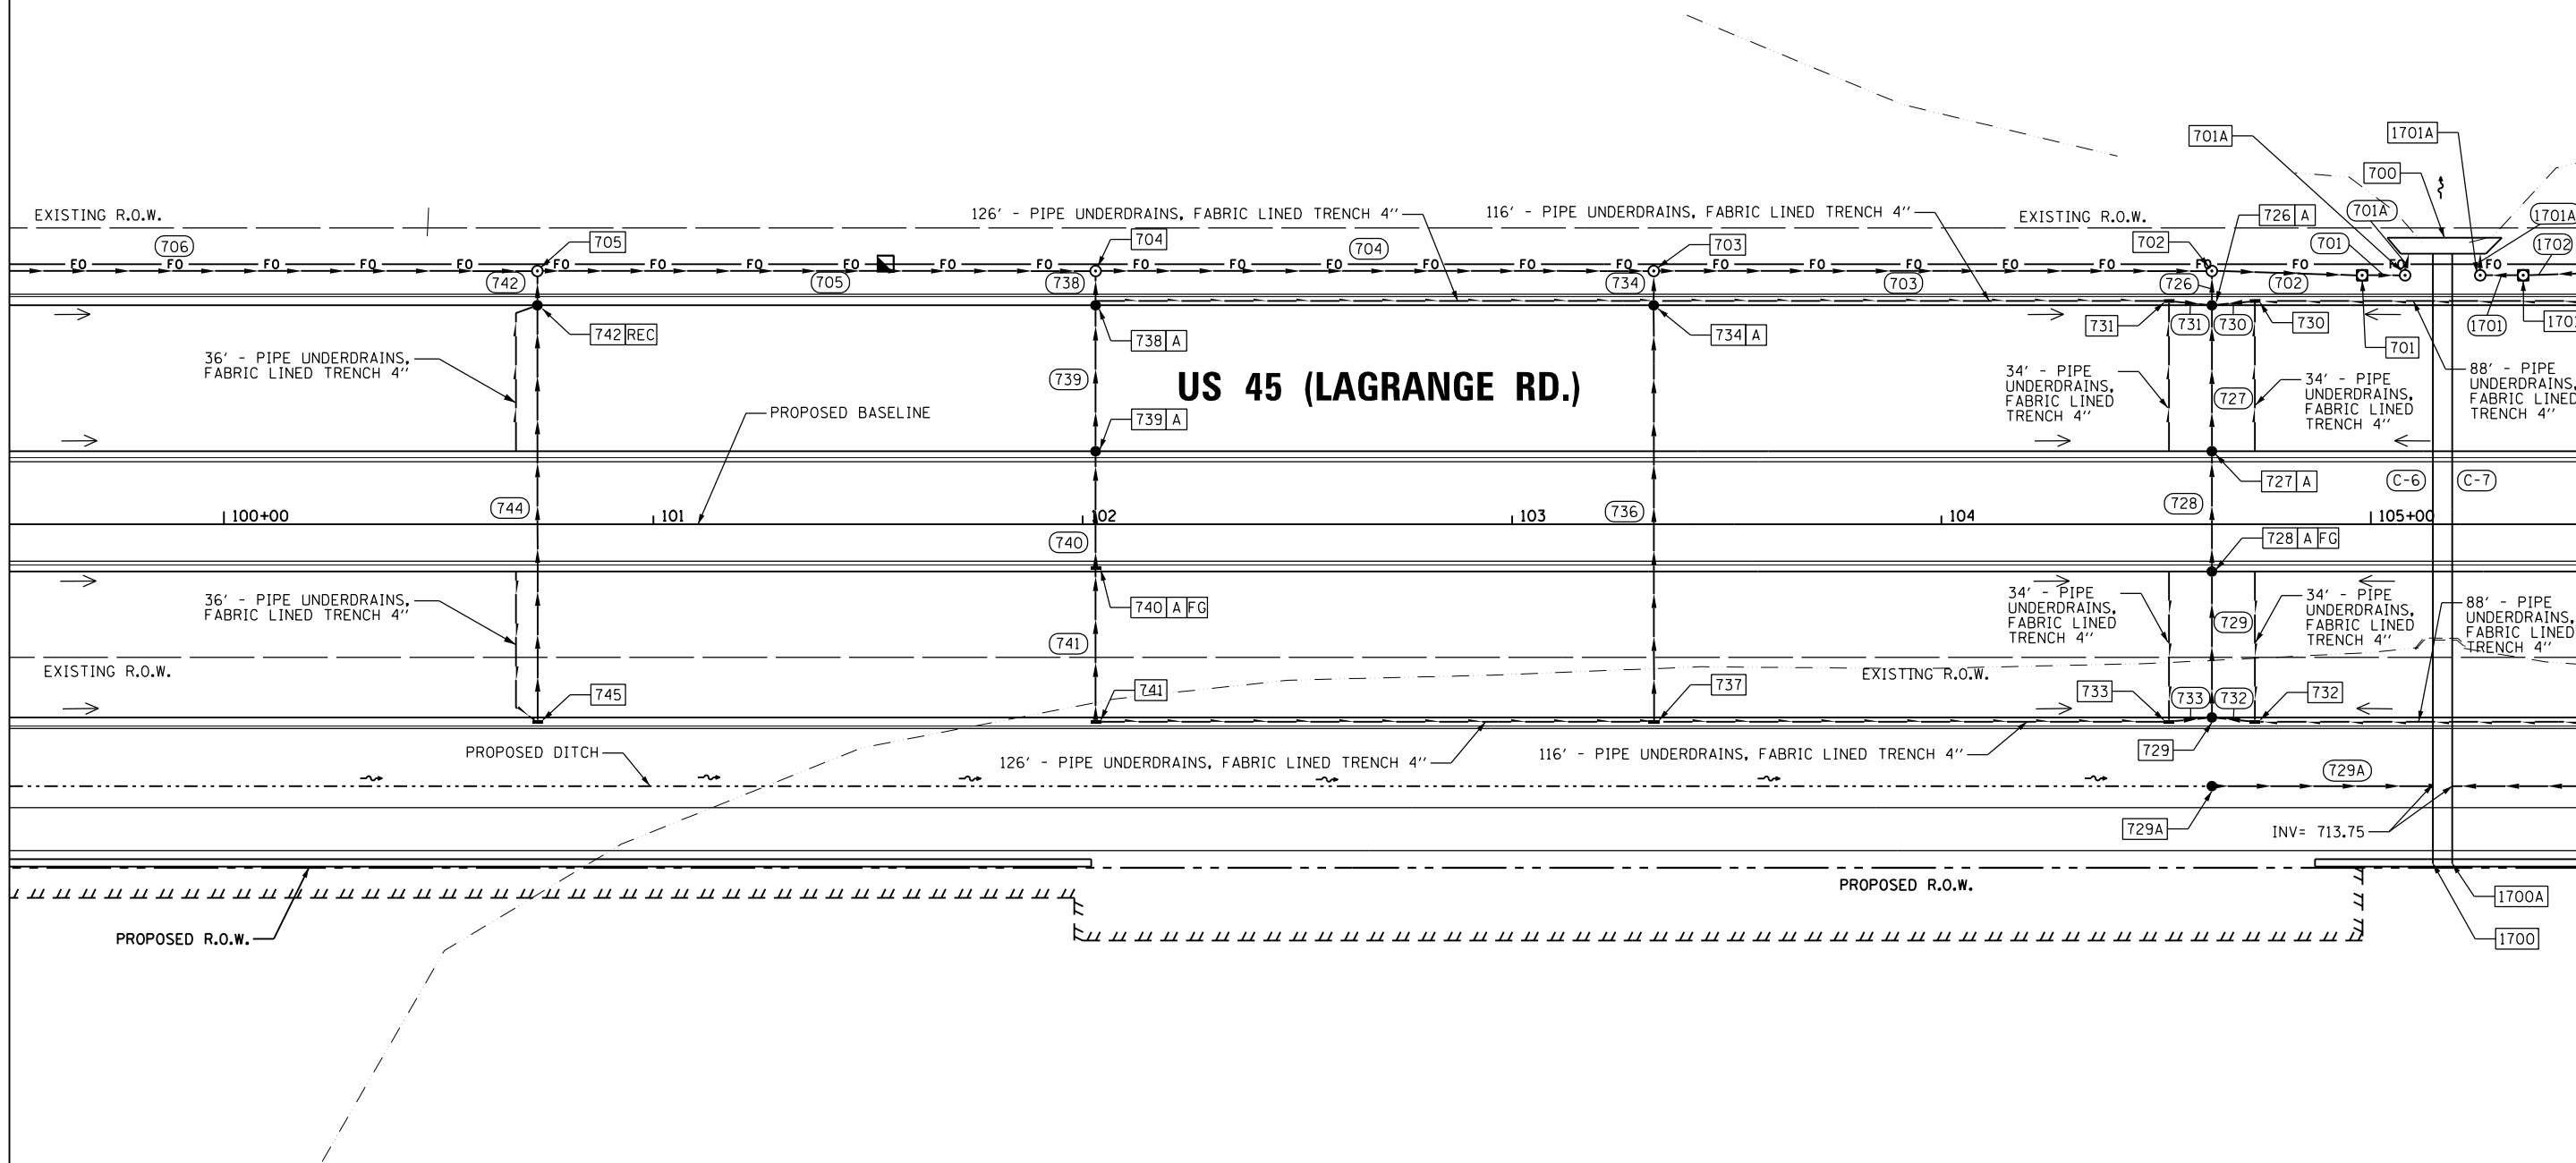

MATCH LINE STA. 105+50.00  
 SEE SHEET DU-50

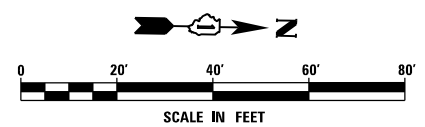

NOTE:  
 1. SEE DRAWING DN-01 FOR DRAINAGE LEGEND AND NOTES.  
 2. SEE DRAWINGS DS-01 THROUGH DS-11 FOR STRUCTURE AND PIPE INFORMATION

FILE NAME = D160F05-KEA-SHT-DRAINPR14.dgn	USER NAME = Anthony.Plutz	DESIGNED - MGS	REVISED -
		DRAWN - REW	REVISED -
		CHECKED - JRS	REVISED -
SHT.PLAN	PLOT DATE = 3/13/2013	DATE - 03/13/13	REVISED -

**STATE OF ILLINOIS  
 DEPARTMENT OF TRANSPORTATION**

**PROPOSED DRAINAGE PLAN - US 55 (LAGRANGE ROAD)**  
 SCALE: 1"=20' SHEET 14 OF 35 SHEETS STA. 99+50.00 TO STA. 105+50.00

F.A.P. RTE. 330	SECTION 103R-3	COUNTY COOK	TOTAL SHEETS 932	SHEET NO. 305
<b>DU-49</b>			CONTRACT NO. 60F05	
ILLINOIS FED. AID PROJECT				