
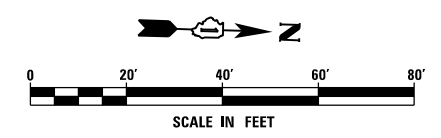


NOTE:
 1. SEE DRAWING DN-01 FOR DRAINAGE LEGEND AND NOTES.
 2. SEE DRAWINGS DS-01 THROUGH DS-11 FOR STRUCTURE AND PIPE INFORMATION

SEE DU-66 TO DU-68 FOR 167TH ST. PROPOSED DRAINAGE

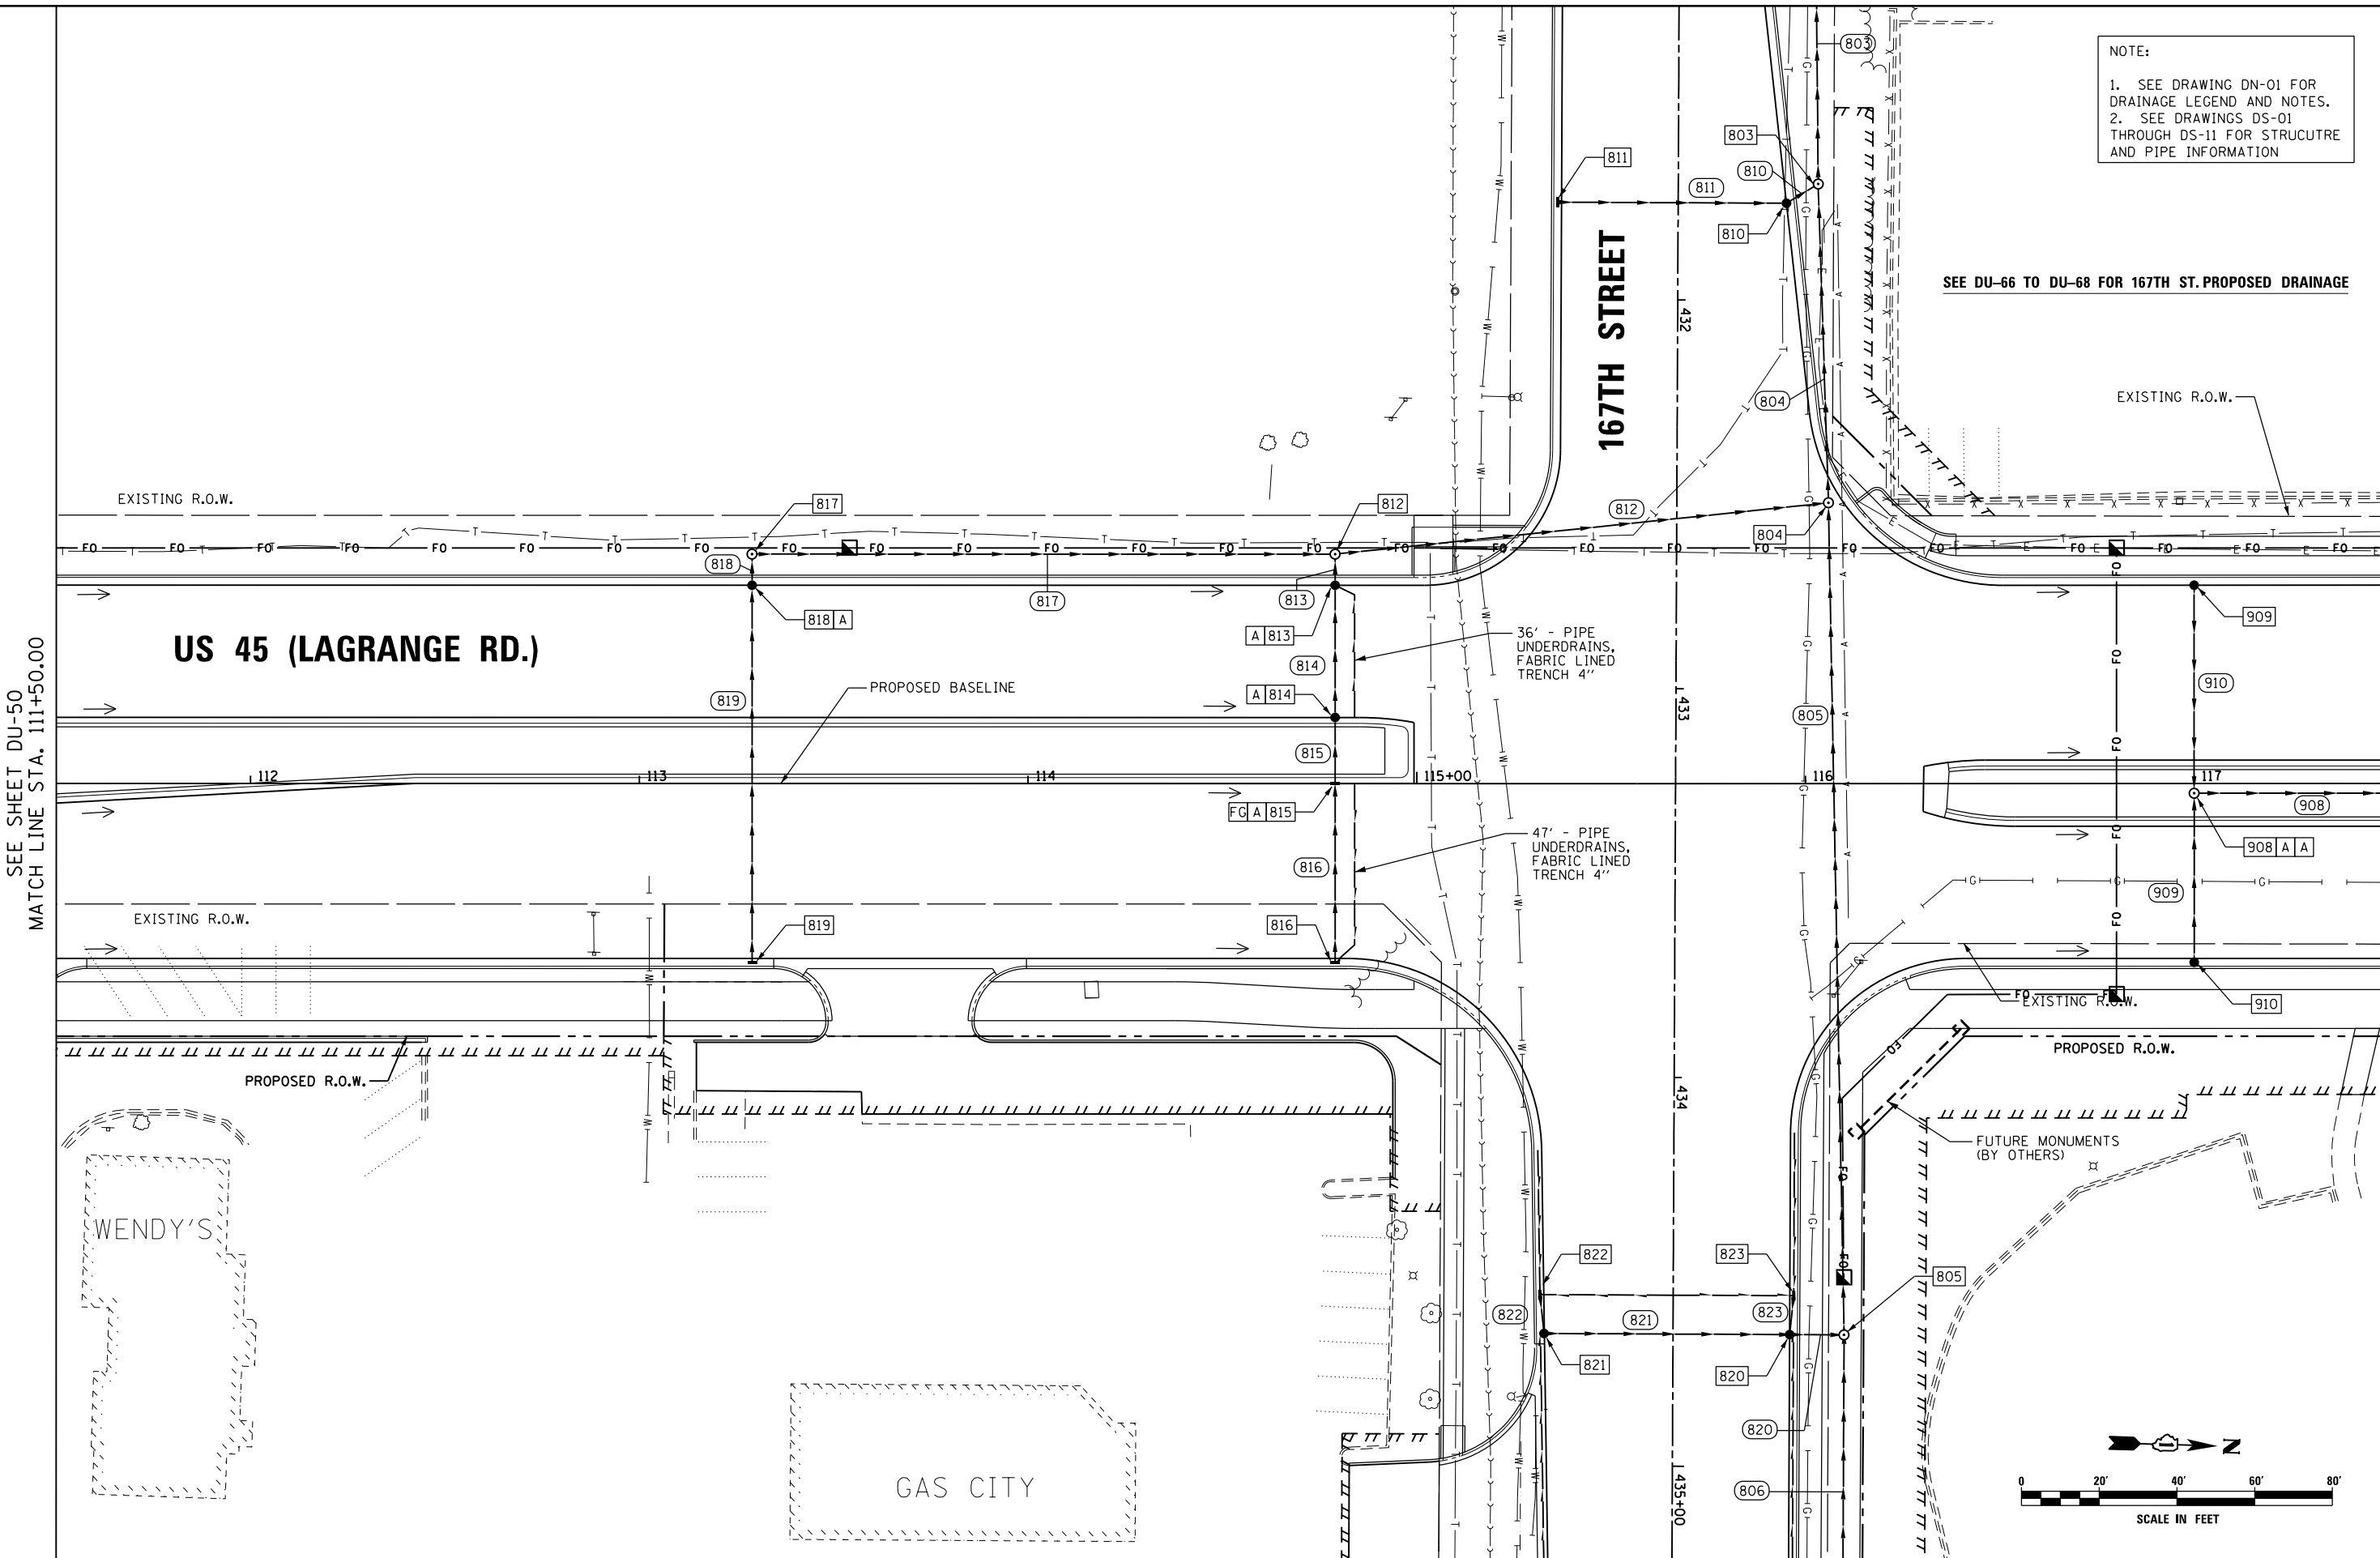

SEE SHEET DU-50
 MATCH LINE STA. 111+50.00

MATCH LINE STA. 117+50.00
 SEE SHEET DU-52

URS
 100 S. WACKER DR.
 SUITE 600
 CHICAGO, IL 60606
 TEL (312) 935-1000
 FAX (312) 935-4998

FILE NAME = D160F05-KEA-SHT-DRAINPR16.dgn	USER NAME = Anthony.Plutz	DESIGNED - MGS	REVISED -
		DRAWN - REW	REVISED -
		CHECKED - JRS	REVISED -
SHT.PLAN	PLOT DATE = 3/13/2013	DATE - 03/13/13	REVISED -

**STATE OF ILLINOIS
 DEPARTMENT OF TRANSPORTATION**

PROPOSED DRAINAGE PLAN - US 45 (LAGRANGE ROAD)

SCALE: 1"=20' SHEET 16 OF 35 SHEETS STA. 111+50.00 TO STA. 117+50.00

F.A.P. RTE. 330	SECTION 103R-3	COUNTY COOK	TOTAL SHEETS 932	SHEET NO. 307
DU-51		CONTRACT NO. 60F05		
ILLINOIS FED. AID PROJECT				