 



SEE SHEET DU-67  
 MATCH LINE STA. 436+00.00

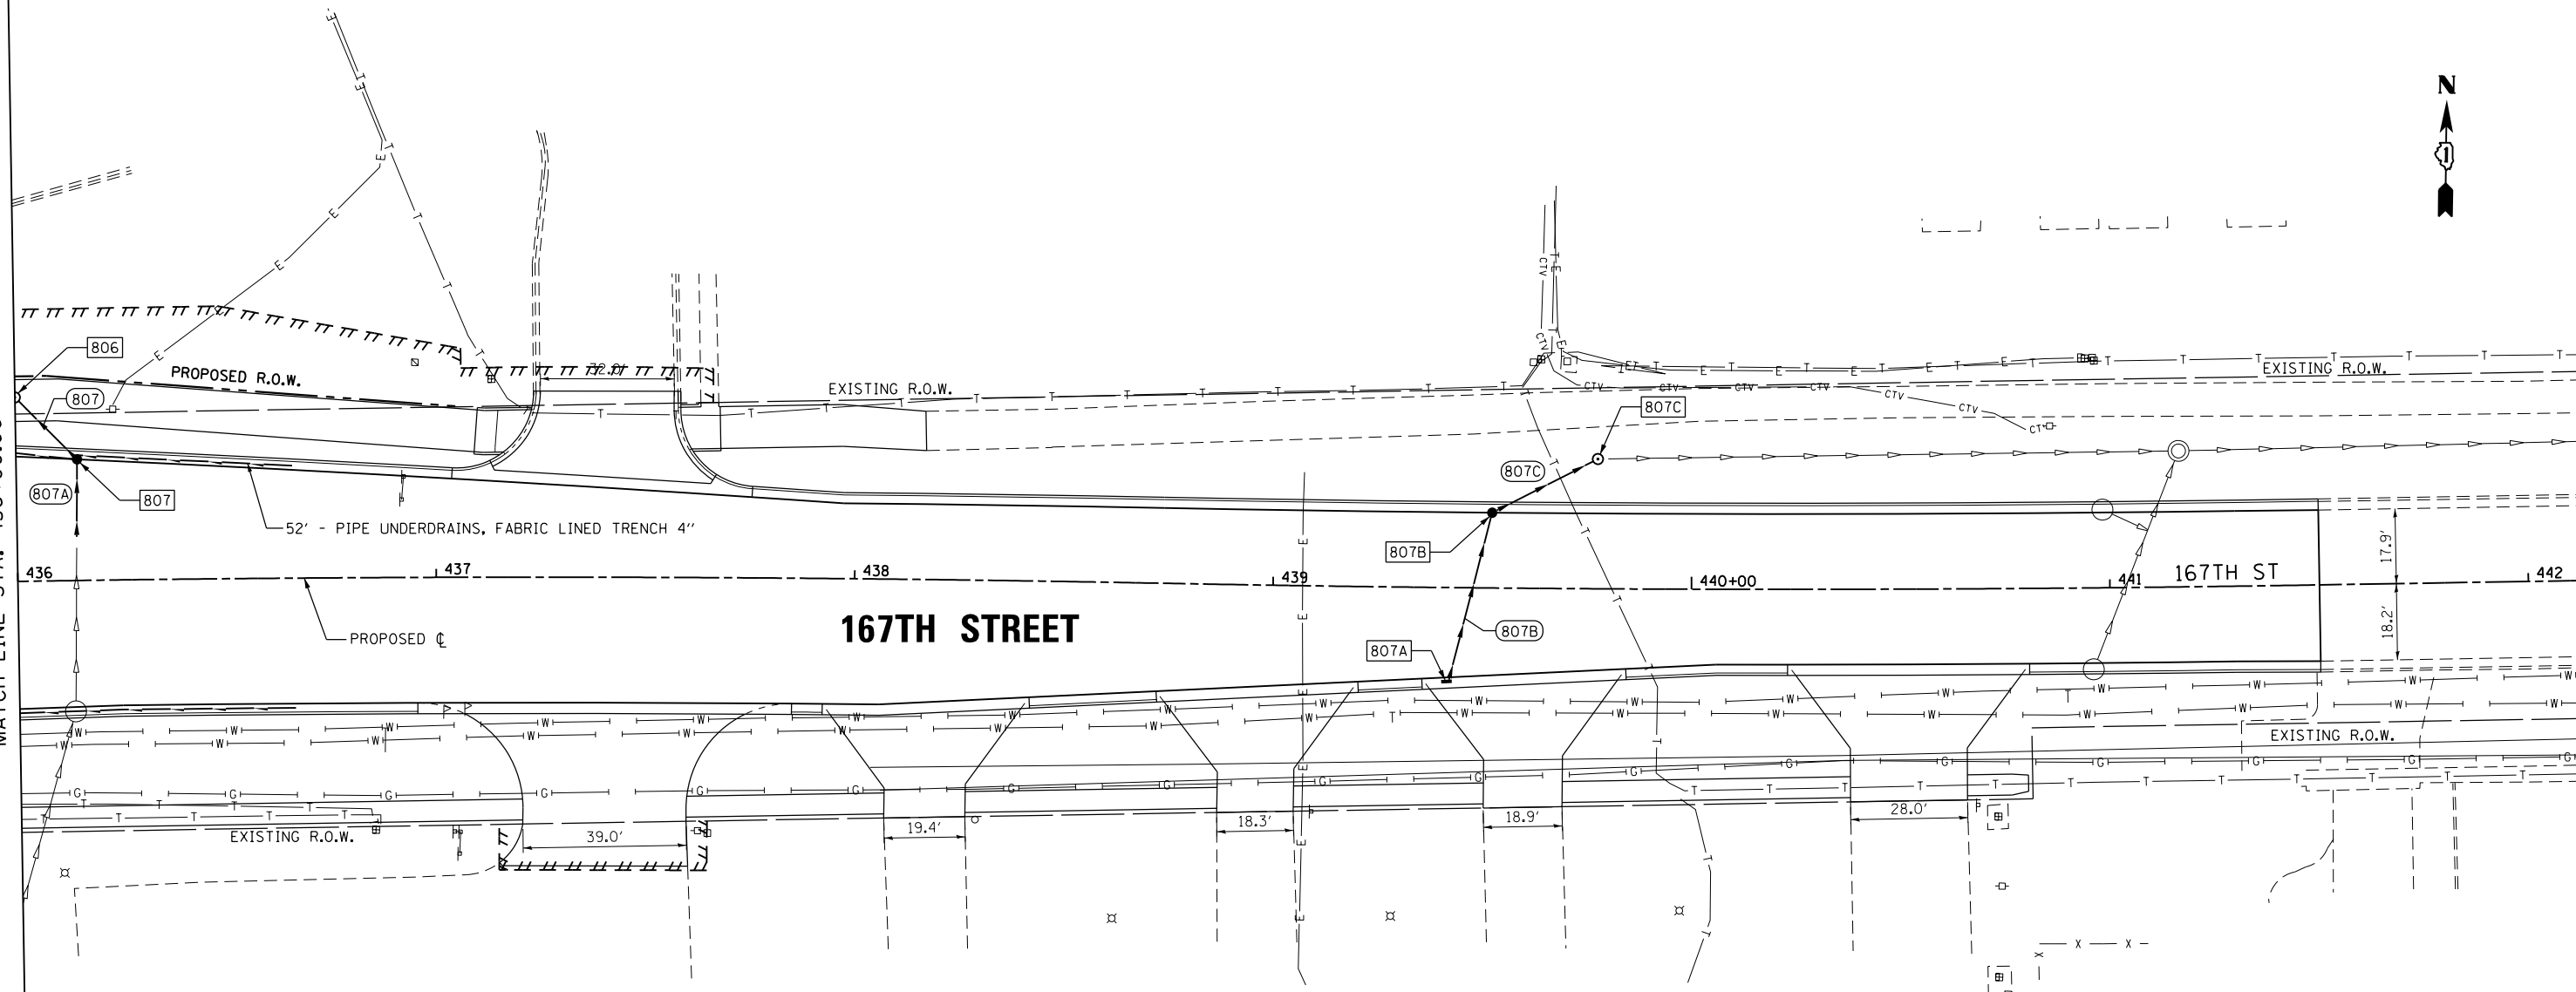

**NOTE:**  
 1. SEE DRAWING DN-01 FOR DRAINAGE LEGEND AND NOTES.  
 2. SEE DRAWINGS DS-01 THROUGH DS-11 FOR STRUCTURE AND PIPE INFORMATION

FILE NAME = D:\160F05-KEA-SHT-DRAINPR33.dgn  
 SHT.PLAN

USER NAME = Anthony.Plutz  
 PLOT SCALE = 48.0001' / in.  
 PLOT DATE = 3/13/2013

DESIGNED - MGS  
 DRAWN - REW  
 CHECKED - JRS  
 DATE - 03/13/13

REVISED -  
 REVISED -  
 REVISED -  
 REVISED -

**STATE OF ILLINOIS  
 DEPARTMENT OF TRANSPORTATION**

**PROPOSED DRAINAGE PLAN - 167TH STREET**  
 SCALE: 1"=20' SHEET 33 OF 35 SHEETS STA. 436+00.00 TO STA. END

F.A.P. RTE.	SECTION	COUNTY	TOTAL SHEETS	SHEET NO.
330	103R-3	COOK	932	324
<b>DU-68</b>			<b>CONTRACT NO. 60F05</b>	
ILLINOIS FED. AID PROJECT				