


PLAN	SURVEYED	DATE
	PLOTTED	
	GRADES CHECKED	
	STRUCTURE NOTATIONS OK'D	
	NOTE BOOK NO.	
	BY	

PROFILE	SURVEYED	DATE
	PLOTTED	
	GRADES CHECKED	
	STRUCTURE NOTATIONS OK'D	
	NOTE BOOK NO.	
	BY	


100 S. WACKER DR.
SUITE 500
CHICAGO, IL 60606
TEL (312) 939-4000
FAX (312) 939-4098

SEE DRAWING WT-03
MATCH LINE STA. 129+50.00

MATCH LINE STA. 135+50.00
SEE DRAWING WT-05

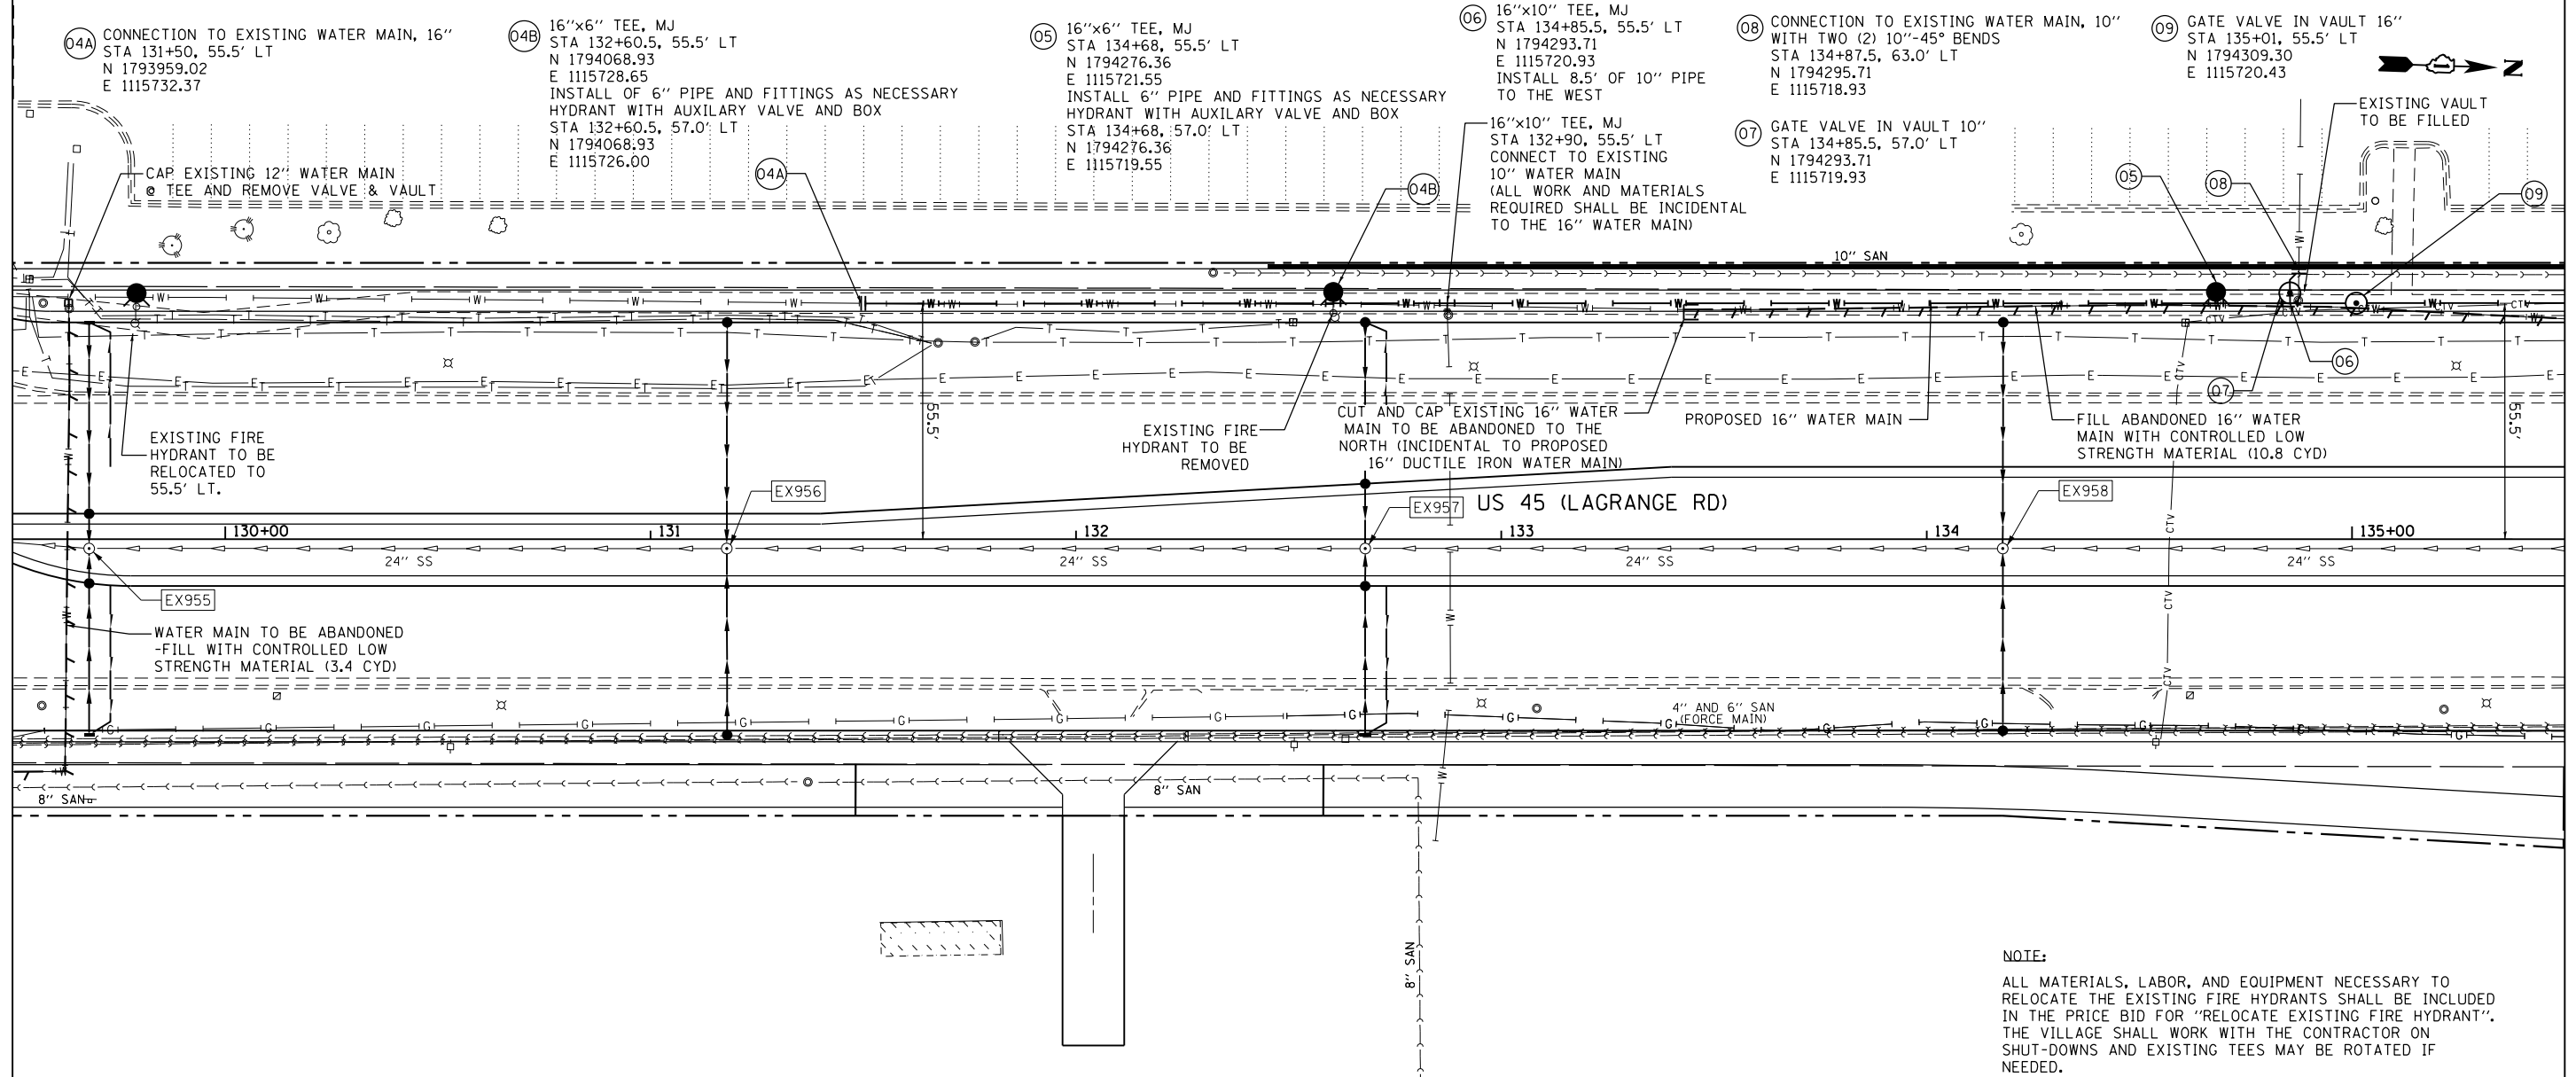

NOTE:
ALL MATERIALS, LABOR, AND EQUIPMENT NECESSARY TO RELOCATE THE EXISTING FIRE HYDRANTS SHALL BE INCLUDED IN THE PRICE BID FOR "RELOCATE EXISTING FIRE HYDRANT". THE VILLAGE SHALL WORK WITH THE CONTRACTOR ON SHUT-DOWNS AND EXISTING TEES MAY BE ROTATED IF NEEDED.

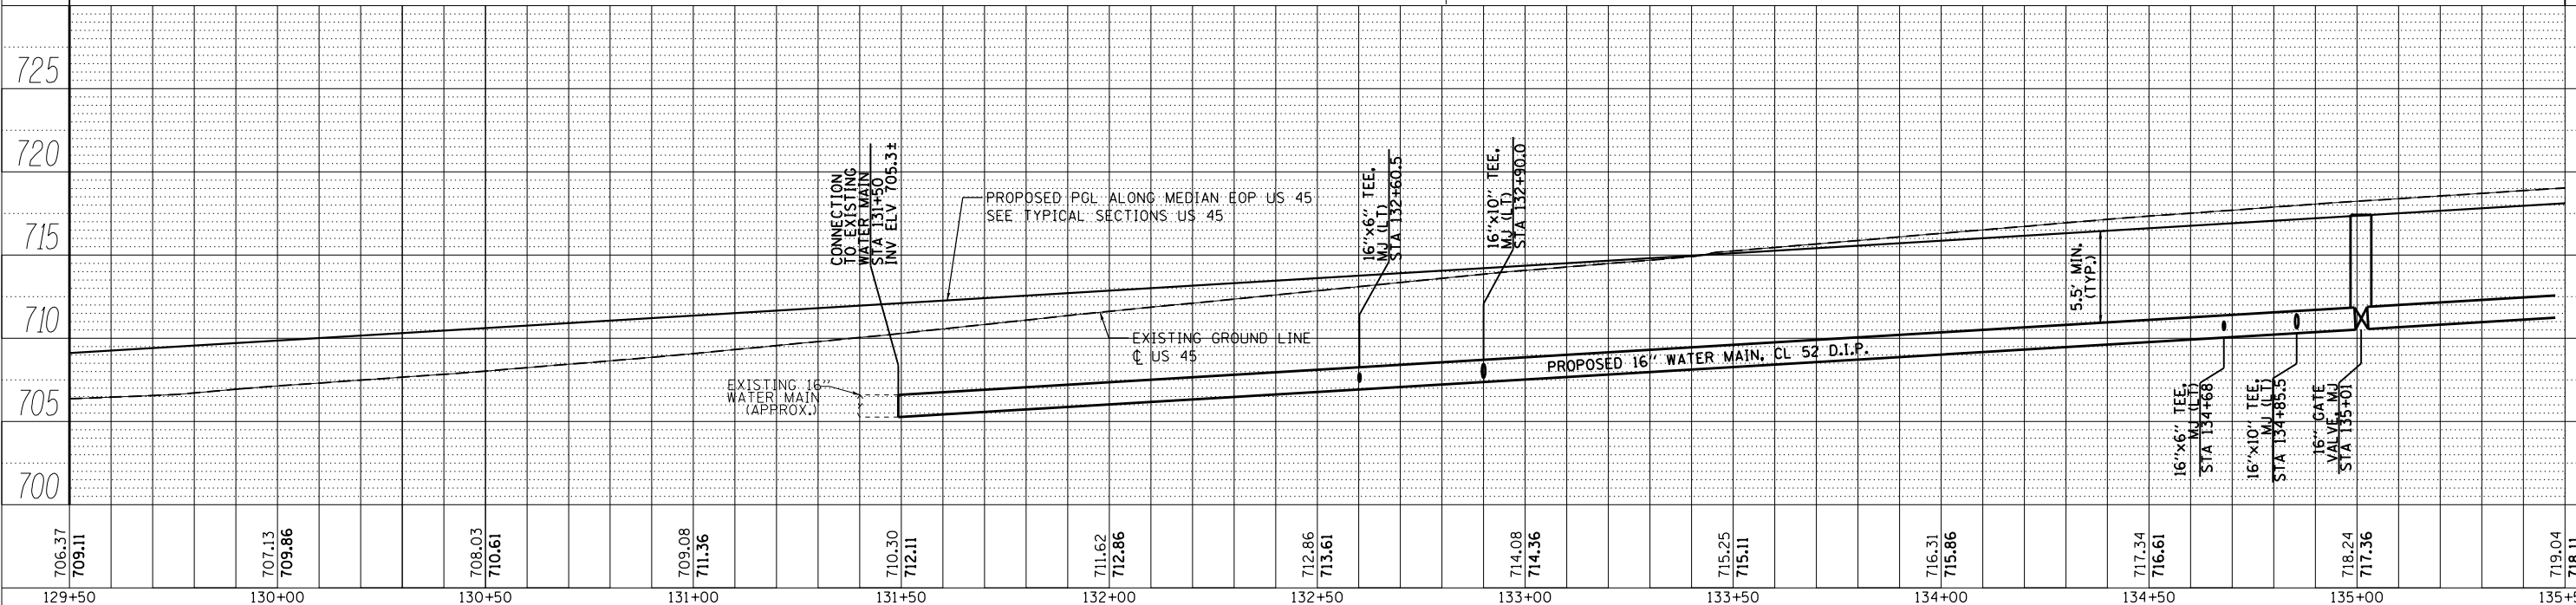

706.37 709.11	707.13 709.86	708.03 710.61	709.08 711.36	710.30 712.11	711.62 712.86	712.86 713.61	714.08 714.36	715.25 715.11	716.31 715.86	717.34 716.61	718.24 717.36	719.04 716.11
129+50	130+00	130+50	131+00	131+50	132+00	132+50	133+00	133+50	134+00	134+50	135+00	135+50

STATE OF ILLINOIS
DEPARTMENT OF TRANSPORTATION

WATER MAIN - PROPOSED PLAN AND PROFILE
US 45 (LAGRANGE ROAD)

F.A.P. RTE.	SECTION	COUNTY	TOTAL SHEETS	SHEET NO.
330	103R-3	COOK	932	359
WT-04		CONTRACT NO. 60F05		

SCALE: 1"=40'H; 1"=5' SHEET 4 OF 10 SHEETS STA. 129+50.00 TO STA. 135+50.00

ILLINOIS FED. AID PROJECT