



PLAN	SURVEYED	DATE
	PLOTTED	BY
	ALIGNED	
	CHECKED	
	FILED	
	NO.	

PROFILE	SURVEYED	DATE
	PLOTTED	BY
	GRADES	
	CHECKED	
	STRUCTURE	
	NOTATIONS	
	CPAD	
	NO.	

100 S. WACKER DR.
SUITE 500
CHICAGO, IL 60606
TEL (312) 539-4000
FAX (312) 539-4098

URS

SEE DRAWING WT-05
MATCH LINE STA. 141+50.00

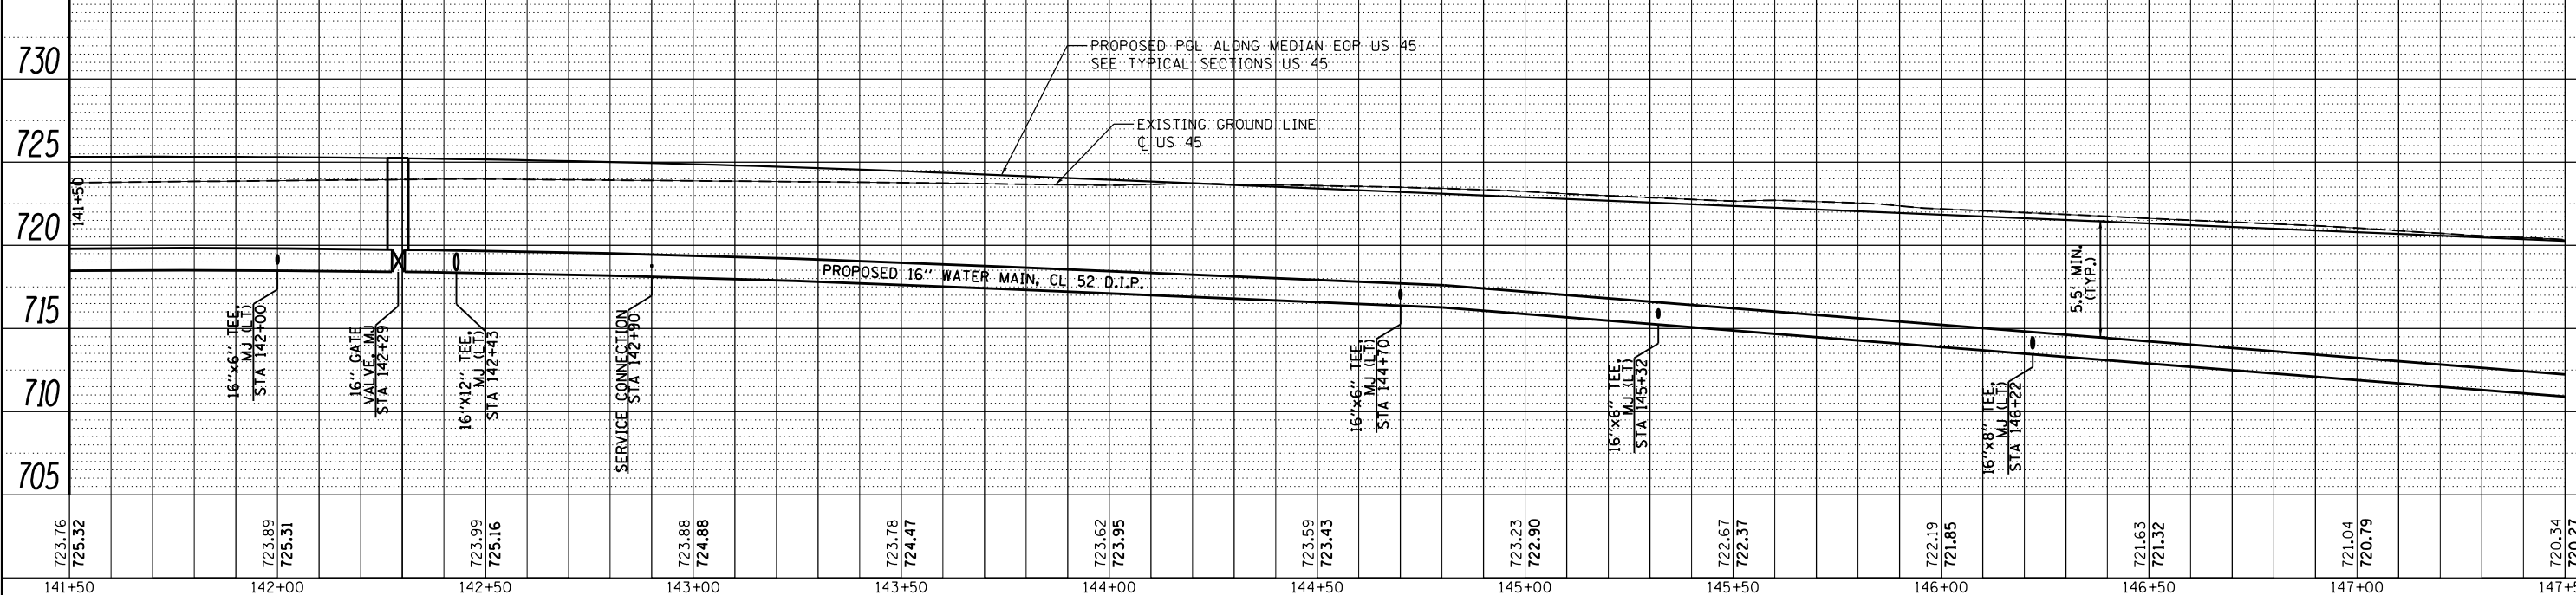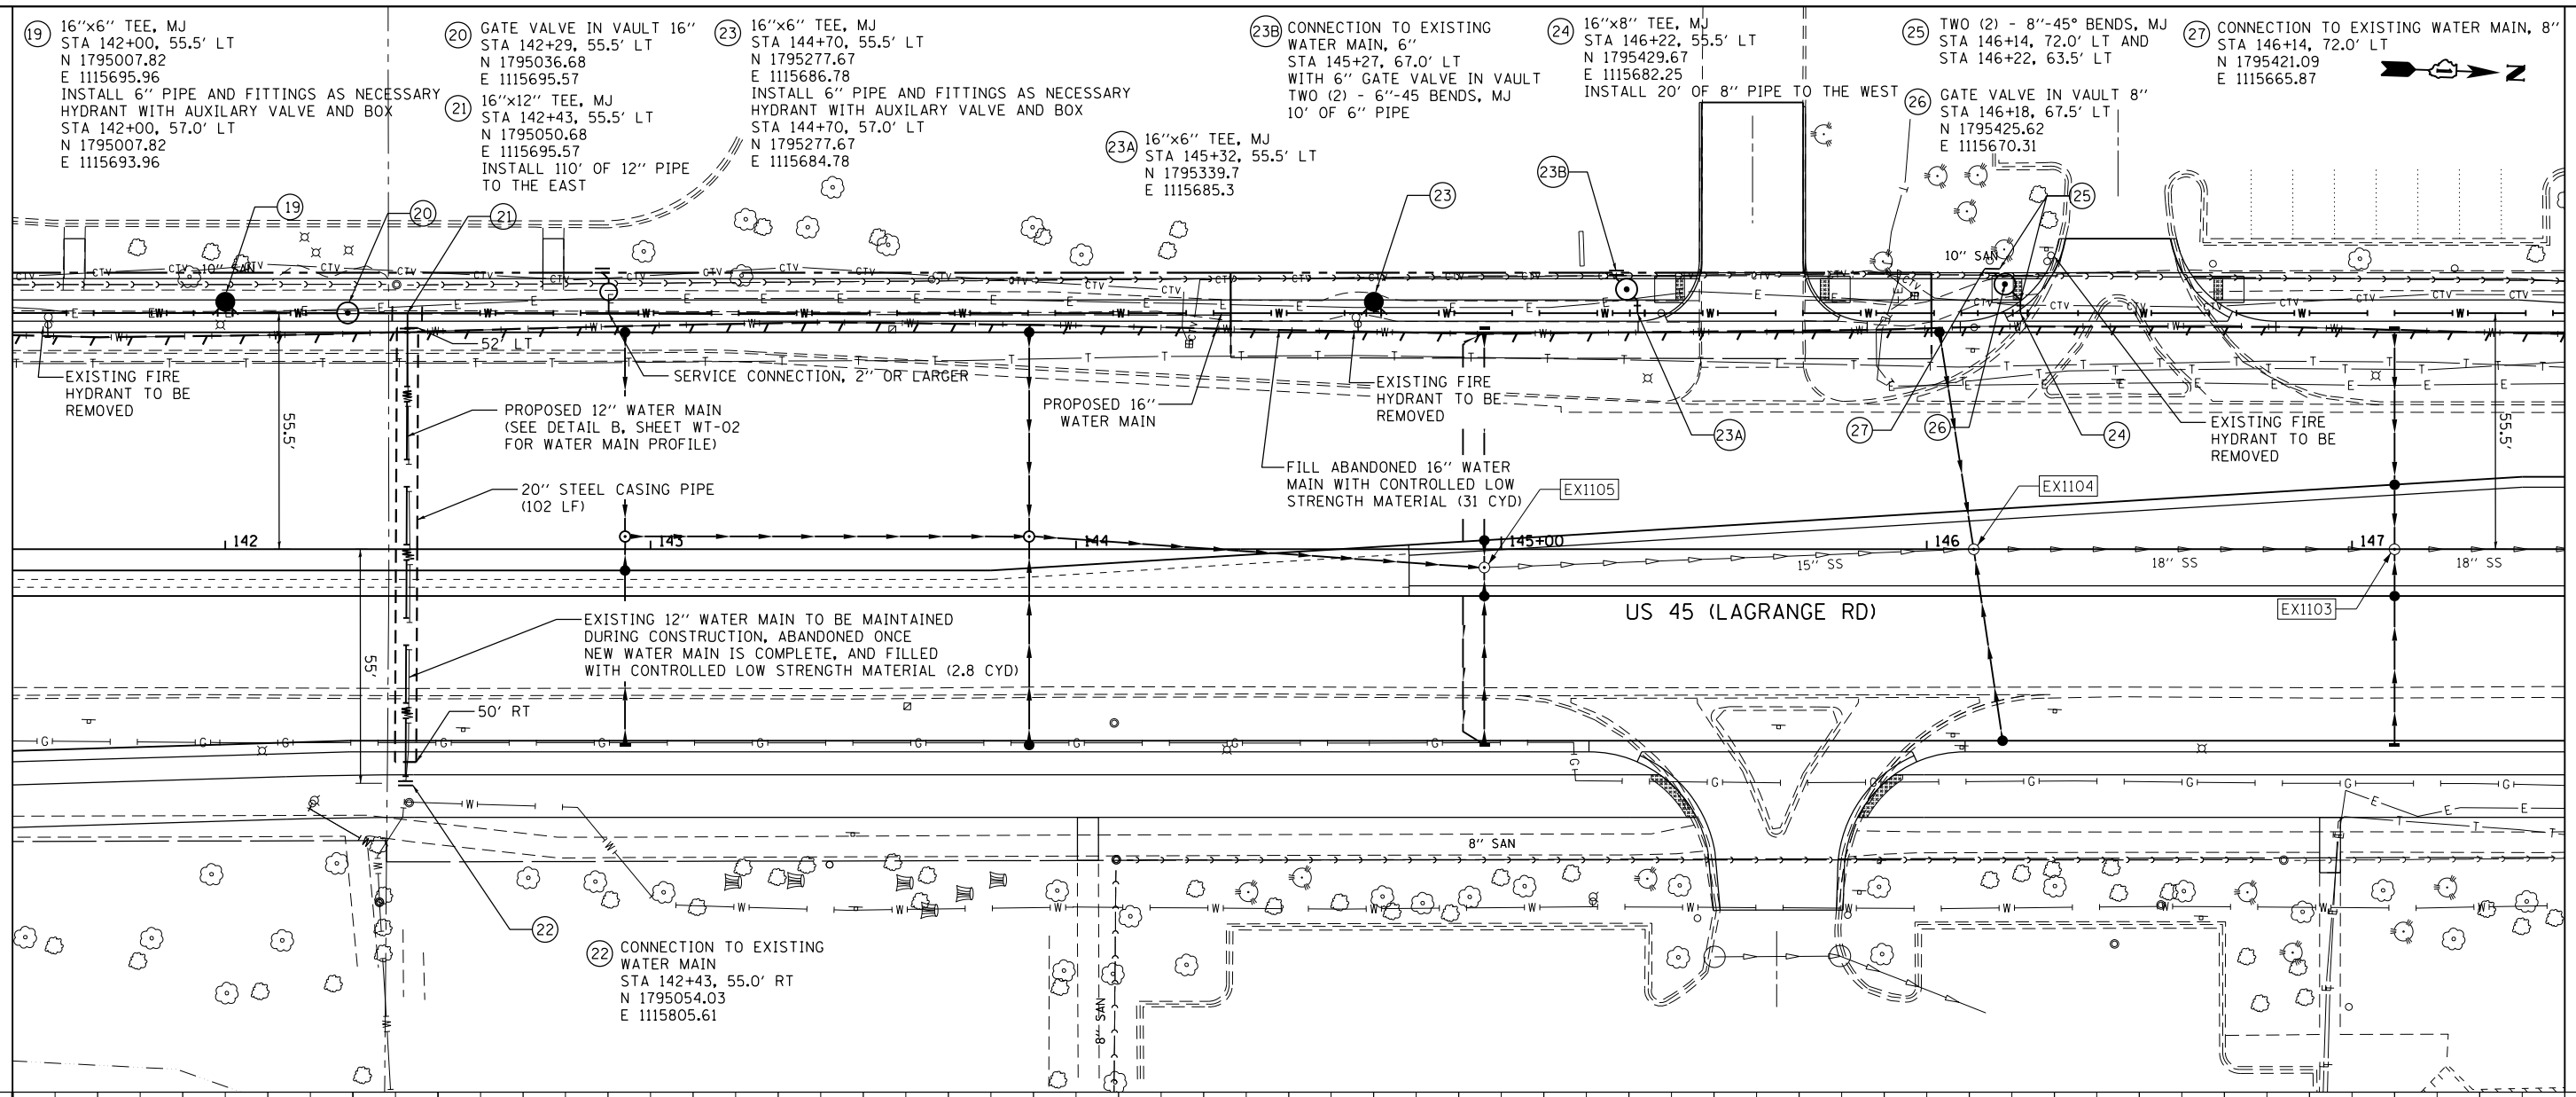

MATCH LINE STA. 147+50.00
SEE DRAWING WT-07

FILE NAME =	USER NAME = Anthony.Plutz	DESIGNED - JTF	REVISED -	STATE OF ILLINOIS DEPARTMENT OF TRANSPORTATION	WATER MAIN - PROPOSED PLAN AND PROFILE US 45 (LAGRANGE ROAD)	F.A.P. RTE.	SECTION	COUNTY	TOTAL SHEETS	SHEET NO.
D160F05-SHT-WATER06.dgn		DRAWN - JTF	REVISED -			330	103R-3	COOK	932	361
PLOT SCALE = 40.0000' / in.		CHECKED - MJT	REVISED -			WT-06		CONTRACT NO. 60F05		
PLOT DATE = 3/9/2013		DATE - 03/13/13	REVISED -			SCALE: 1"=40'H; 1"=5' V		SHEET 6 OF 10 SHEETS		STA. 141+50.00 TO STA. 147+50.00

ILLINOIS FED. AID PROJECT