
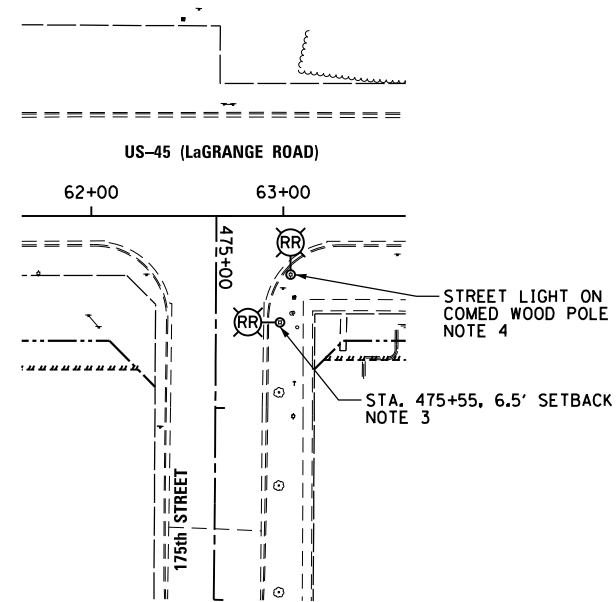
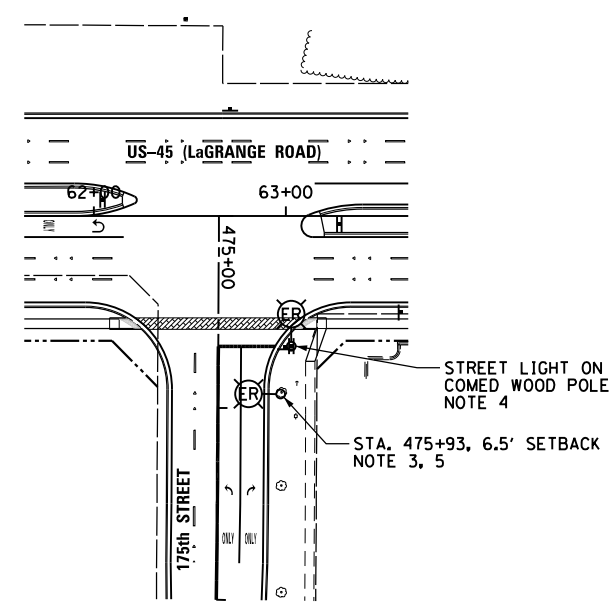


NOTES:

1. SEE DRAWING E-1 FOR ELECTRICAL SYMBOL LIST AND ABBREVIATIONS. SEE DRAWING E-2 FOR ELECTRICAL GENERAL NOTES.
2.  INDICATES TEMPORARY PAVEMENT INSTALLATION LIMITS. SEE MAINTENANCE OF TRAFFIC DRAWINGS FOR CONSTRUCTION STAGING INFORMATION.
3. CONTRACTOR MUST COORDINATE THE REMOVAL AND REINSTALLATION OF LIGHT POLE WITH THE PROPOSED RECONSTRUCTION OF 175th STREET AND WITH THE OWNER. SEE MAINTENANCE OF TRAFFIC DRAWINGS FOR CONSTRUCTION STAGING PLANS. CONTRACTOR TO DISCONNECT POWER SOURCE AT NEXT LIGHT POLE EAST OF POLE TO BE RELOCATED. THE CONTRACTOR MUST CONFIRM THE DIAMETER OF EXISTING BOLT CIRCLE FOR POLE TO BE RELOCATED PRIOR TO REMOVAL OF EXISTING POLE AND CONCRETE FOUNDATION. CONTRACTOR TO REINSTALL EXISTING POLE ON PROPOSED CONCRETE FOUNDATION, AND RECONNECT WIRING TO NEXT POLE EAST OF RELOCATED POLE. SEE DRAWING E-25 FOR PROPOSED LIGHTING UNIT FOUNDATION DETAILS. THIS WORK SHALL BE PAID FOR UNDER THE "REMOVE AND RELOCATE EXISTING LIGHT STANDARD", THE "REMOVAL OF POLE FOUNDATION", AND THE "LIGHT POLE FOUNDATION, 24" DIAMETER" PAY ITEMS. SEPARATE PAYMENT WILL NOT BE MADE.
4. EXACT LOCATION OF RELOCATED COMED POLE TO BE DETERMINED BY COMED. CONTRACTOR TO COORDINATE WITH COMED AS TO WHO IS RESPONSIBLE FOR REMOVING AND DISCONNECTING THE EXISTING STREET LIGHT, AND REINSTALLING AND RECONNECTING THE STREET LIGHT ON THE RELOCATED COMED POLE. THIS WORK SHALL BE PAID FOR UNDER THE "REMOVE AND RELOCATE EXISTING LIGHT STANDARD" PAY ITEM. SEPARATE PAYMENT WILL NOT BE MADE.
5. RELOCATE ENTIRE POLE WITH LUMINAIRE. DO NOT REPLACE LUMINAIRE.

 


175th STREET ELECTRICAL DEMOLITION PLAN
SCALE: 1" = 50'-0"



175th STREET PROPOSED ROADWAY LIGHTING PLAN
SCALE: 1" = 50'-0"

100 S. WACKER DR.
 SUITE 500
 CHICAGO, IL 60606
 TEL (312) 935-1000
 FAX (312) 935-4998
URS



FILE NAME =	USER NAME = Frank.Stallone	DESIGNED - MAE	REVISED -
D160F05-SHT-E06.dgn		DRAWN - WM	REVISED -
		CHECKED - DAD	REVISED -
SHT.PLAN	PLOT DATE = 3/14/2013	DATE - 03/13/13	REVISED -

**STATE OF ILLINOIS
DEPARTMENT OF TRANSPORTATION**

PROPOSED ROADWAY LIGHTING PLANS - 175th STREET

SCALE: 1"=50' SHEET 1 OF 1 SHEETS STA. 475+00.00 TO STA. 477+00.00

F.A.P. RTE.	SECTION	COUNTY	TOTAL SHEETS	SHEET NO.
330	103R-3	COOK	932	532
E-6			CONTRACT NO. 60F05	
ILLINOIS FED. AID PROJECT				