



**NOTES:**

1. SEE DRAWING E-1 FOR ELECTRICAL SYMBOL LIST AND ABBREVIATIONS. SEE DRAWING E-2 FOR ELECTRICAL GENERAL NOTES.
2. SEE IDOT STANDARD DRAWING E-26 FOR PROPOSED LIGHTING UNIT DETAILS. SEE IDOT STANDARD DRAWING E-25 FOR PROPOSED LIGHTING UNIT FOUNDATION DETAILS.
3. CONTRACTOR TO FURNISH AND INSTALL (3) 3/2" x 36" RADIUS PVC CONDUIT RACEWAY ELBOWS IN FOUNDATION PER IDOT STANDARD DRAWING E-25.

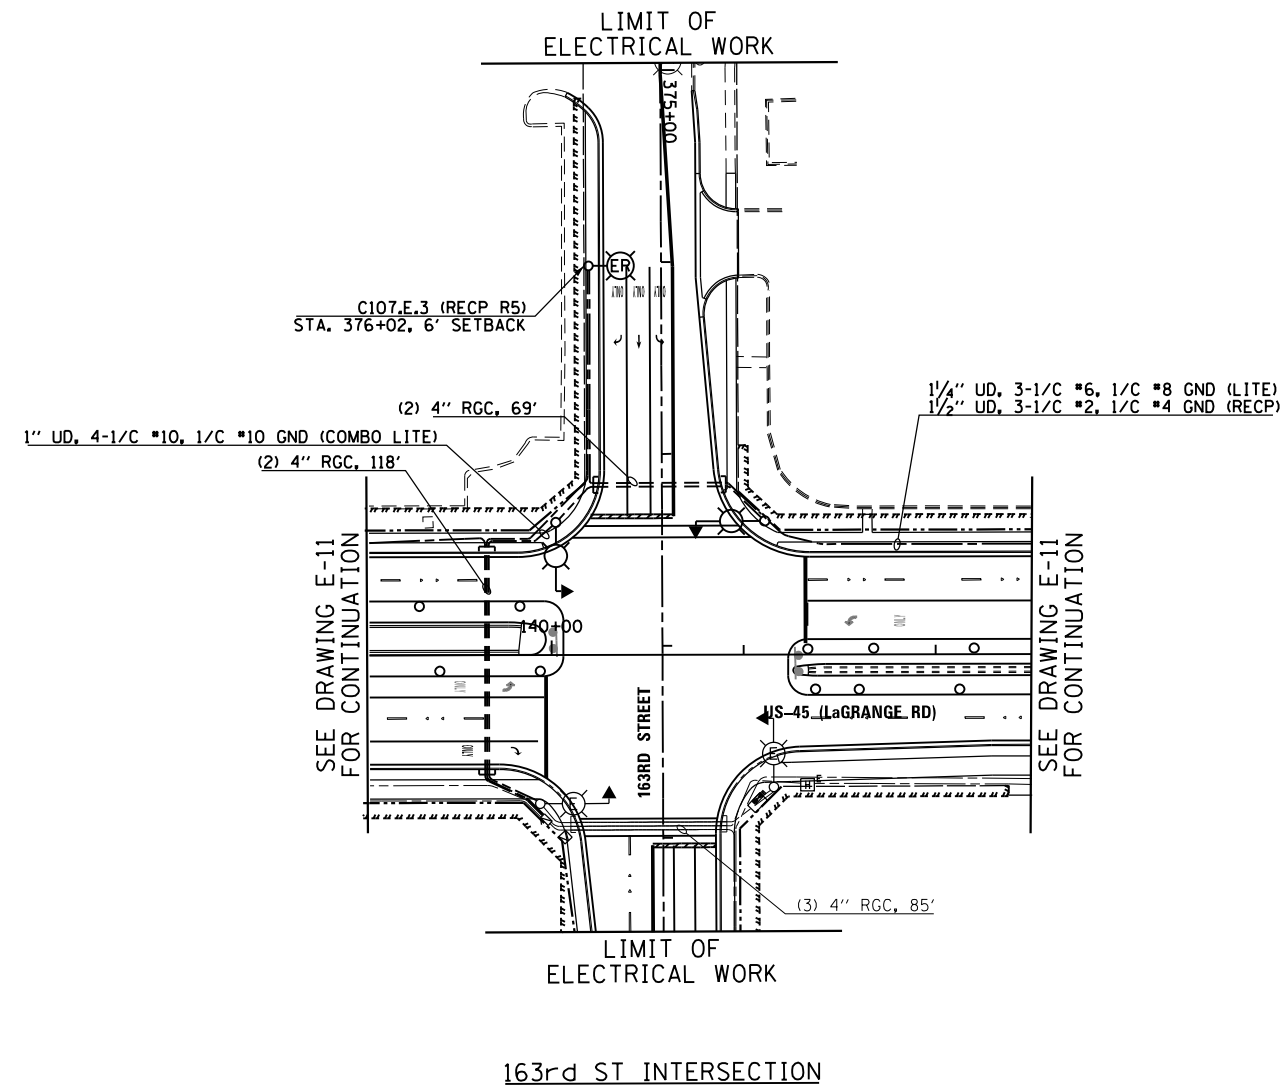

100 S. WACKER DR.  
 SUITE 600  
 CHICAGO, IL 60606  
 TEL (312) 935-1000  
 FAX (312) 935-4198  
**URS**

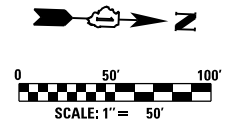

FILE NAME = D160F05-SHT-E13.dgn	USER NAME = Frank_Stallone	DESIGNED - MAE	REVISED -	<b>STATE OF ILLINOIS DEPARTMENT OF TRANSPORTATION</b>	<b>163RD STREET TEMPORARY LIGHTING PLAN: STAGE 3</b>			F.A.P. RTE.	SECTION	COUNTY	TOTAL SHEETS	SHEET NO.
	PLOT SCALE = 100.000000' / in.	CHECKED - DAD	REVISED -					330	103R-3	COOK	932	539
SHT.PLAN	PLOT DATE = 3/14/2013	DATE - 03/13/13	REVISED -	SCALE: 1"=50' SHEET 1 OF 1 SHEETS STA. 373+53.84 TO STA. 380+63.44			<b>E-13</b>		CONTRACT NO. 60F05			
											ILLINOIS FED. AID PROJECT	