

 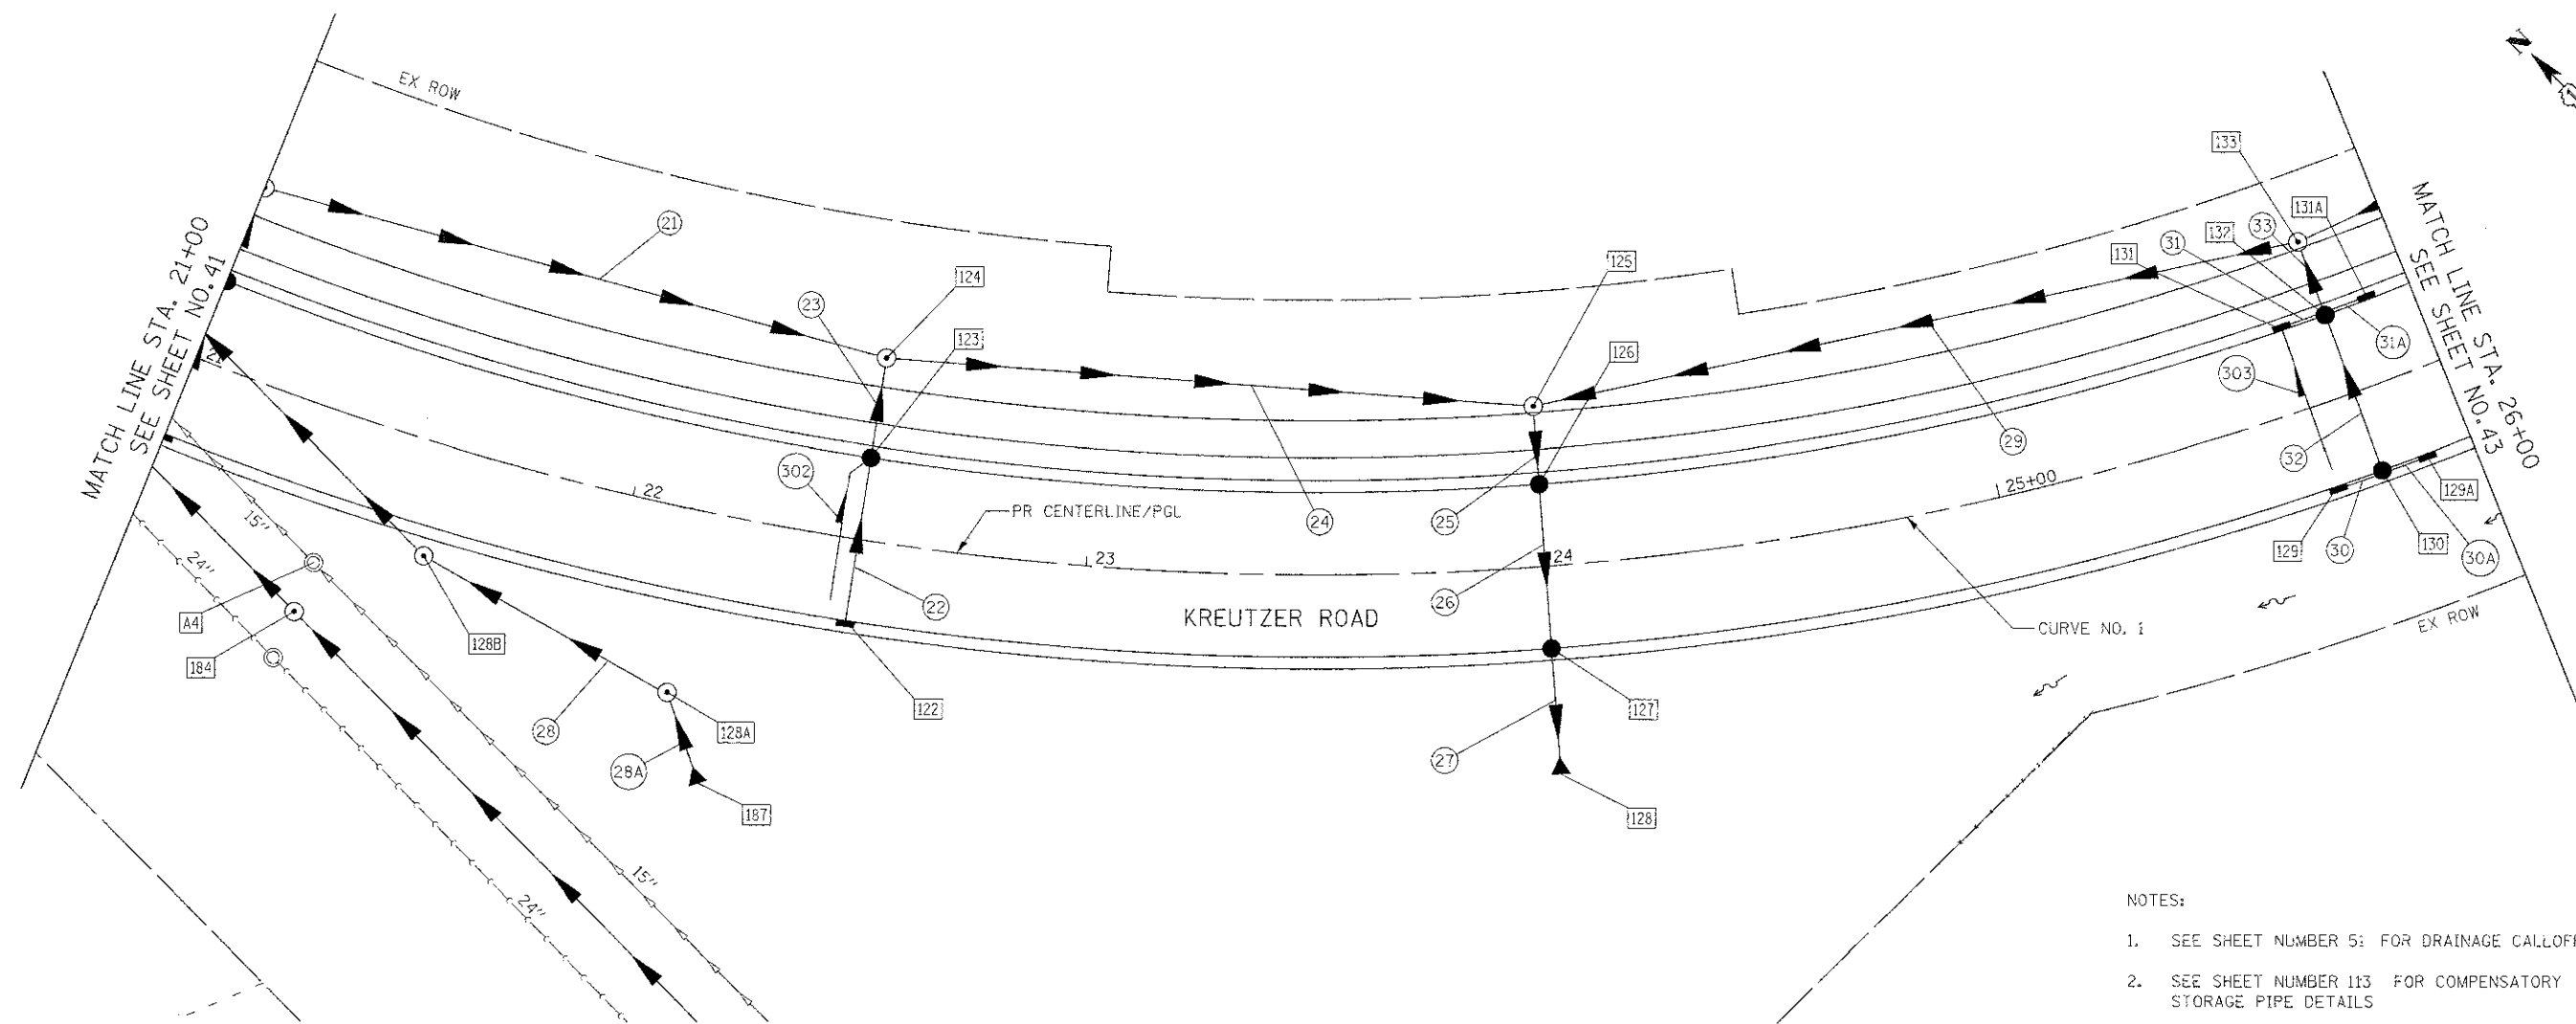


PLAN	DESIGNED	DATE
BY	BY	BY
NO.	NO.	NO.
NO.	NO.	NO.
NO.	NO.	NO.
NO.	NO.	NO.

PROF. I.E.	DATE
BY	BY
NO.	NO.
NO.	NO.
NO.	NO.
NO.	NO.

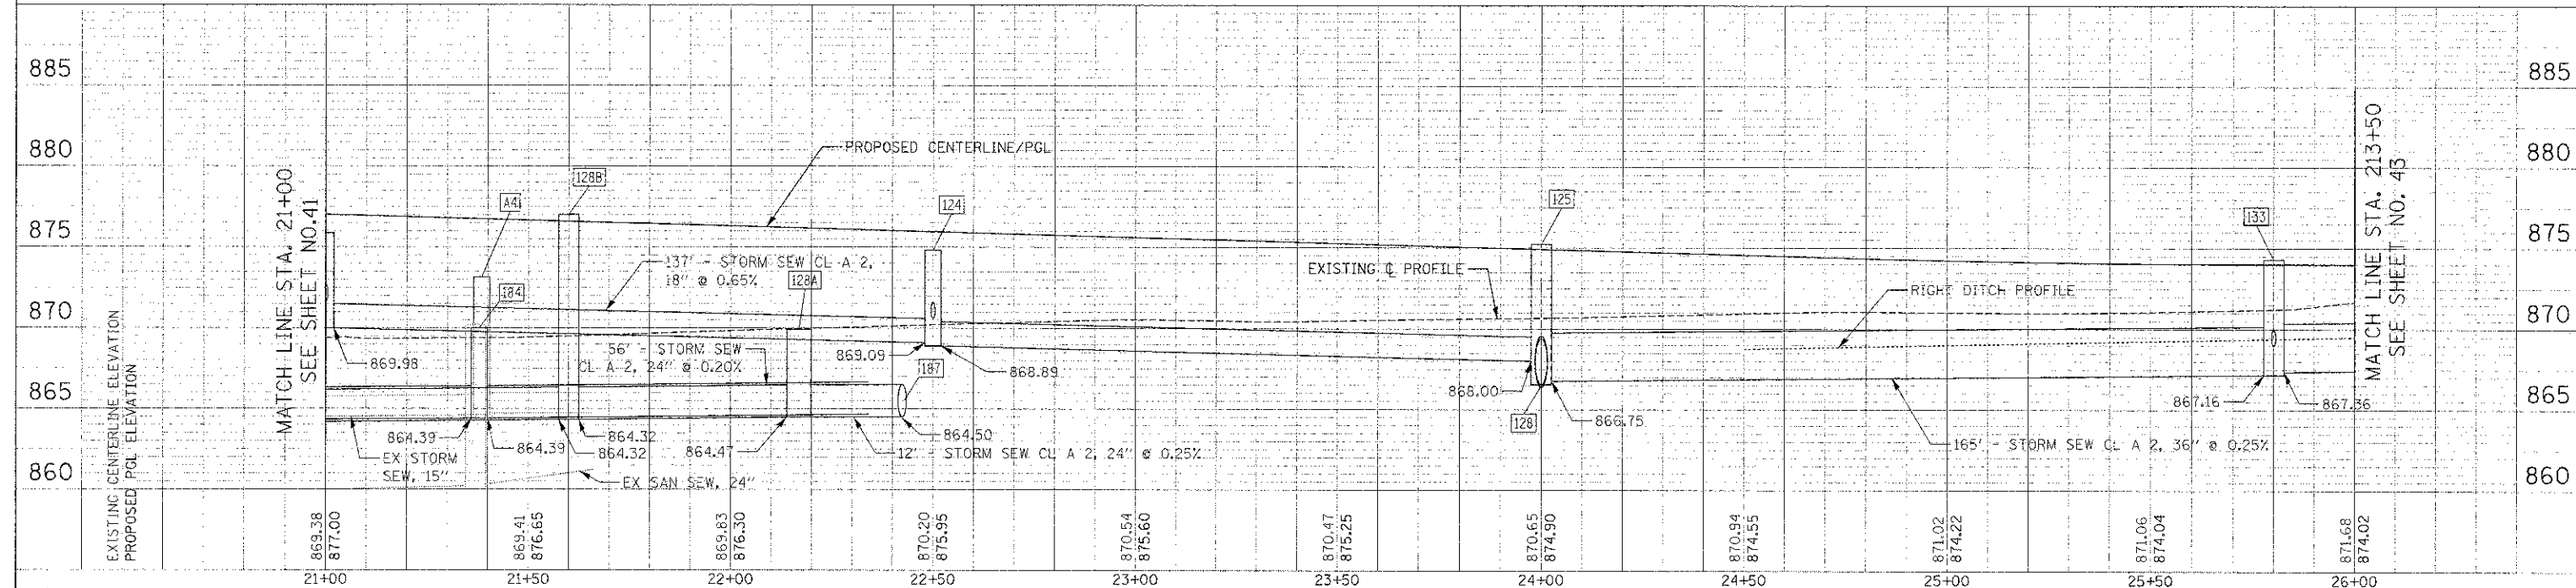

- NOTES:
- SEE SHEET NUMBER 5: FOR DRAINAGE CALLOFFS
 - SEE SHEET NUMBER 113 FOR COMPENSATORY STORAGE PIPE DETAILS



FILE NAME =	USER NAME = bas	DESIGNED - BAS	REVISED -	STATE OF ILLINOIS DEPARTMENT OF TRANSPORTATION	DRAINAGE AND UTILITY PLAN	F.A.U. RTE.	SECTION	COUNTY	TOTAL SHEETS	SHEET NO.	
...2473.D&U.03.dgn	PLLOT SCALE = 20.0000' / 1"	DRAWN - BAS	REVISED -			4068	Q7-0031-00-PV	McHENRY	167	42	
PLLOT DATE = 10/18/2012	DATE = 10/22/12	CHECKED - GAB	REVISED -			CONTRACT NO. 63743					
						FED. ROAD DIST. NO. 1 ILLINOIS; FED. AID PROJECT XXX					