


F.A. RTE.	SECTION	COUNTY	TOTAL SHEETS	SHEET NO.
2585	97-00071-00-PV	COOK	116	46
STA.	TO STA.			
FED. ROAD DIST. NO.		ILLINOIS FED. AID PROJECT		



DATE	BY
PLAN	
NOTE BOOK	
NO.	


CHRISTOPHER B. BURKE ENGINEERING LTD.  
 9575 West Higgins Road, Suite 600  
 Rosemont, Illinois 60018  
 (847) 823-0500

DATE	BY
PROFILE	
NOTE BOOK	
NO.	

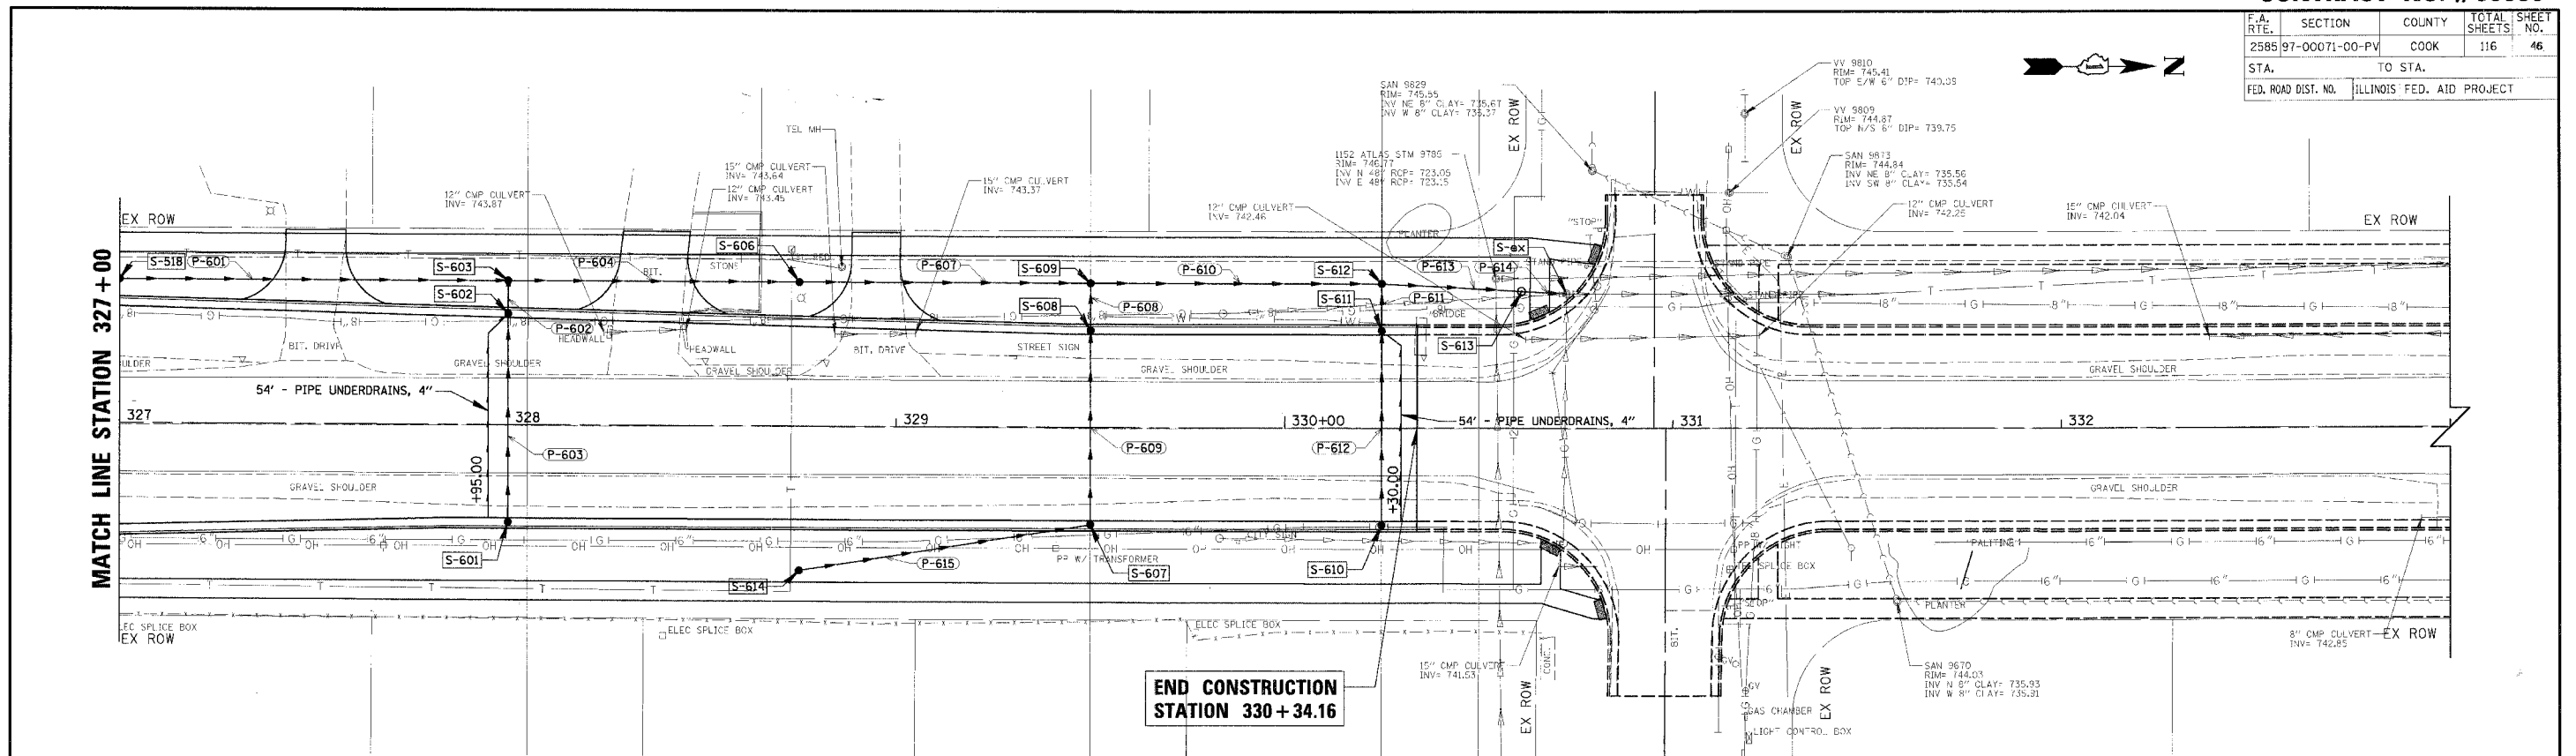

STRUCTURE NO.	STATION	OFFSET	STRUCTURE TYPE	DIA.(FT)	RIM ELEV.	N	S	E	W
S-601	328+00	24.00' RT	CB TC T24F&G	2	745.65				742.15
S-602	328+00	27.59' LT	CB TC T24F&G	2	745.65			741.61	741.61
S-603	328+00	37.00' LT	CB TA 4 DIA T8G	4	745.00	739.75	739.75	741.53	741.53
S-606	328+75	37+00' LT	CB TA 4 DIA T8G	4	745.38	739.62	739.62	741.53	741.53
S-607	329+50	24.00' RT	CB TC T24F&G	2	745.12				741.62
S-608	329+50	24.00' LT	CB TC T24F&G	2	745.12			741.12	741.12
S-609	329+50	37.00' LT	CB TA 4 DIA T8G	4	744.32	739.05	739.05	741.00	741.00
S-610	330+25	24.00' RT	CB TC T24F&G	2	744.86				741.36
S-611	330+25	24.00' LT	CB TC T24F&G	2	744.86			740.86	740.86
S-612	330+25	37.00' LT	CB TA 4 DIA T8G	4	744.75	738.88	738.88	740.74	740.74
S-613	330+61	35.16' LT	MAN TA 5 DIA T1F CL	5	744.9	738.81	738.81		
S-614	328+75	37.00' RT	CB TA 4 DIA T8G	4	743.6	742.00			

PIPE NO.	FROM	TO	MATERIAL	TYPE	LENGTH (FT)	DIA. (IN)	UPPER INVERT	LOWER INVERT	SLOPE	TBF
P-601	S-518	S-603	RCP	2	100	24	740.13	739.75	0.38	24.0
P-602	S-602	S-603	RCP	2	8	12	741.61	741.53	1.00	0.00
P-603	S-601	S-602	RCP	2	54	12	742.15	741.61	1.00	24.0
P-604	S-603	S-606	RCP	2	75	24	739.75	739.62	0.17	20.0
P-607	S-606	S-609	RCP	2	75	24	739.62	739.05	0.76	0.00
P-608	S-608	S-609	RCP	2	12	12	741.12	741.00	1.00	0.00
P-609	S-607	S-608	RCP	2	50	12	741.62	741.12	1.00	27.0
P-610	S-609	S-612	RCP	2	75	24	739.05	738.88	0.23	0.00
P-611	S-611	S-612	RCP	2	12	12	740.86	740.74	1.00	0.00
P-612	S-610	S-611	RCP	2	50	12	741.36	740.86	1.00	28.0
P-613	S-612	S-613	RCP	2	36	24	738.88	738.81	0.19	0.00
P-614	S-613	S-ex	RCP	2	12	18	738.81	738.79	0.17	2.00
P-615	S-614	S-607	RCP	2	76	12	742.00	741.62	0.50	0.00

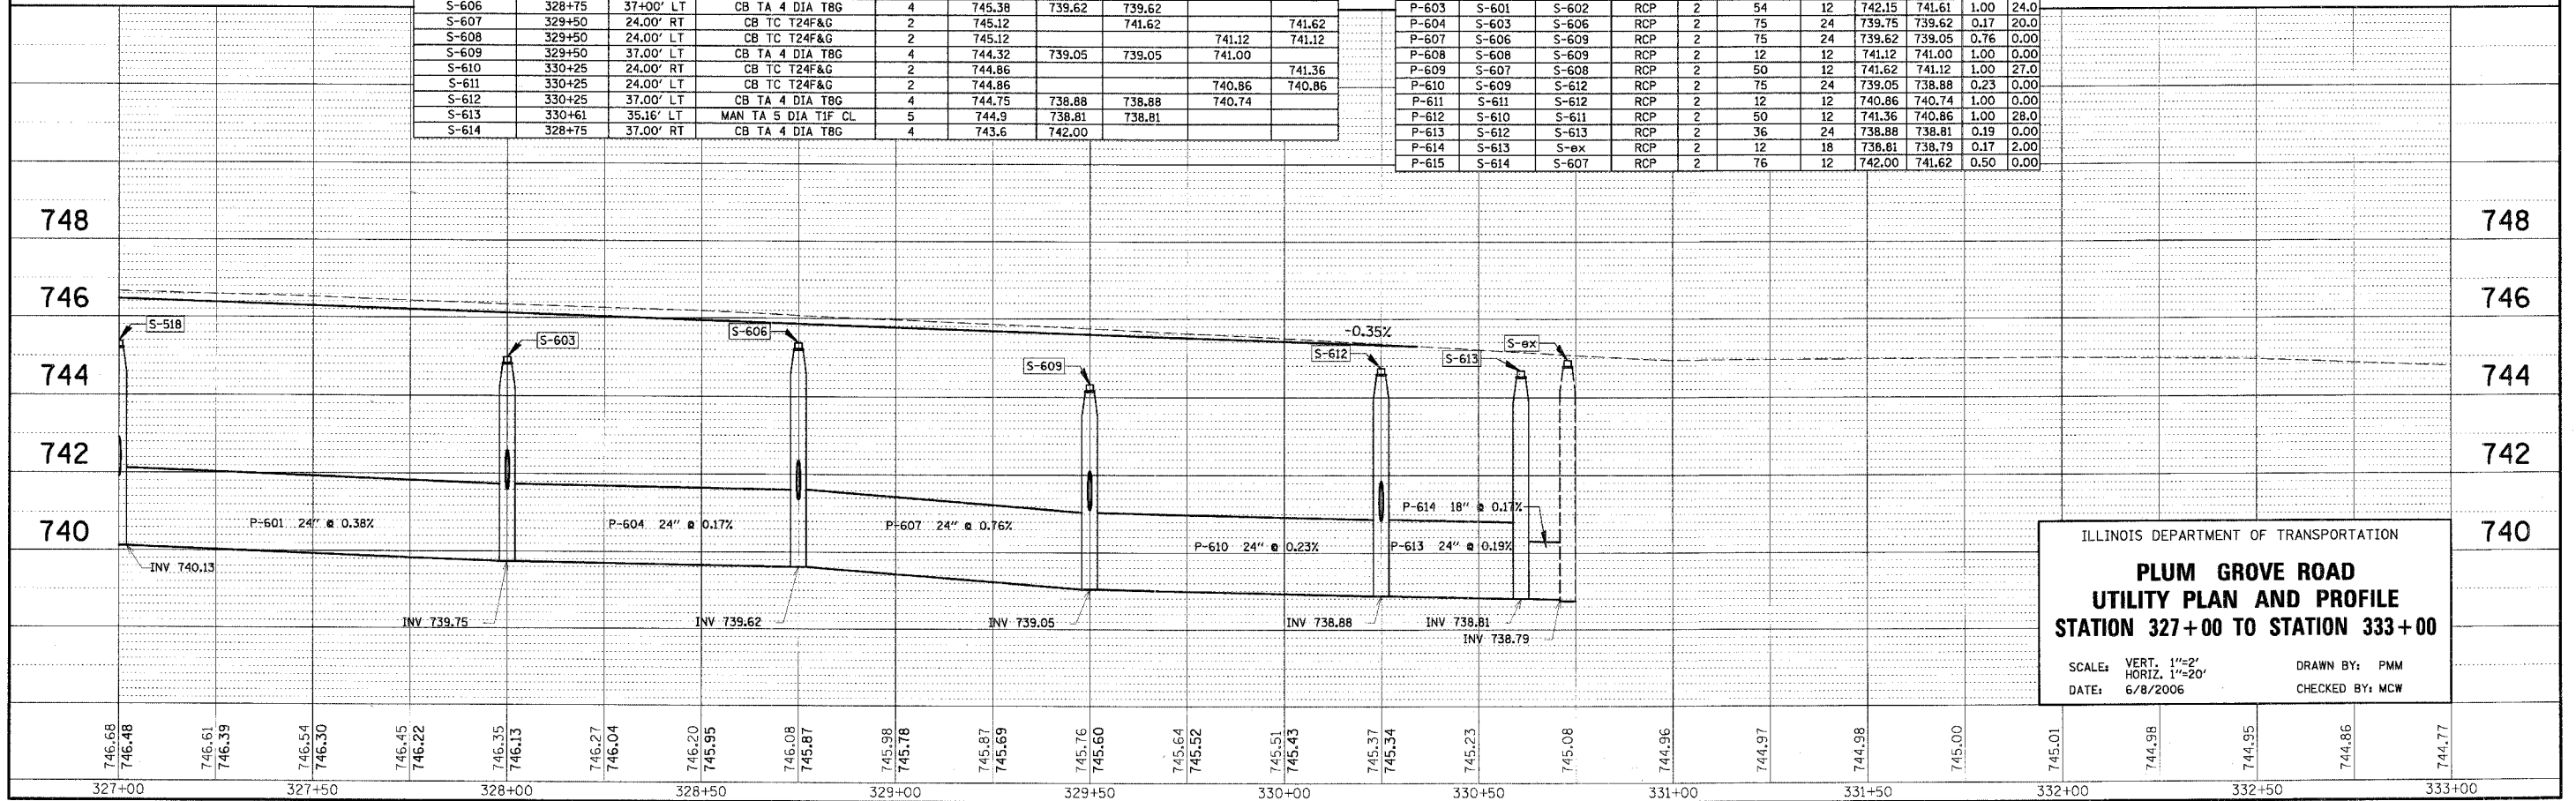

ILLINOIS DEPARTMENT OF TRANSPORTATION

**PLUM GROVE ROAD  
 UTILITY PLAN AND PROFILE  
 STATION 327+00 TO STATION 333+00**

SCALE: VERT. 1"=2'  
 HORIZ. 1"=20'

DATE: 6/8/2006

DRAWN BY: PMM  
 CHECKED BY: MCW