

CONTRACT NO. #83853

F.A. RTE.	SECTION	COUNTY	TOTAL SHEETS	SHEET NO.
2585	97-00071-00-PV	COOK	116	58
STA.	TO STA.			
FED. ROAD DIST. NO.	ILLINOIS	FED. AID PROJECT		


DATE	BY
PLAN	DESIGNED
	ALIGNED
	CHECKED
	NO. 1
	NO. 2
	NO. 3
	NO. 4
	NO. 5
	NO. 6
	NO. 7
	NO. 8
	NO. 9
	NO. 10

CHRISTOPHER B. BURKE ENGINEERING LTD.
 9515 West Higgins Road, Suite 600
 Rosemont, Illinois 60018
 (847) 823-0500



DATE	BY
PROFILE	DESIGNED
	ALIGNED
	CHECKED
	NO. 1
	NO. 2
	NO. 3
	NO. 4
	NO. 5
	NO. 6
	NO. 7
	NO. 8
	NO. 9
	NO. 10


PLUM GROVE RD.

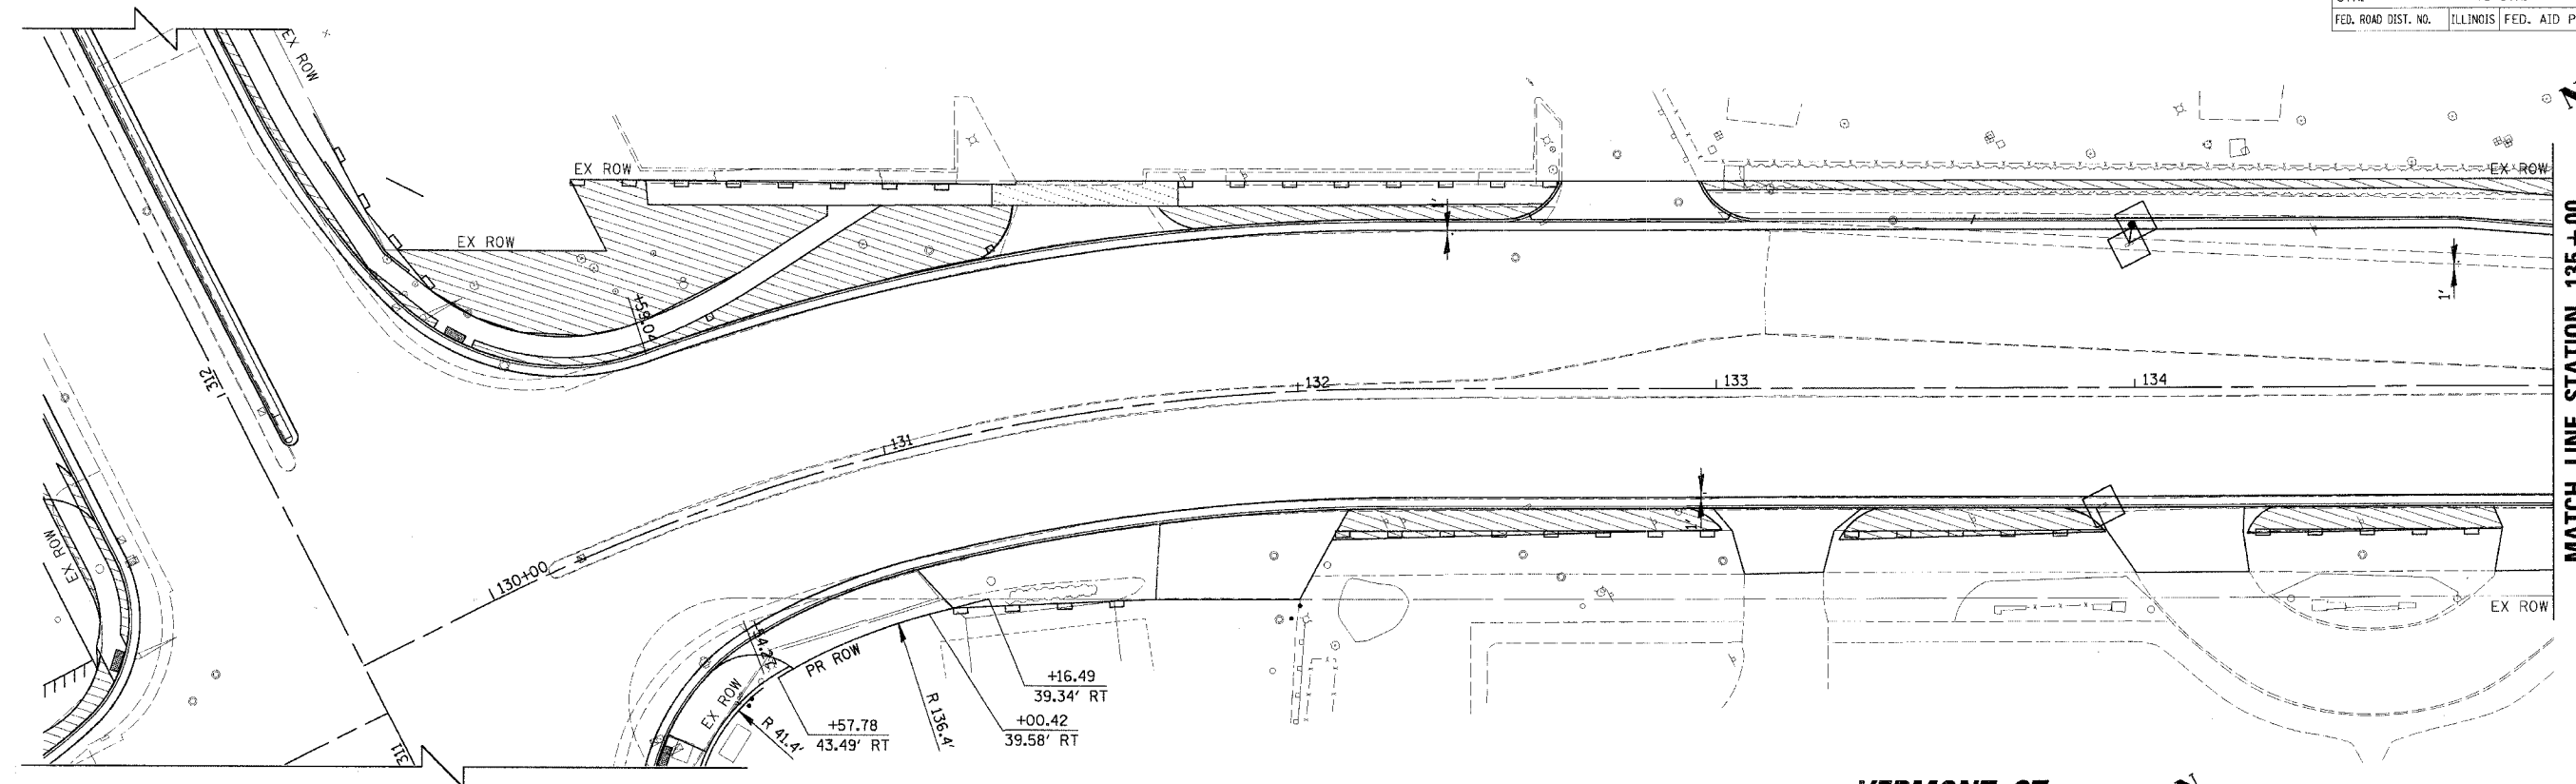

PLUM GROVE RD.

**END CONSTRUCTION
 STATION 136 + 58.21**

VERMONT ST.

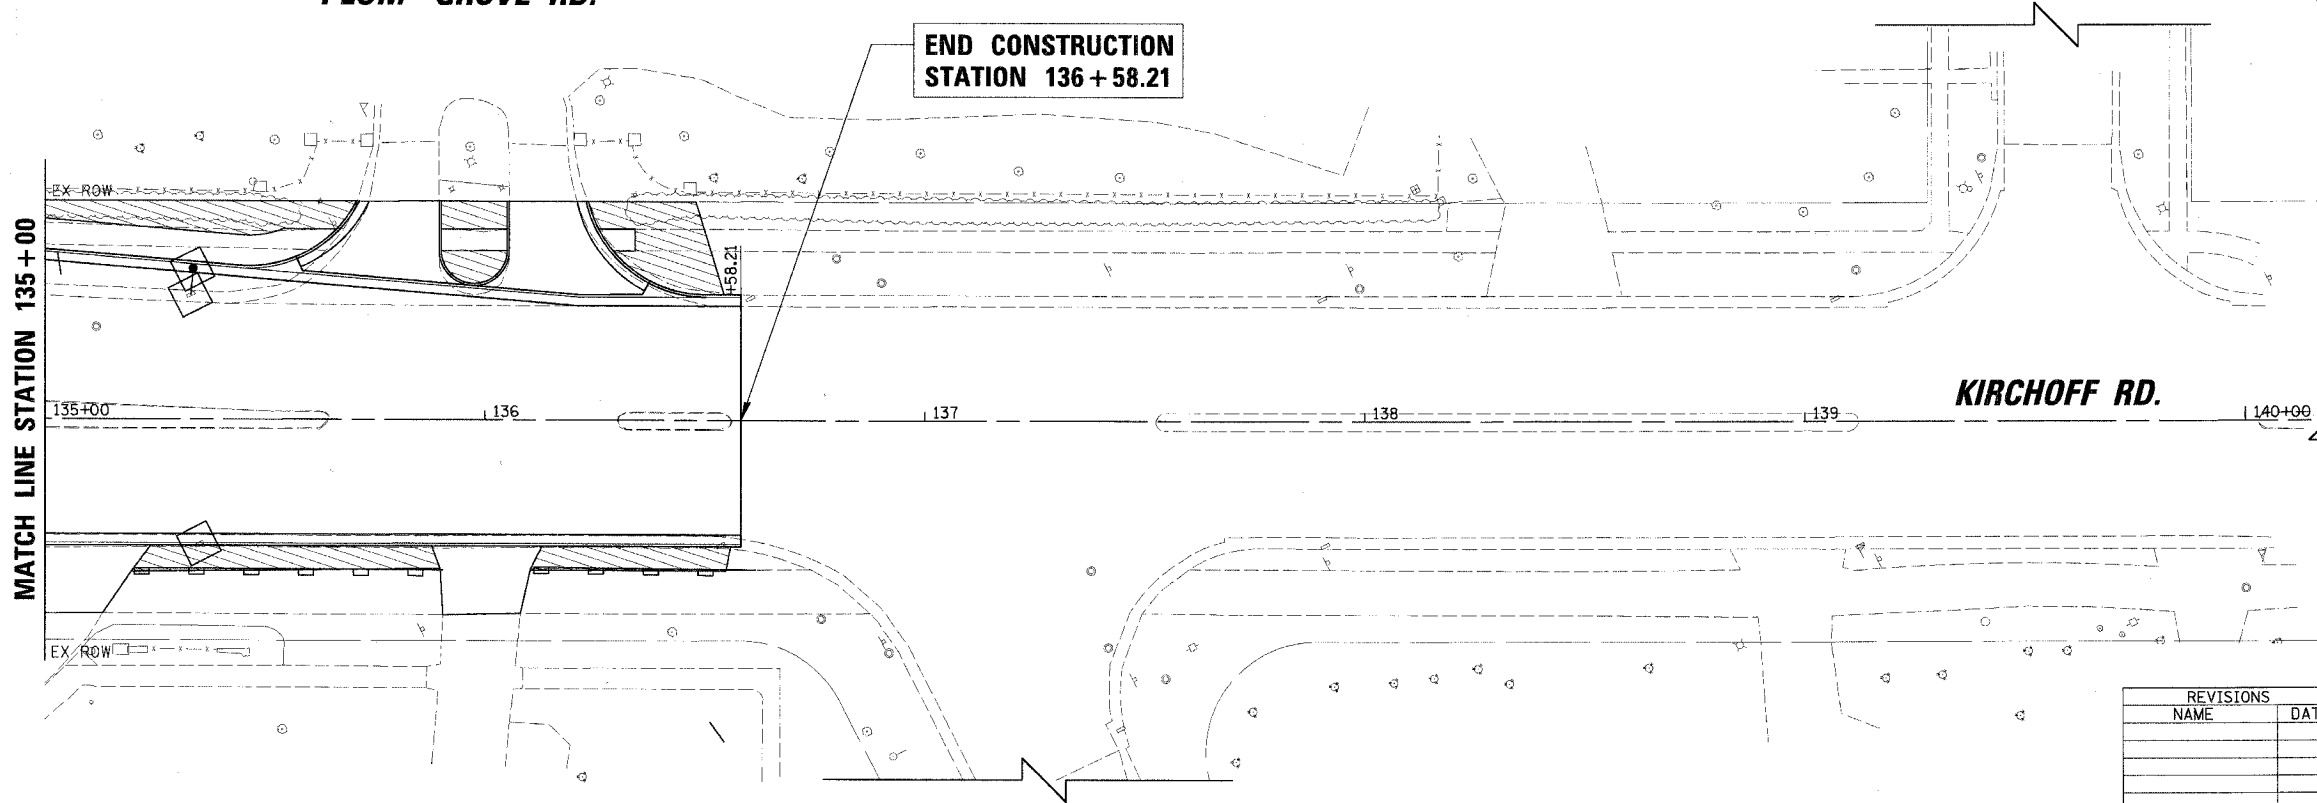

MATCH LINE STATION 135+00

MATCH LINE STATION 135+00

- LEGEND:**
- SILT FENCE
 - INLET AND PIPE PROTECTION
 - INLET FILTER
 - SODDING
 - DITCH CHECK

REVISIONS	
NAME	DATE

ILLINOIS DEPARTMENT OF TRANSPORTATION

**KIRCHOFF ROAD
 EROSION CONTROL PLAN
 STATION 130+00 TO STATION 136+58.21**

SCALE: 20'
 DATE: 6/8/2006

DRAWN BY: PMM
 CHECKED BY: MCW

h:\n\oldms\98361br48\design\98361br48_klr130.eop