 




F.A.U. RTE.	SECTION	COUNTY	TOTAL SHEETS	SHEET NO.
6998	99-00209-01-PV	VERMILION	296	77
STA. 97+00		TO STA. 103+00		
FED. ROAD DIST. NO. ILLINOIS		FED. AID PROJECT-		
CONTRACT NO.: 91358				

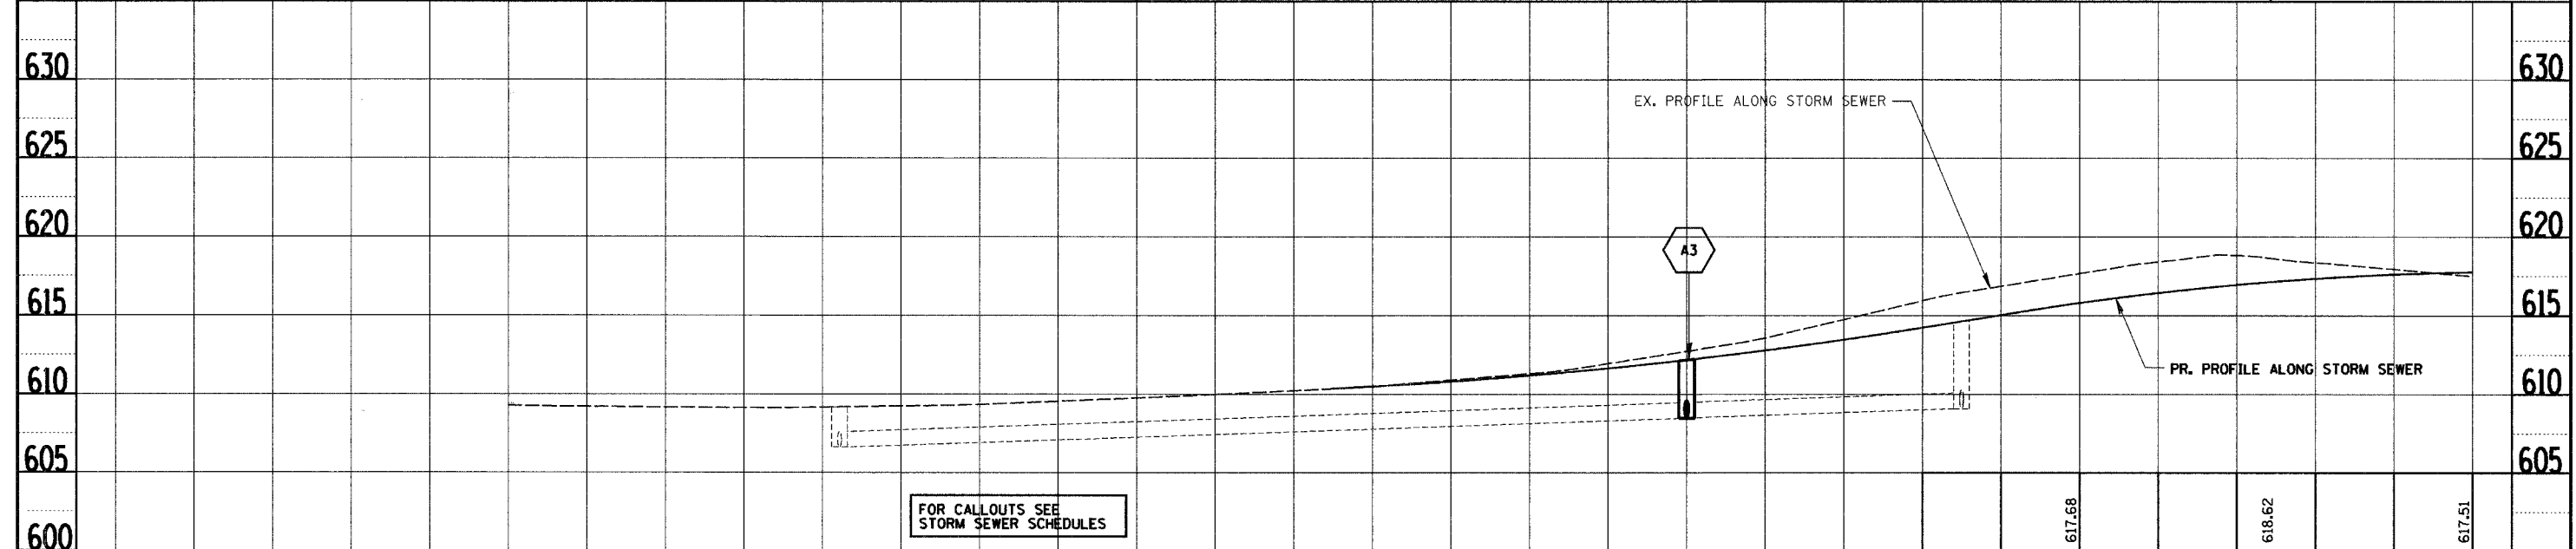

PLAN	SURVEYED	DATE
	BY	
	PLOTTED	
	CHECKED	
	RT. OF WAY CHECKED	
	CADD FILE NAME	
	NO.	

PROFILE	SURVEYED	DATE
	BY	
	PLOTTED	
	CHECKED	
	S.M. NOTED	
	STRUCTURE NOTATIONS CPFD	
	NO.	

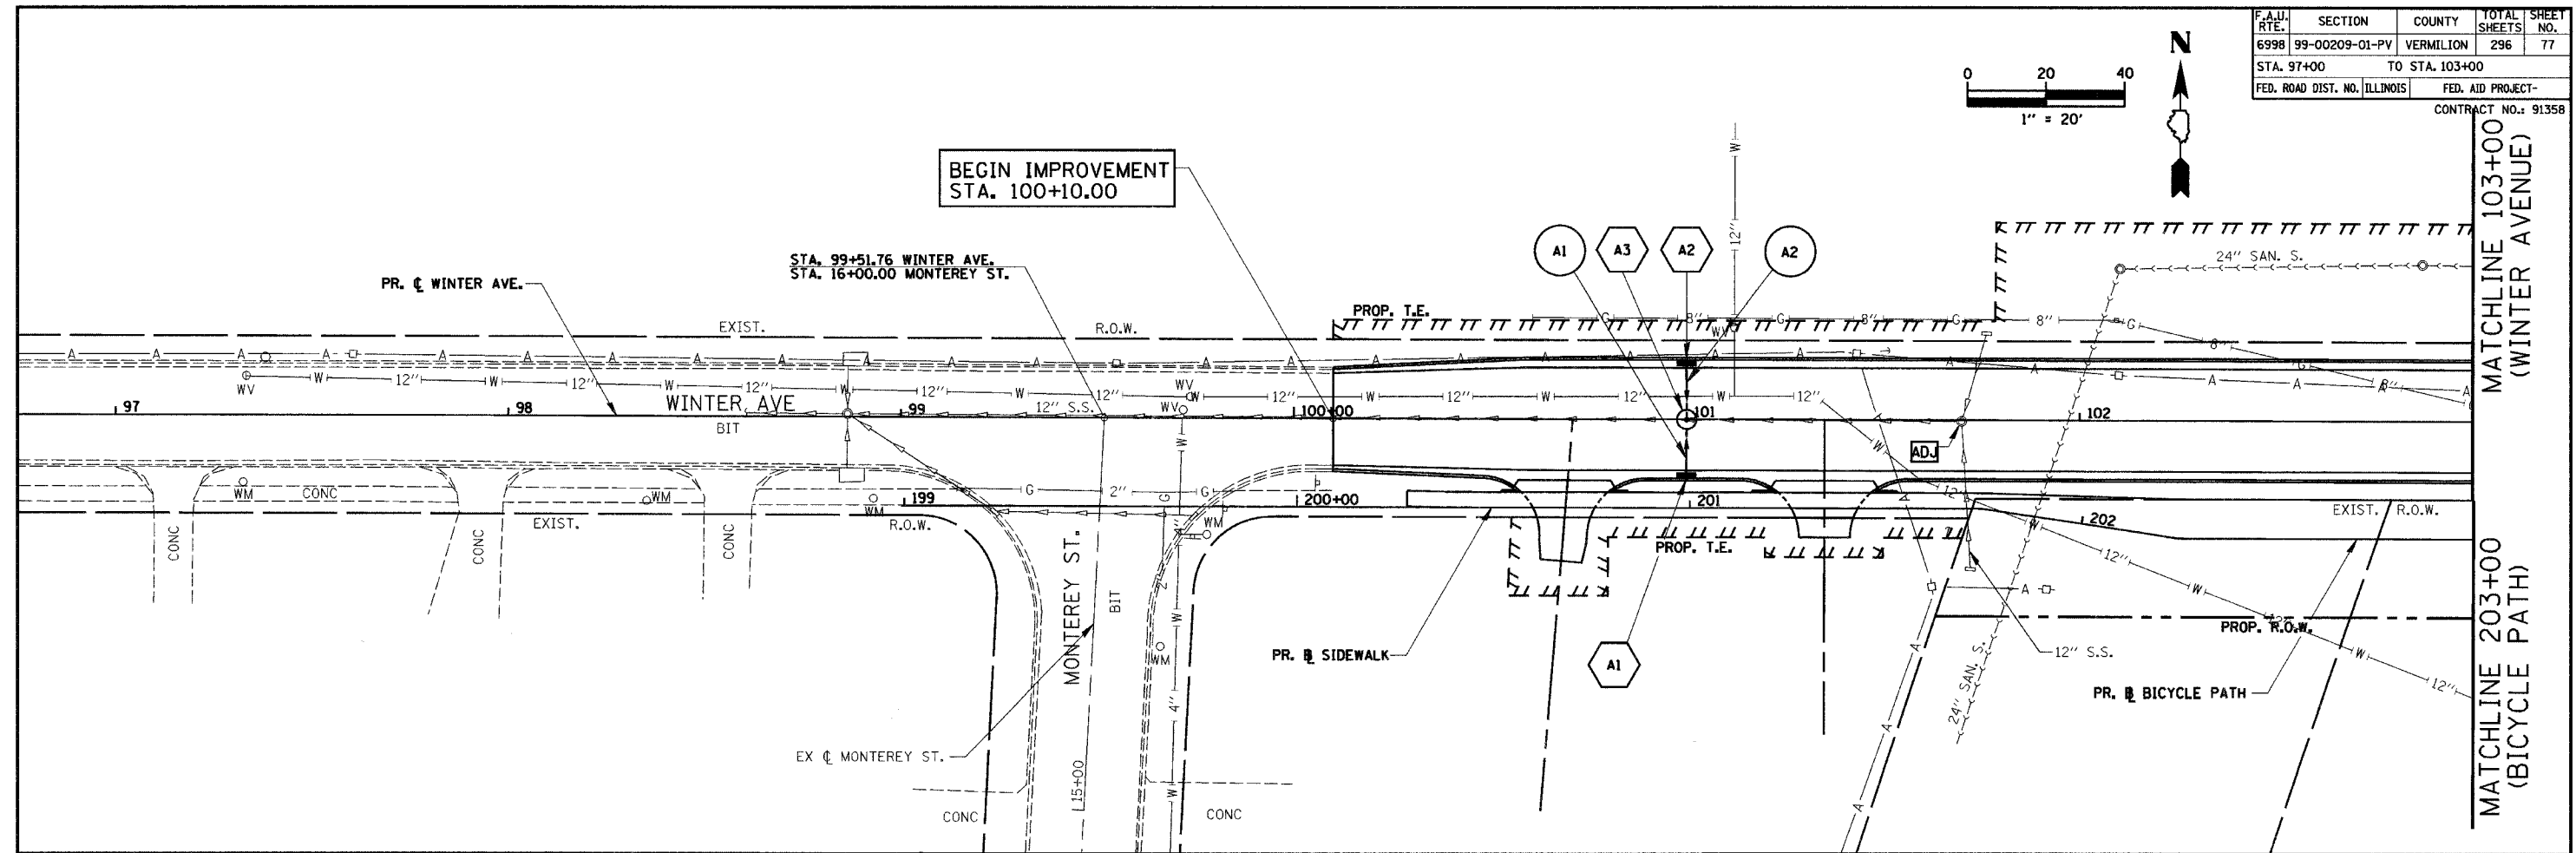

REVISIONS	NAME	DATE

CITY OF DANVILLE, ILLINOIS
**WINTER AVENUE RECONSTRUCTION
 PROPOSED DRAINAGE PLAN
 WINTER AVENUE/BICYCLE PATH
 STA. 97+00 TO STA. 103+00**

SCALE: 1" = 20' HORIZ.
 1" = 5' VERT.

DATE: 12/21/06
 DRAWN BY: CGF
 CHECKED BY: TDN