 



F.A.I.D. NO.	SECTION	COUNTY	TOTAL SHEETS	SHEET NO.
6998	99-00209-01-PV	VERMILION	296	81
STA. 145+00		TO STA. 151+00		
FED. ROAD DIST. NO. ILLINOIS		FED. AID PROJECT-		
CONTRACT NO.: 91358				



PLAN	SURVEYED	DATE
	BY	
	NOTED	
	CHECKED	
	DATE	
	NO.	

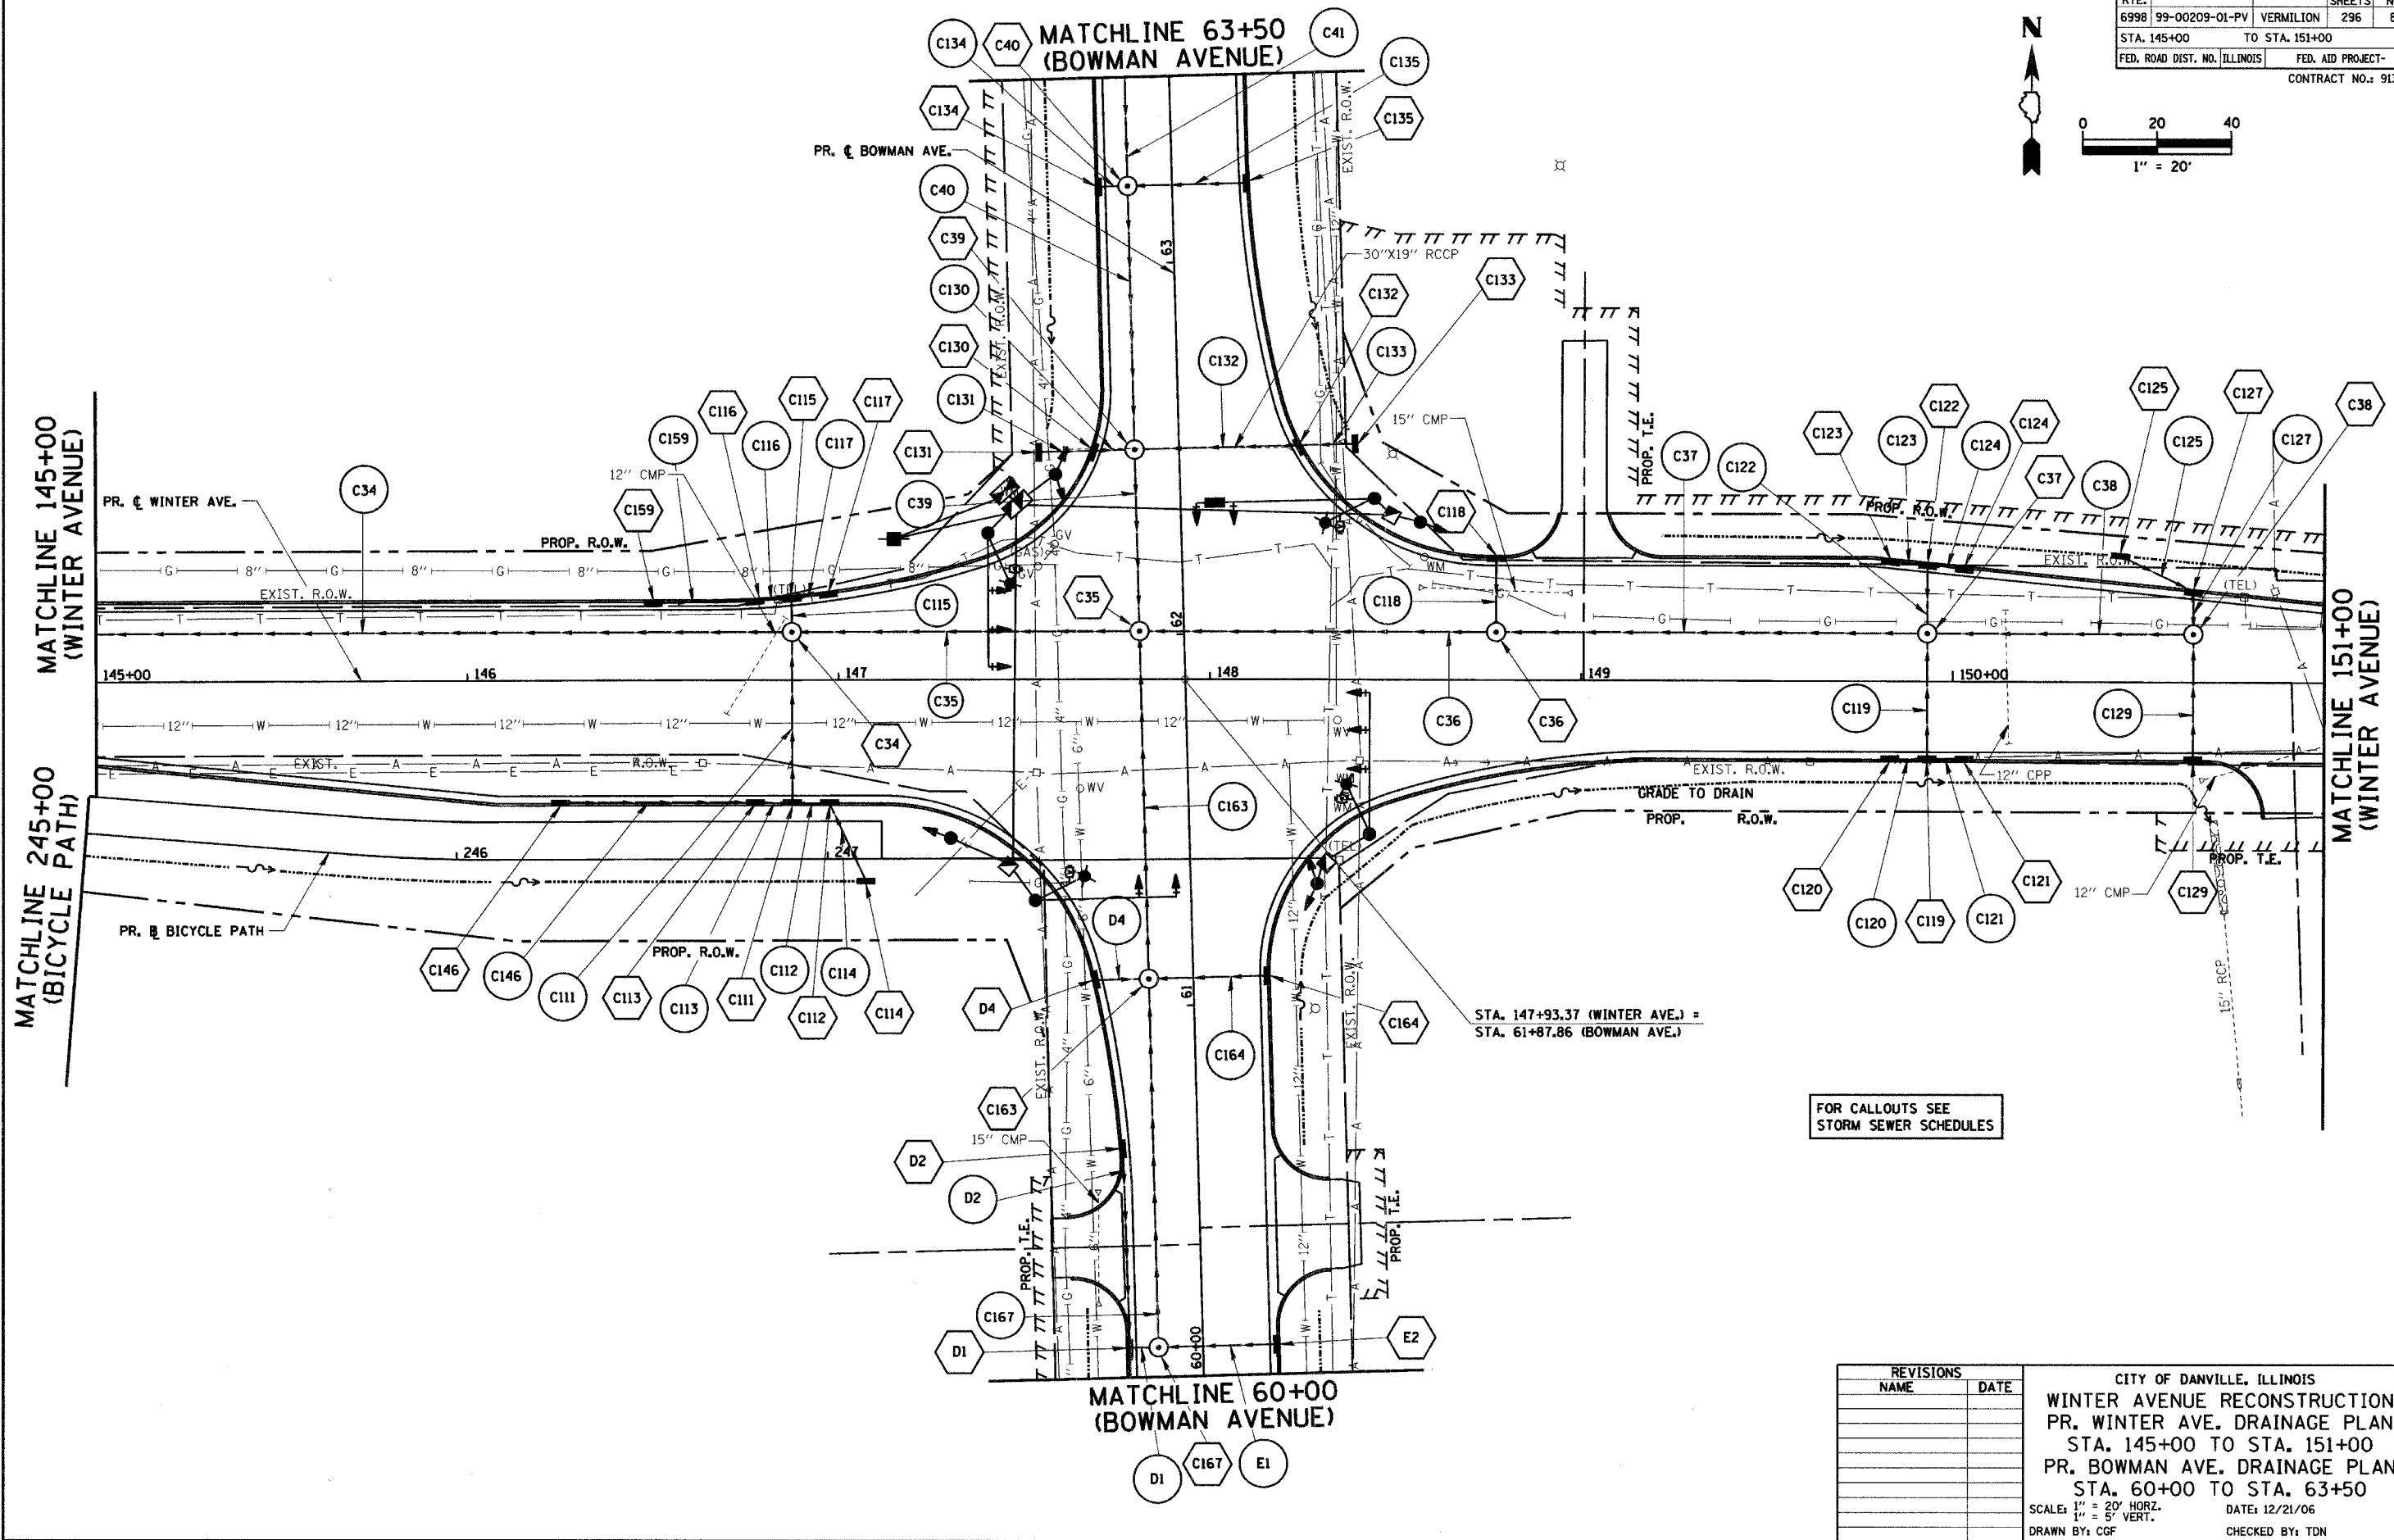

FOR CALLOUTS SEE STORM SEWER SCHEDULES

STA. 147+93.37 (WINTER AVE.) =
STA. 61+87.86 (BOWMAN AVE.)

REVISIONS	
NAME	DATE

CITY OF DANVILLE, ILLINOIS
WINTER AVENUE RECONSTRUCTION
 PR. WINTER AVE. DRAINAGE PLAN
 STA. 145+00 TO STA. 151+00
 PR. BOWMAN AVE. DRAINAGE PLAN
 STA. 60+00 TO STA. 63+50
 SCALE: 1" = 20' HORIZ.
 1" = 5' VERT.
 DRAWN BY: CGF
 DATE: 12/21/06
 CHECKED BY: TDN