
 
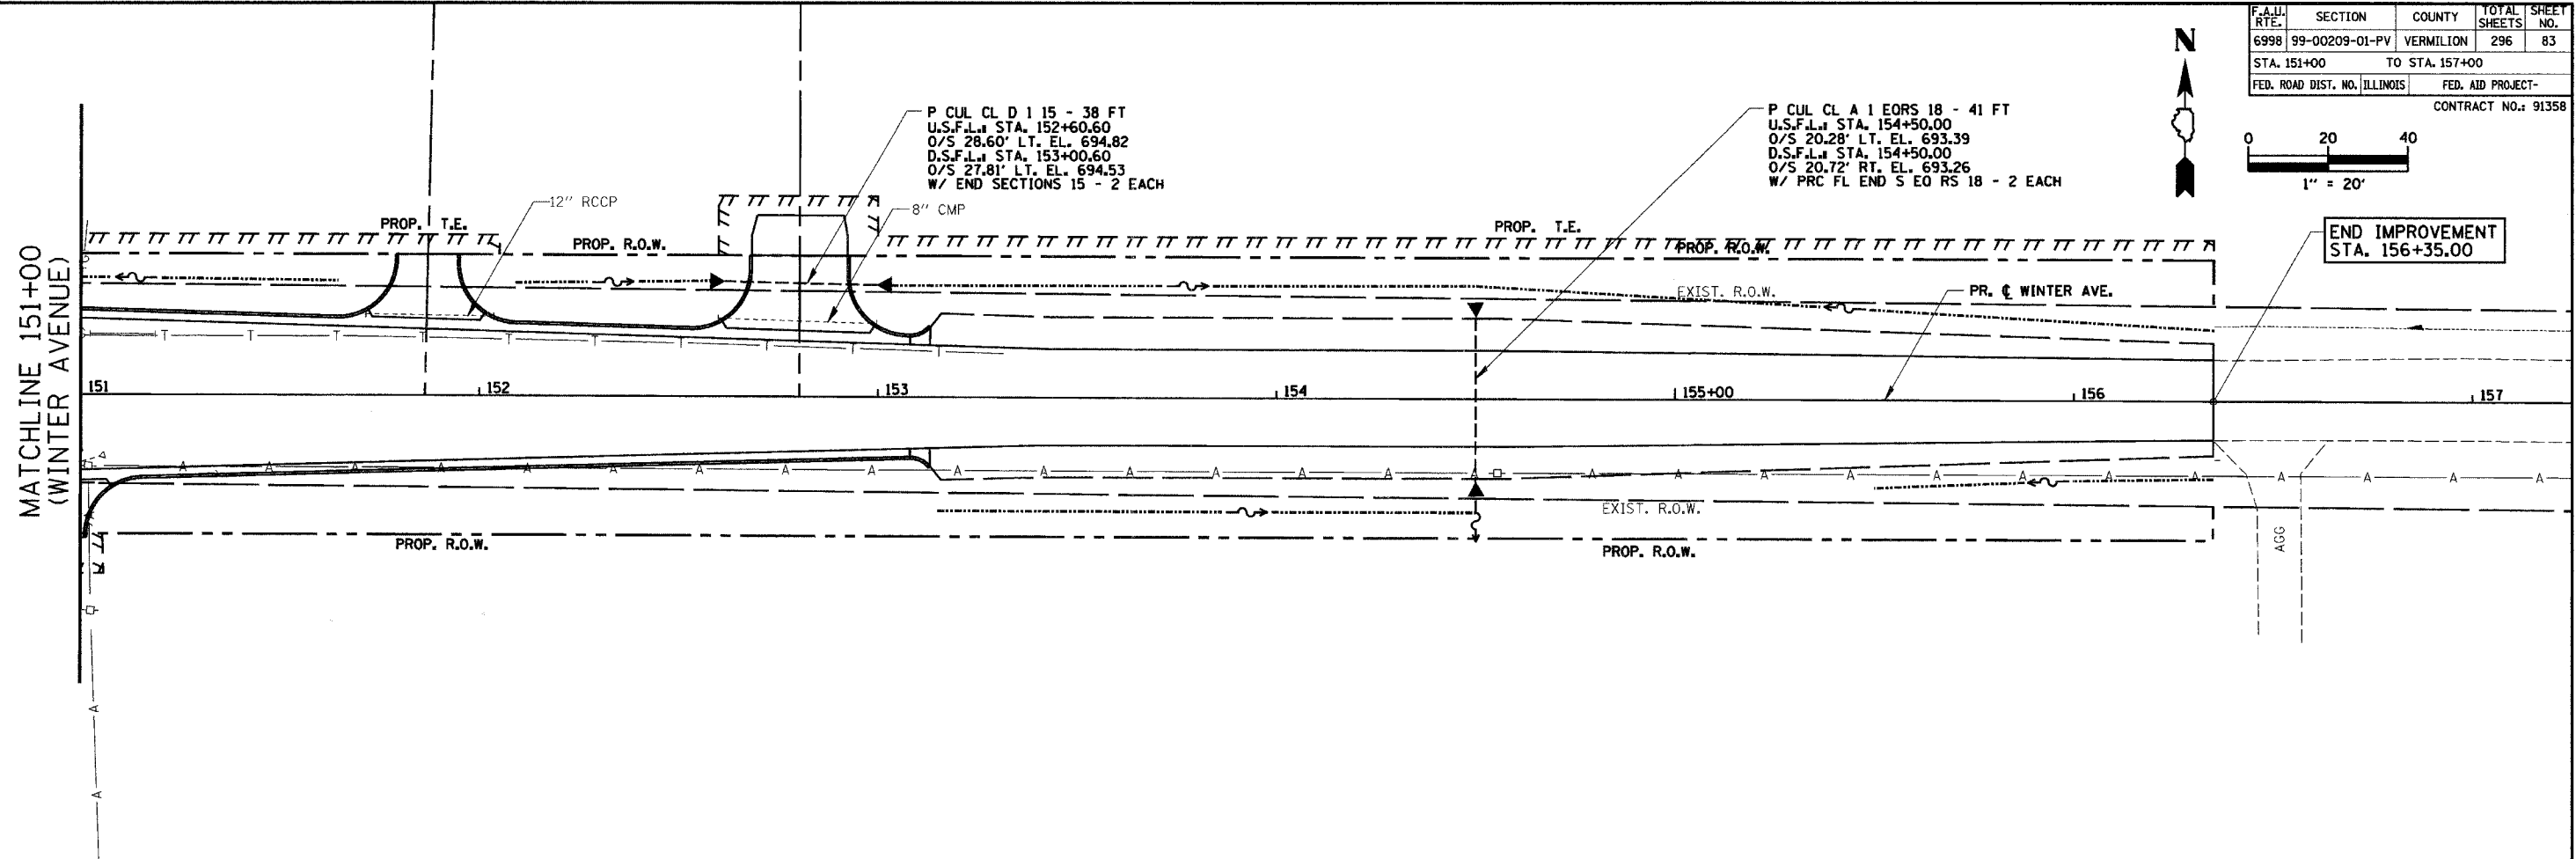


F.A.I.D. NO.	SECTION	COUNTY	TOTAL SHEETS	SHEET NO.
6998	99-00209-01-PV	VERMILION	296	83
STA. 151+00		TO STA. 157+00		
FED. ROAD DIST. NO. ILLINOIS		FED. AID PROJECT-		
CONTRACT NO.: 91358				



PLAN	SURVEYED	DATE
	BY	
	NOTED	
	BY	
	DATE	
	BY	
	DATE	

PROFILE	SURVEYED	DATE
	BY	
	NOTED	
	BY	
	DATE	
	BY	
	DATE	

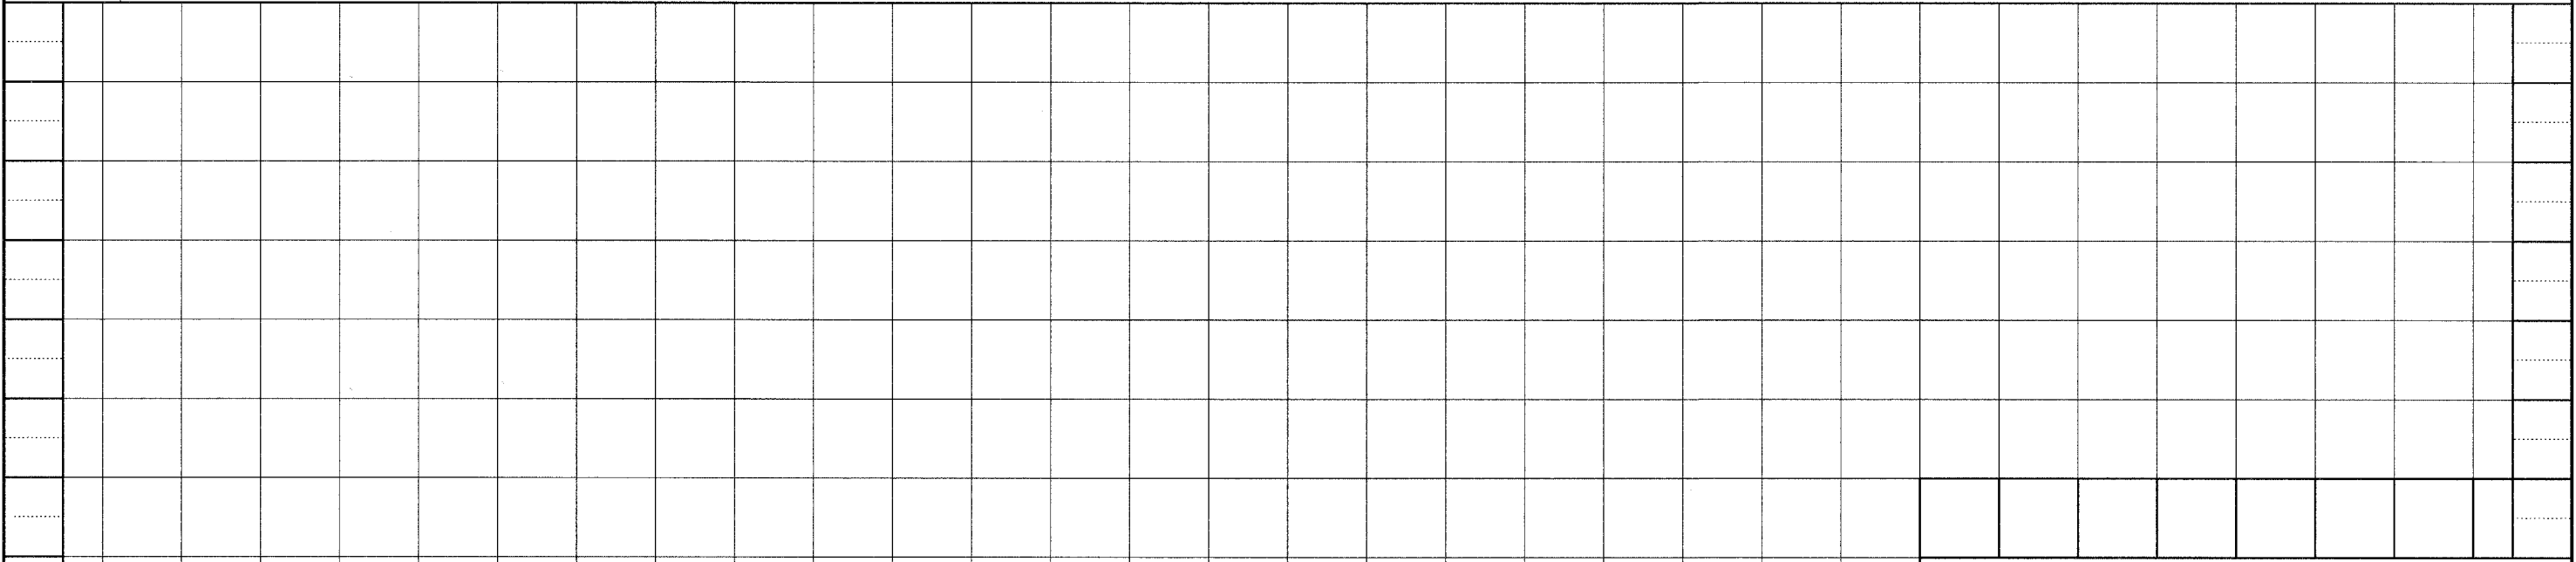

REVISIONS		NAME	DATE
NO.	DESCRIPTION		

CITY OF DANVILLE, ILLINOIS
WINTER AVENUE RECONSTRUCTION
PROPOSED DRAINAGE PLAN
WINTER AVENUE
STA. 151+00 TO STA. 157+00

SCALE: 1" = 20' HORIZ.
1" = 5' VERT.

DRAWN BY: CGF
CHECKED BY: TDN

DATE: 12/21/06