


PLAN	SURVEYED	DATE
	PLOTTED	BY
	GRADES CHECKED	
	STRUCTURE NOTATIONS CHECKED	
	NOTE BOOK	
	NO.	
	FILE NAME	


PROFILE	SURVEYED	DATE
	PLOTTED	BY
	GRADES CHECKED	
	STRUCTURE NOTATIONS CHECKED	
	NOTE BOOK	
	NO.	
	FILE NAME	

MATCH LINE STA 21+00

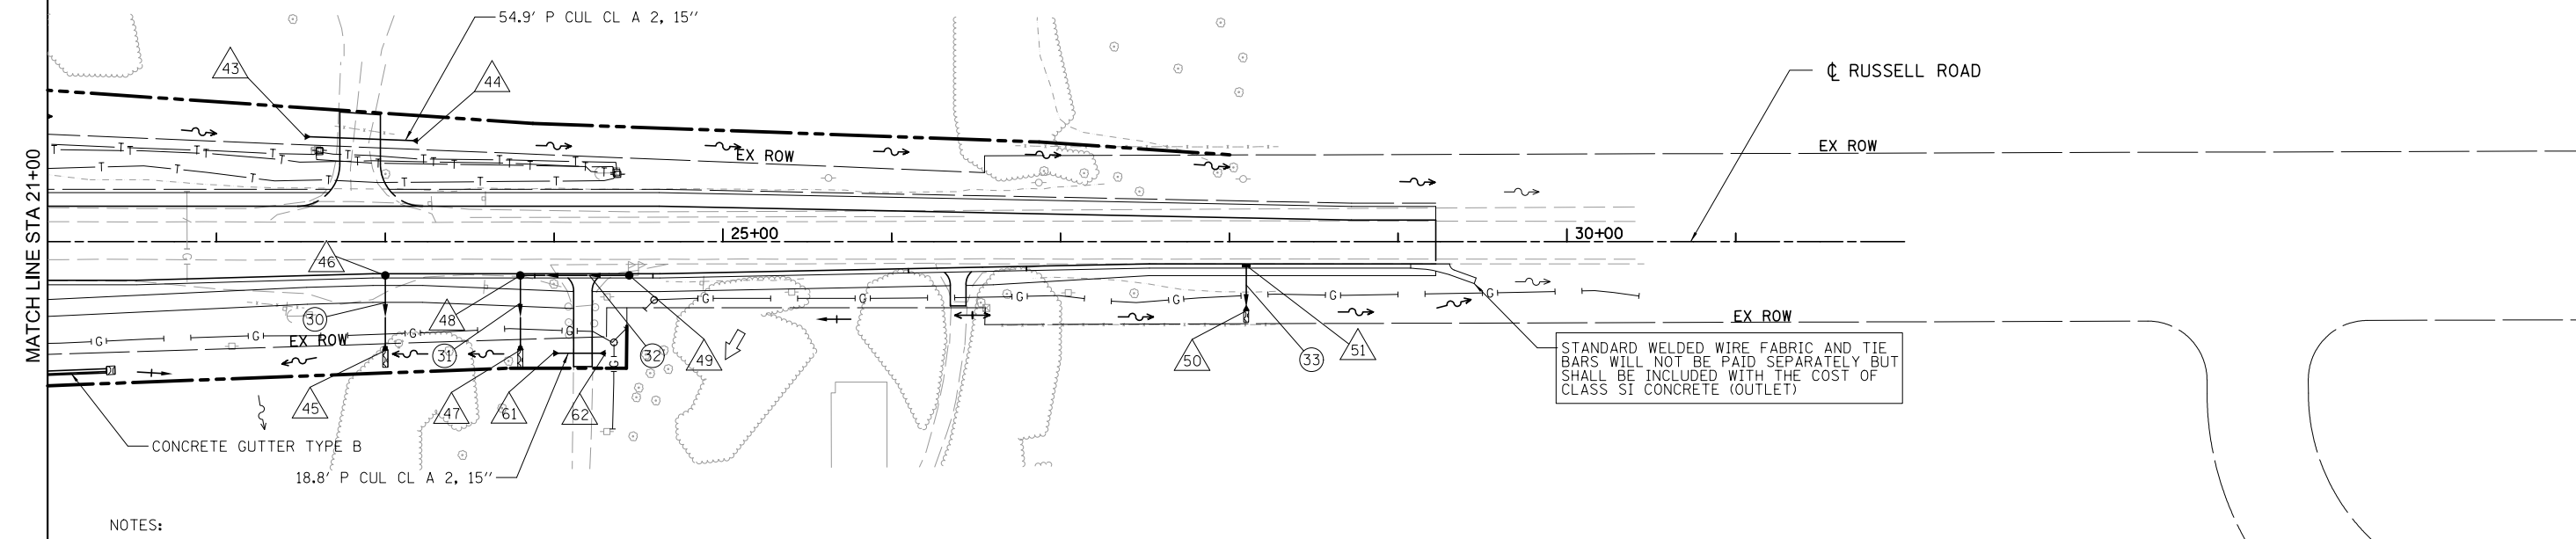

NOTES:

- FOR STRUCTURE AND PIPE SCHEDULES SEE SHEETS NO. 54 AND 55.
- FOR LEGEND SEE SHEET NO. 48.

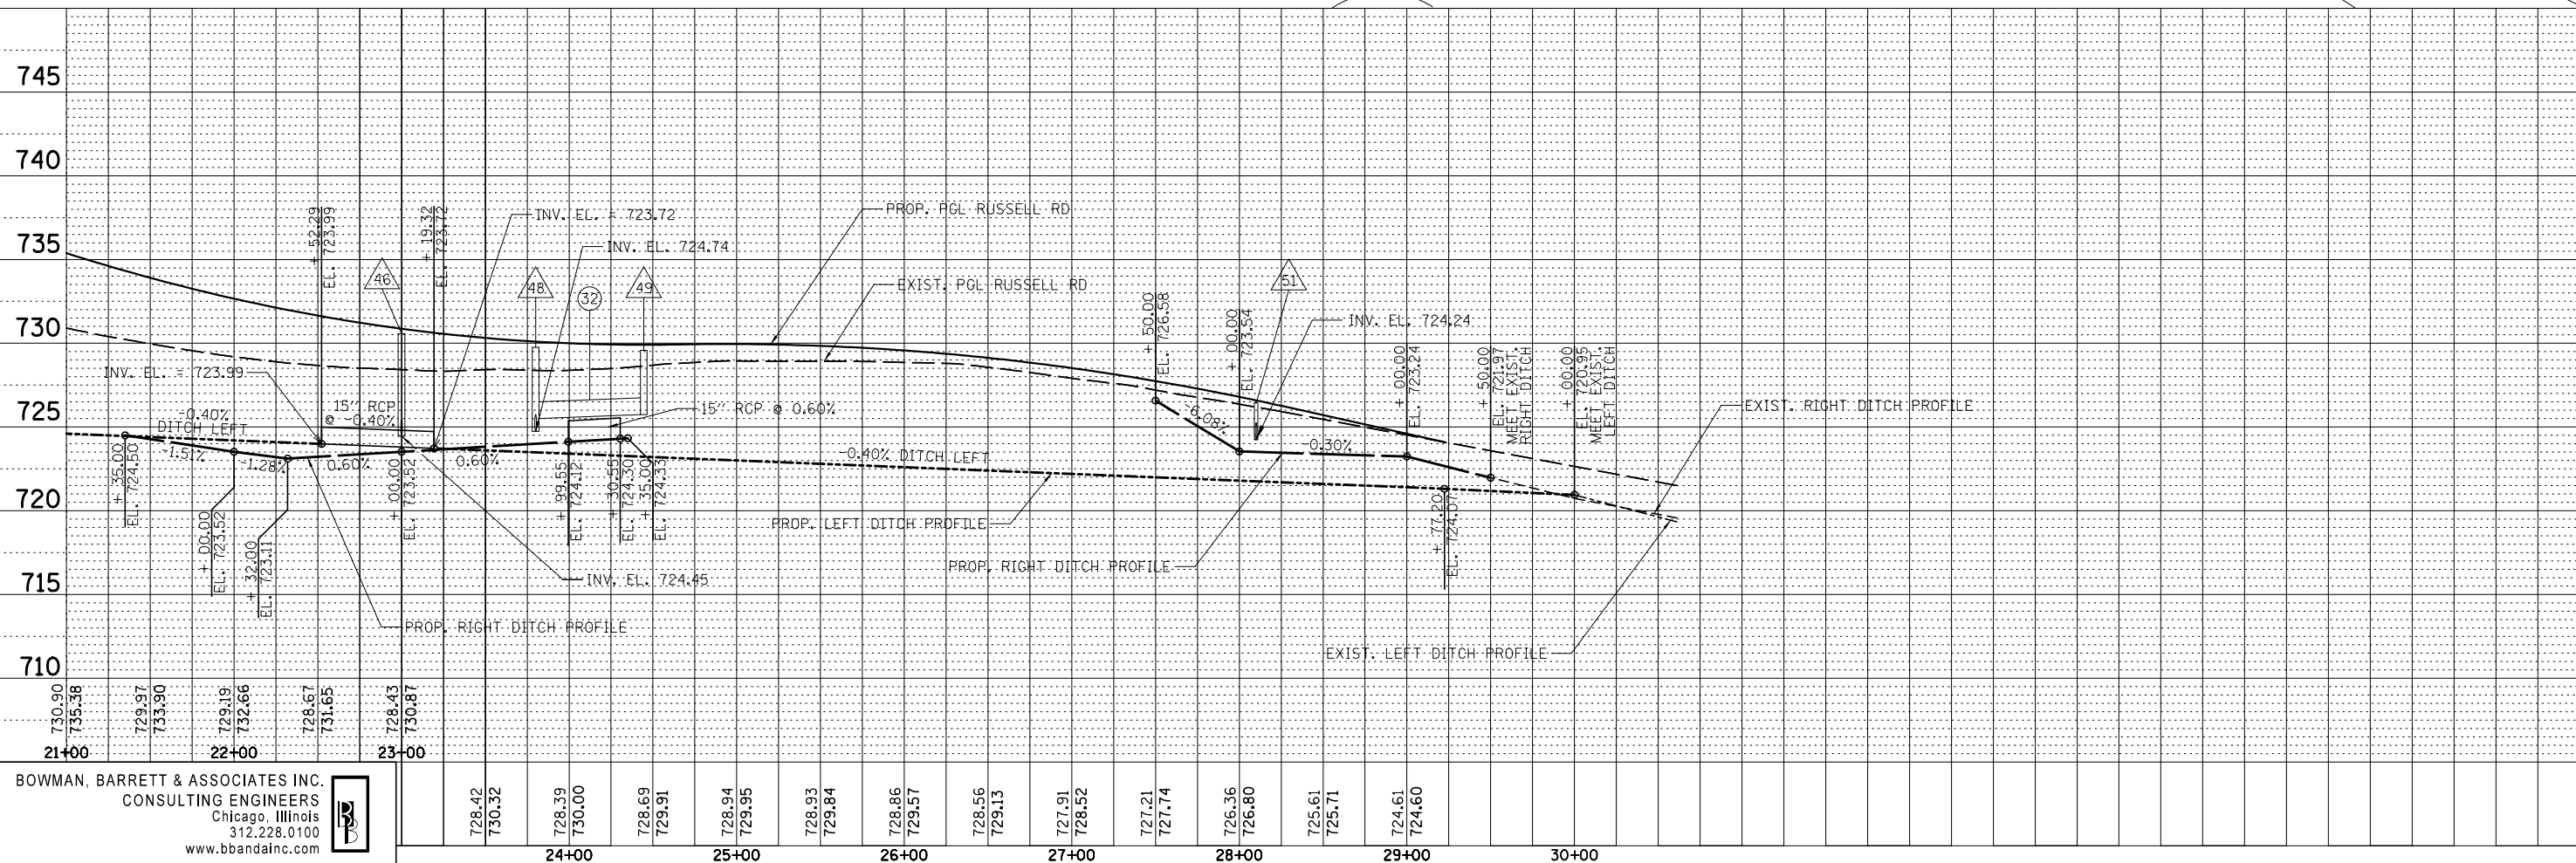

BOWMAN, BARRETT & ASSOCIATES INC.  
CONSULTING ENGINEERS  
Chicago, Illinois  
312.228.0100  
www.bbainc.com

FILE NAME = #FILES\*

USER NAME = default  
PLOT SCALE = #SCALE\*  
PLOT DATE = 3/7/2012

DESIGNED - JAM  
DRAWN - JAM  
CHECKED - RGR  
DATE - 03/09/2012

REVISED -  
REVISED -  
REVISED -  
REVISED -

STATE OF ILLINOIS  
DEPARTMENT OF TRANSPORTATION

PROPOSED DRAINAGE PLAN AND PROFILE  
FOR RUSSELL ROAD

SCALE: 1"=50' SHEET NO. 3 OF 3 SHEETS STA. 21+00.00 TO STA. 29+42.00

F.A. RTE.	SECTION	COUNTY	TOTAL SHEETS	SHEET NO.
94	49-1(HB & HB-1R)	LAKE	225	50
CONTRACT NO. 60L76			ILLINOIS FED. AID PROJECT	

S:\101\05\_CADD\60L76\_Russell\Drawings\Sheet\60L76-sh1-draw.dgn