



PLAN	SURVEYED	DATE
	PLOTTED	BY
	NOTE BOOK	
	NO.	
	CHECKED	
	FILE NAME	

PROFILE	SURVEYED	DATE
	PLOTTED	BY
	GRADES CHECKED	
	STRUCTURE	
	NOTATIONS	
	CHKD	

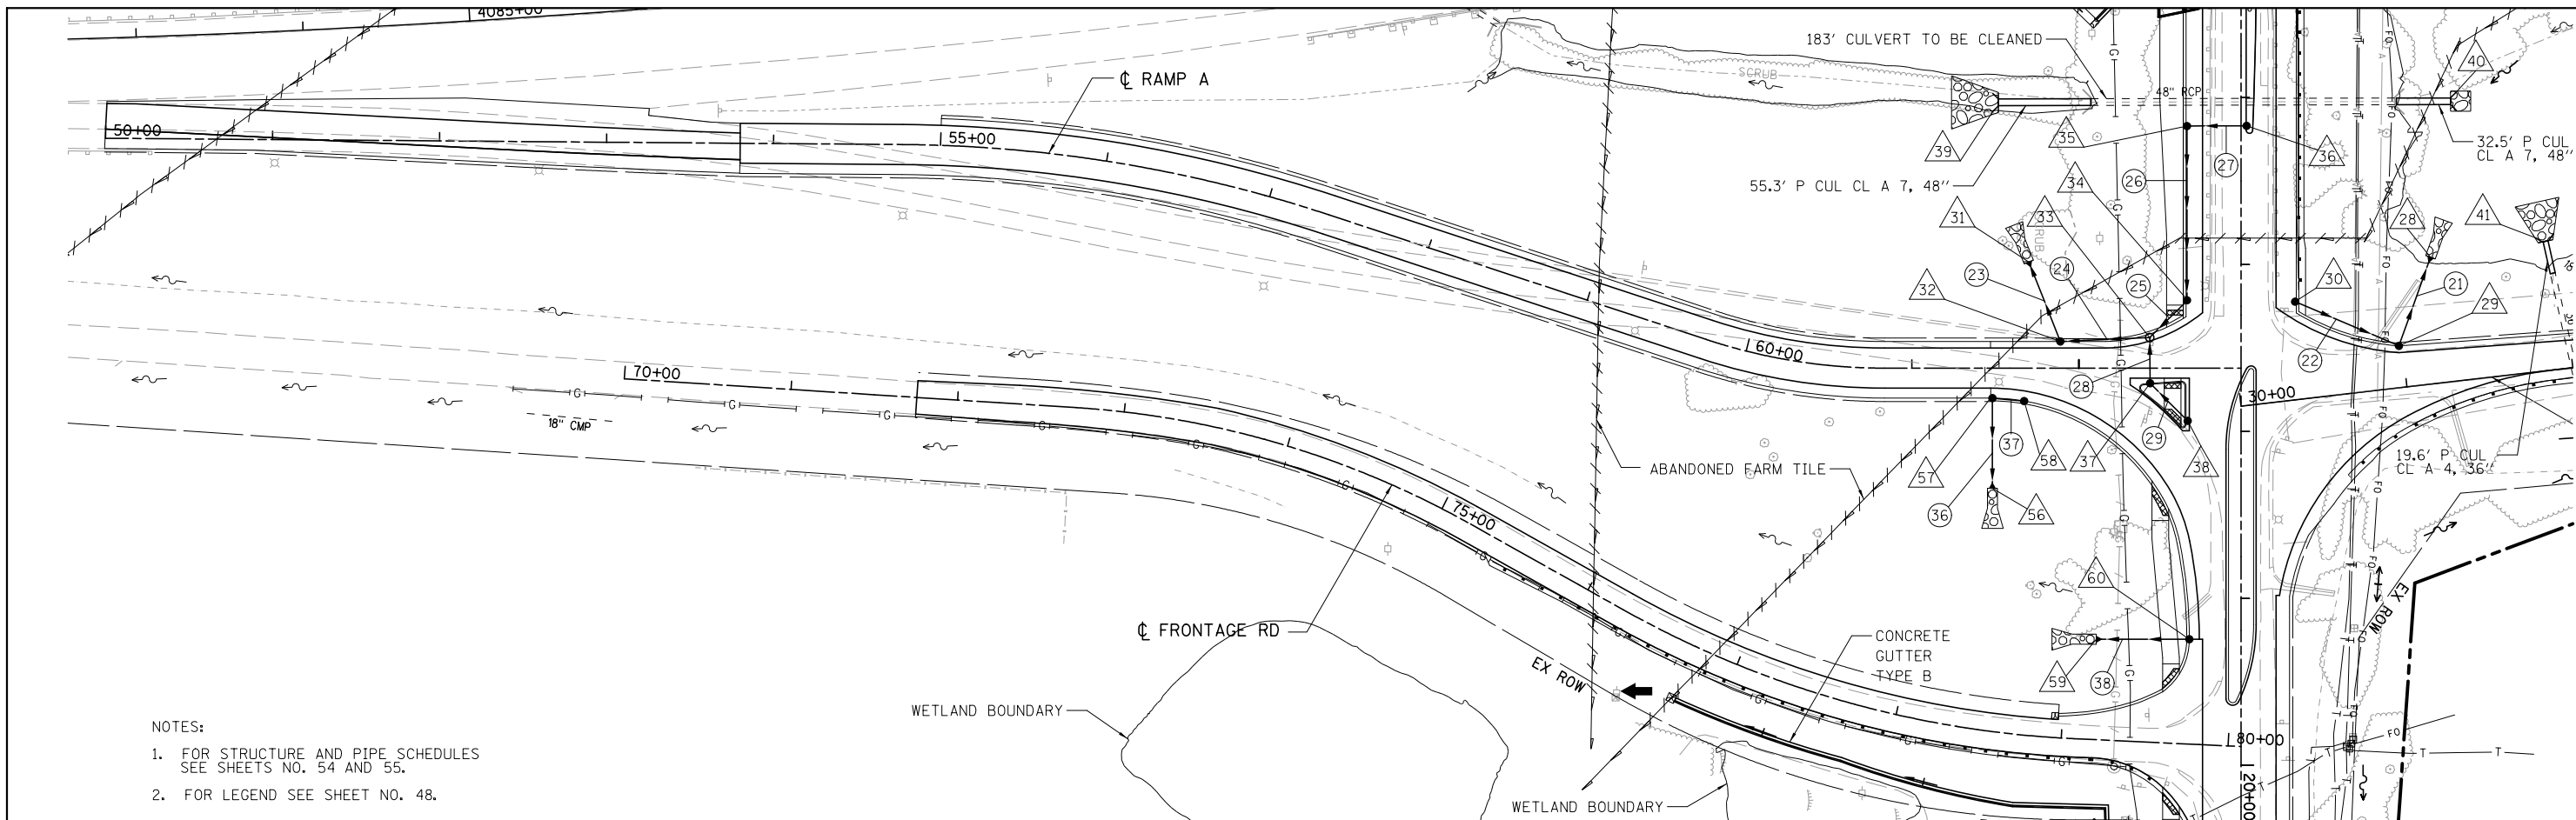

NOTES:
 1. FOR STRUCTURE AND PIPE SCHEDULES SEE SHEETS NO. 54 AND 55.
 2. FOR LEGEND SEE SHEET NO. 48.

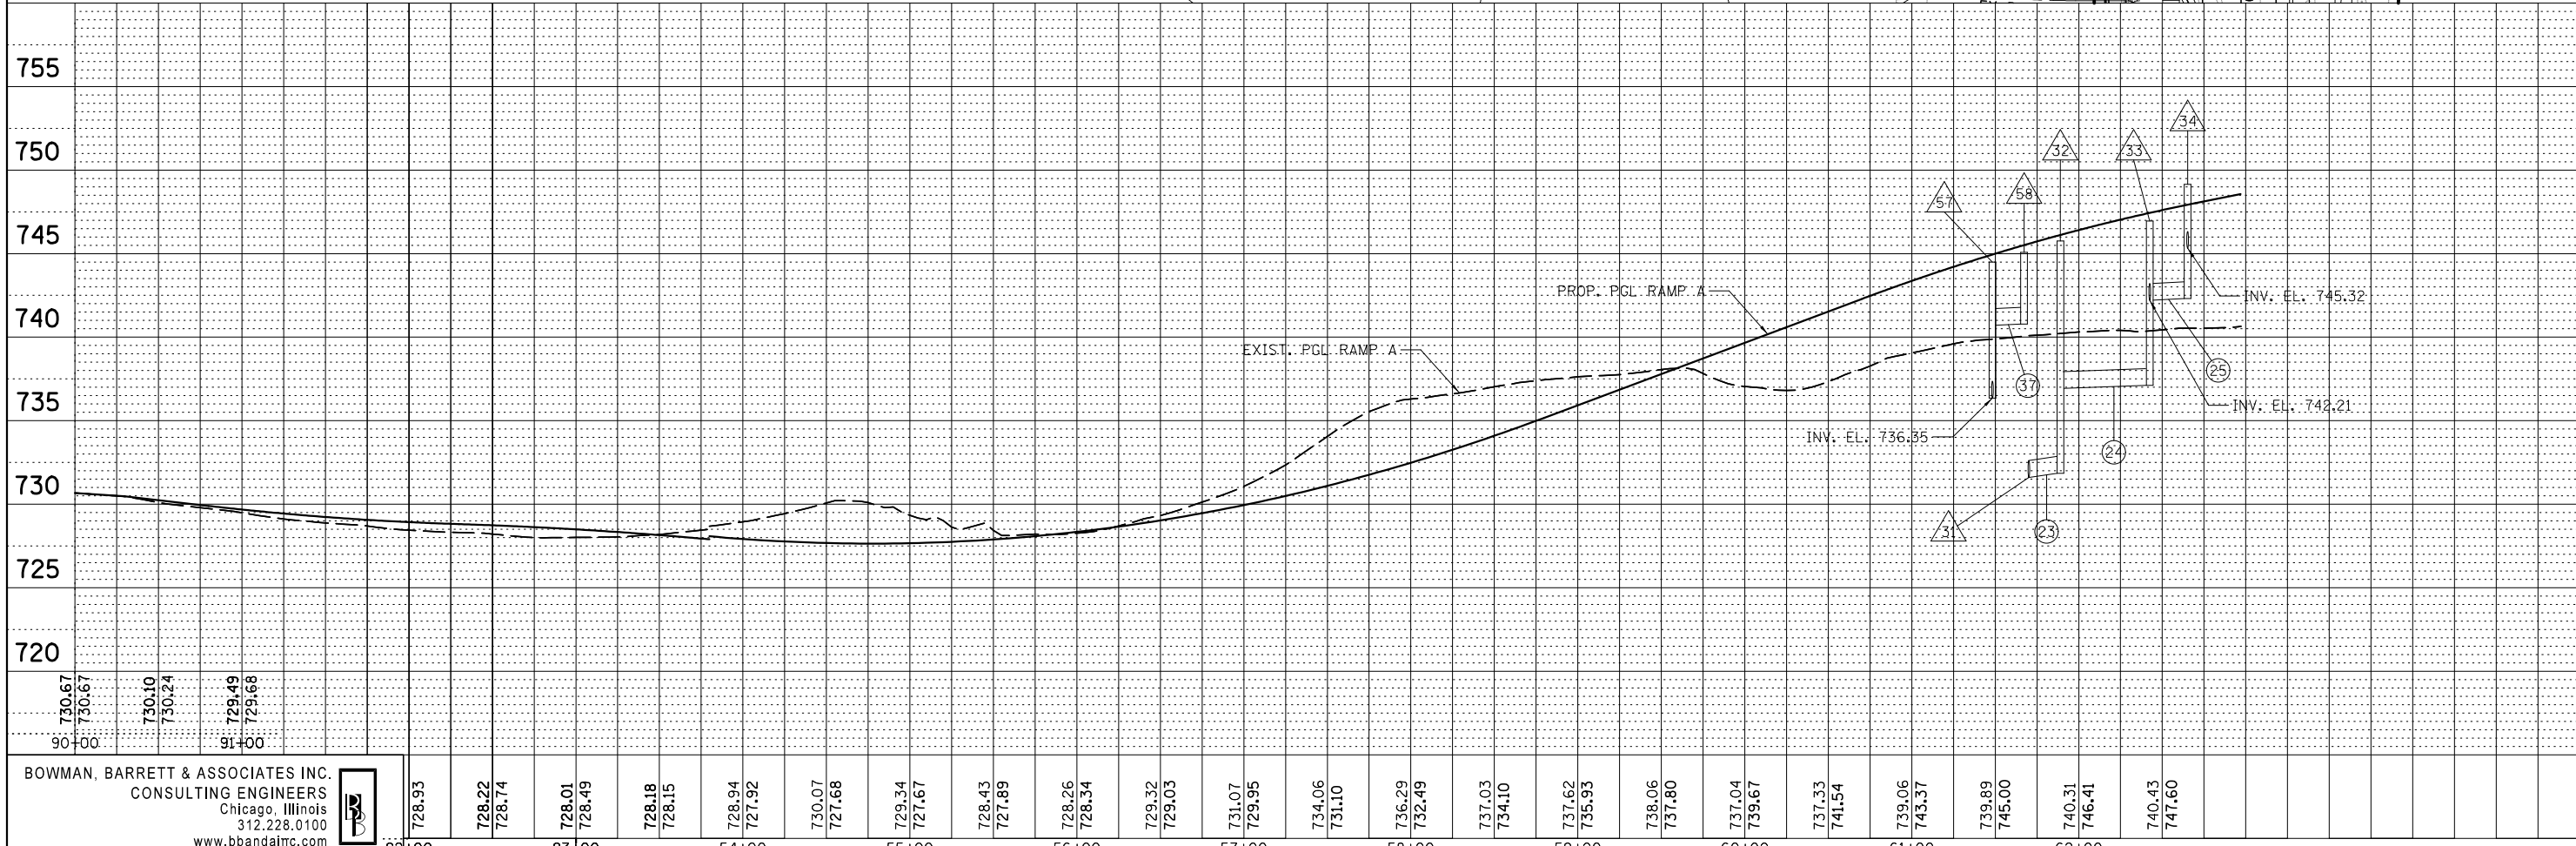

BOWMAN, BARRETT & ASSOCIATES INC.
 CONSULTING ENGINEERS
 Chicago, Illinois
 312.228.0100
 www.bbandaimc.com

FILE NAME = *FILES*	USER NAME = default	DESIGNED - JAM	REVISED -	STATE OF ILLINOIS DEPARTMENT OF TRANSPORTATION	PROPOSED DRAINAGE PLAN AND PROFILE FOR RAMP A			F.A. RTE. 94	SECTION 49-1(HB & HB-1R)	COUNTY LAKE	TOTAL SHEETS 225	SHEET NO. 51
	PLOT SCALE = *SCALE*	CHECKED - RGR	REVISED -		SCALE: 1"=50'	SHEET NO. 1 OF 1 SHEETS	STA. 0+00.00 TO STA. 6+00.00	CONTRACT NO. 60L76				
	PLOT DATE = 3/7/2012	DATE - 03/09/2012	REVISED -		ILLINOIS FED. AID PROJECT							
					S:\1101\05_CADD\60L76_Russell_Ramp\60L76_Sheets\0160L76-sh1-dr-ram94.dgn							