


MATCH LINE STA 115+00 @ 64W55S  
SEE SHEET 3

MATCH LINE STA 120+50 @ 64W55S  
SEE SHEET 10

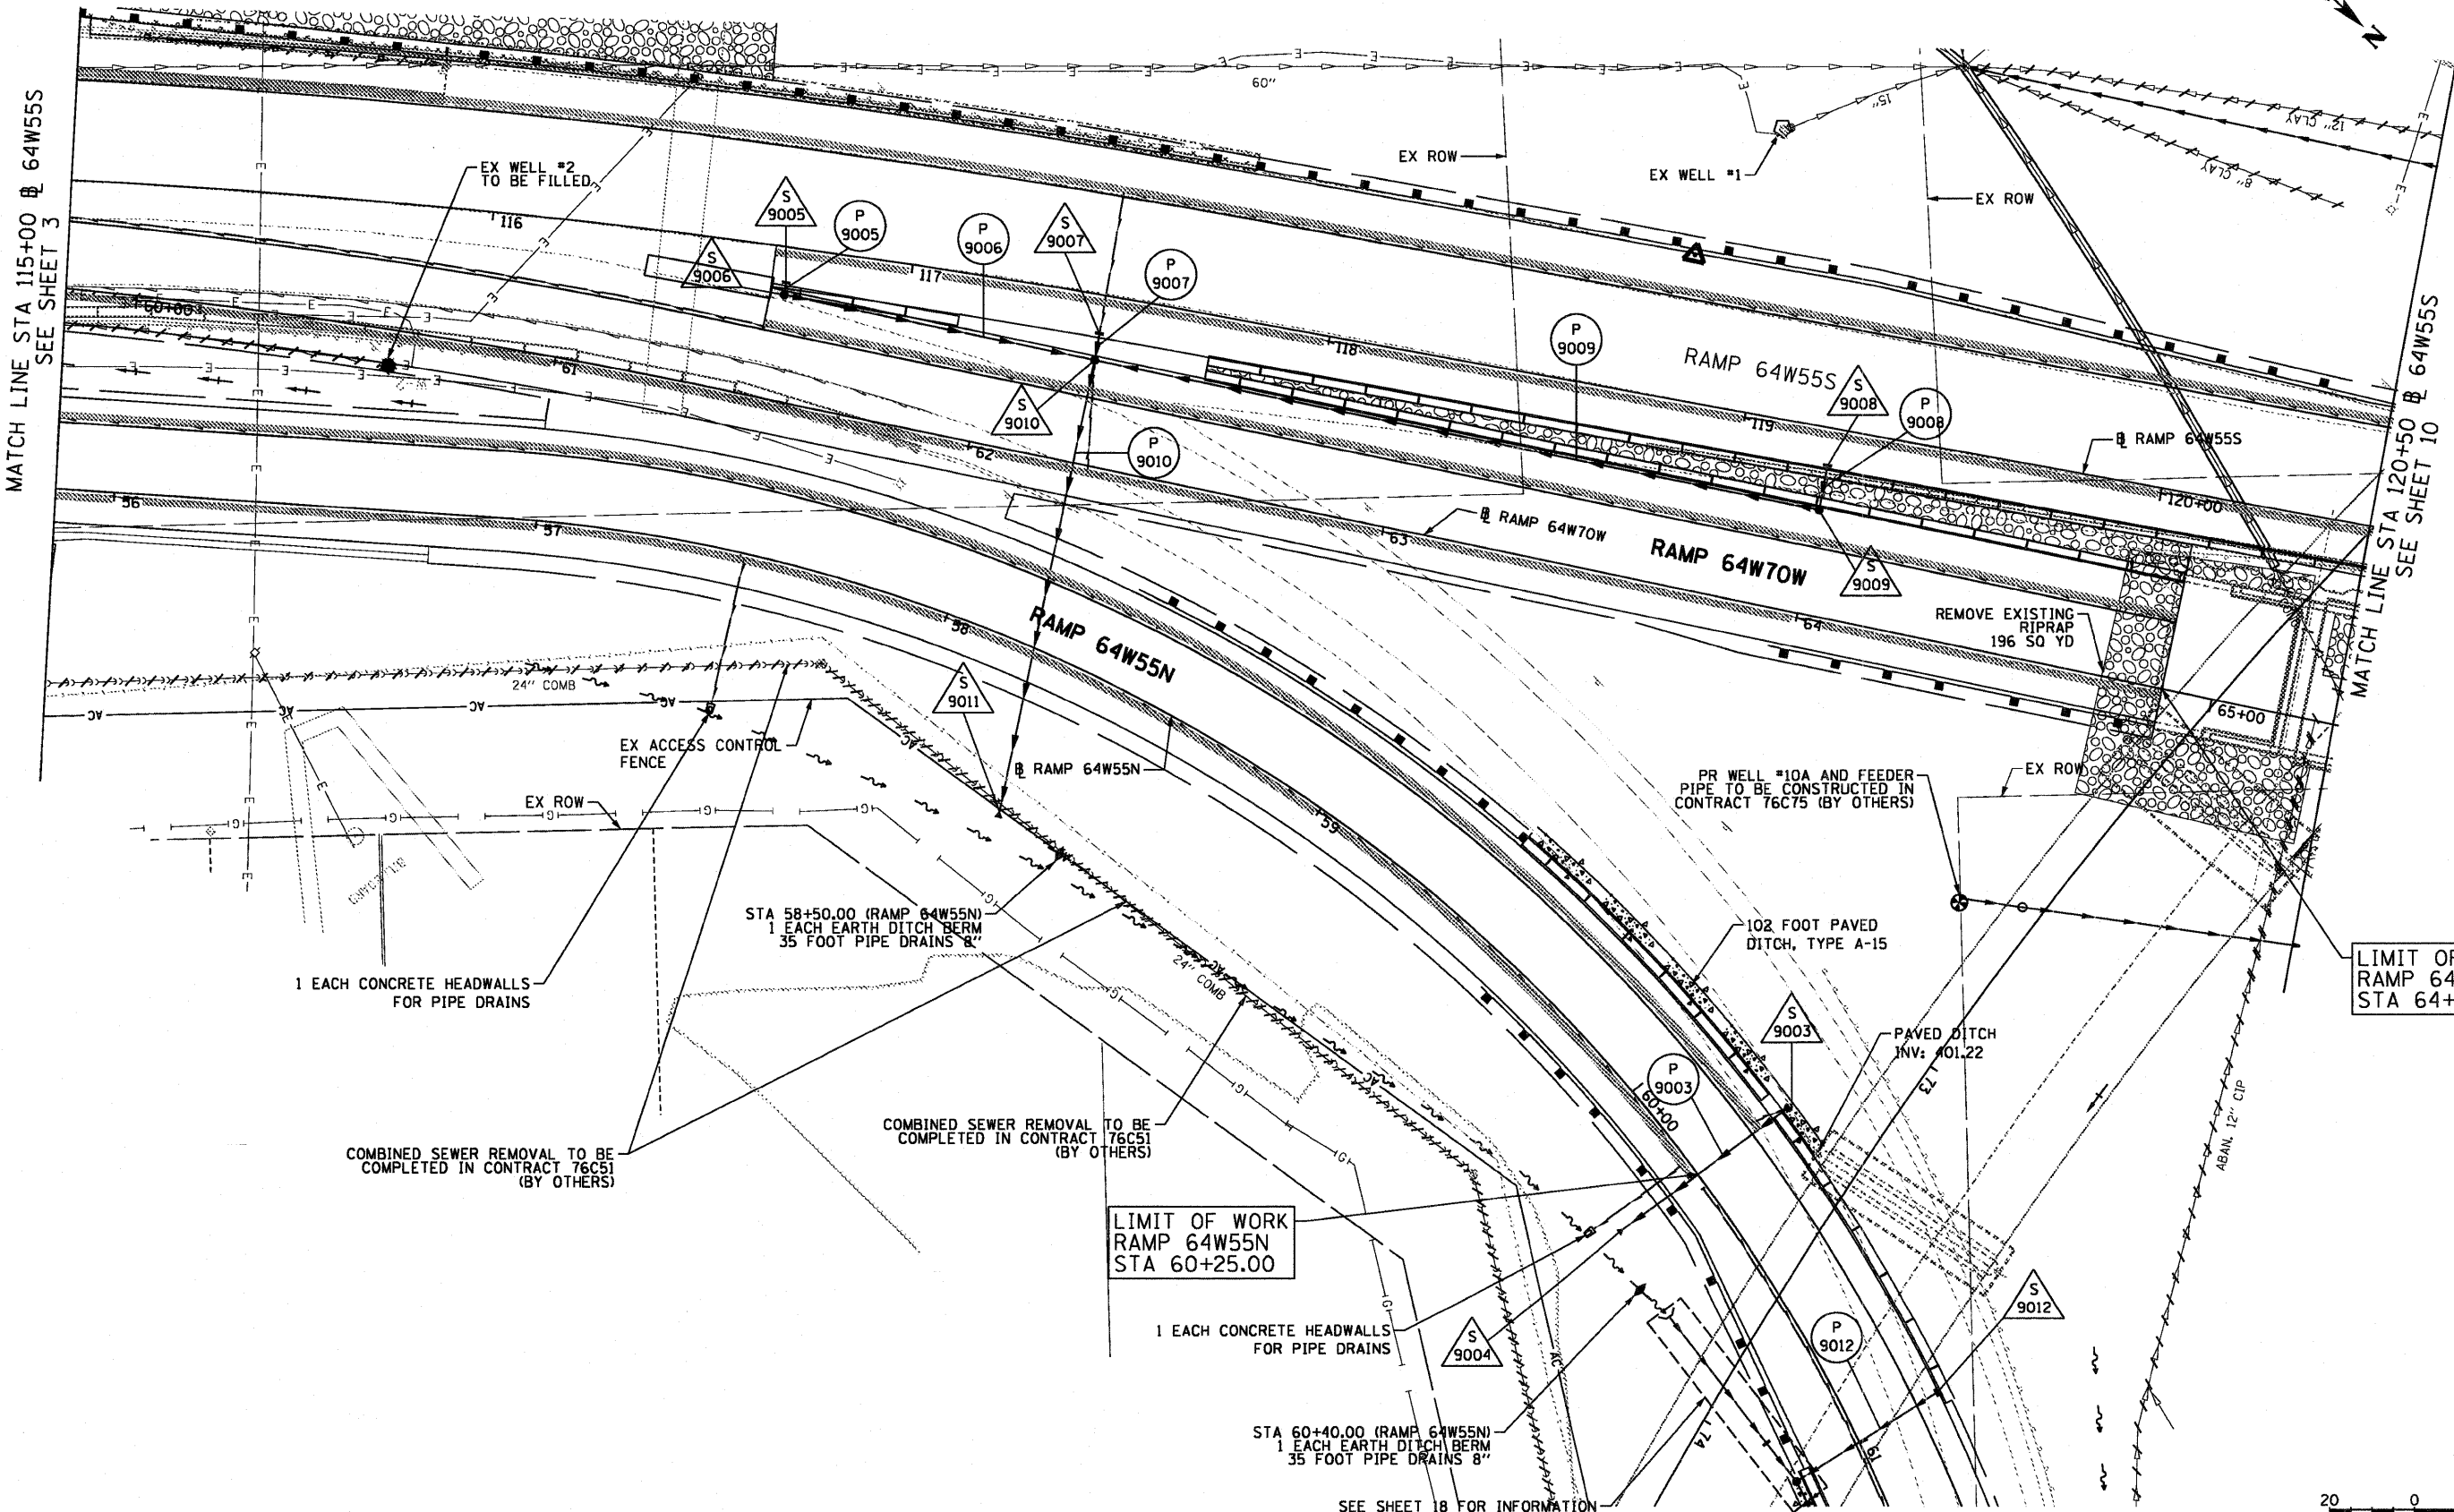

1 EACH CONCRETE HEADWALLS FOR PIPE DRAINS

COMBINED SEWER REMOVAL TO BE COMPLETED IN CONTRACT 76C51 (BY OTHERS)

STA 58+50.00 (RAMP 64W55N)  
1 EACH EARTH DITCH BERM  
35 FOOT PIPE DRAINS 8"

LIMIT OF WORK RAMP 64W55N STA 60+25.00

1 EACH CONCRETE HEADWALLS FOR PIPE DRAINS

STA 60+40.00 (RAMP 64W55N)  
1 EACH EARTH DITCH BERM  
35 FOOT PIPE DRAINS 8"

SEE SHEET 18 FOR INFORMATION ON DRAINAGE STRUCTURES

PR WELL #10A AND FEEDER PIPE TO BE CONSTRUCTED IN CONTRACT 76C75 (BY OTHERS)

102 FOOT PAVED DITCH, TYPE A-15

PAVED DITCH INV: 401.22

REMOVE EXISTING RIPRAP 196 SQ YD

LIMIT OF WORK RAMP 64W70W STA 64+87.96



FILE NAME = DBT1-76C52-shd-drain-09.dgn

USER NAME = searsb  
PLOT SCALE = 40.0000' / 1" =  
PLOT DATE = 1/25/2012

DESIGNED KLK  
DRAWN KLK  
CHECKED EEY  
DATE 1-20-12

REVISED -  
REVISED -  
REVISED -  
REVISED -

STATE OF ILLINOIS  
DEPARTMENT OF TRANSPORTATION

SCALE: 1" = 20'  
SHEET NO. 9 OF 21 SHEETS  
STA. 115+00 TO STA. 120+50

DRAINAGE AND UTILITY PLAN  
RAMP 64W55N & RAMP 64W70W

F.A.I. RTE.	SECTION	COUNTY	TOTAL SHEETS	SHEET NO.
82-1-RIA, 82-1-RIB)	ST. CLAIR	629	255	
64/998/70	CONTRACT NO. 76C52			
FED. ROAD DIST. NO.	ILLINOIS FED. AID PROJECT			