


F.A.I. RTE.	SECTION	COUNTY	TOTAL SHEETS	SHEET NO.
80	(32, 47-4)K	KENDALL/GRUNDY	243	138
STA.	TO STA.			
FED. ROAD DIST. NO.	ILLINOIS FED. AID PROJECT			

CONTRACT NO. 66294

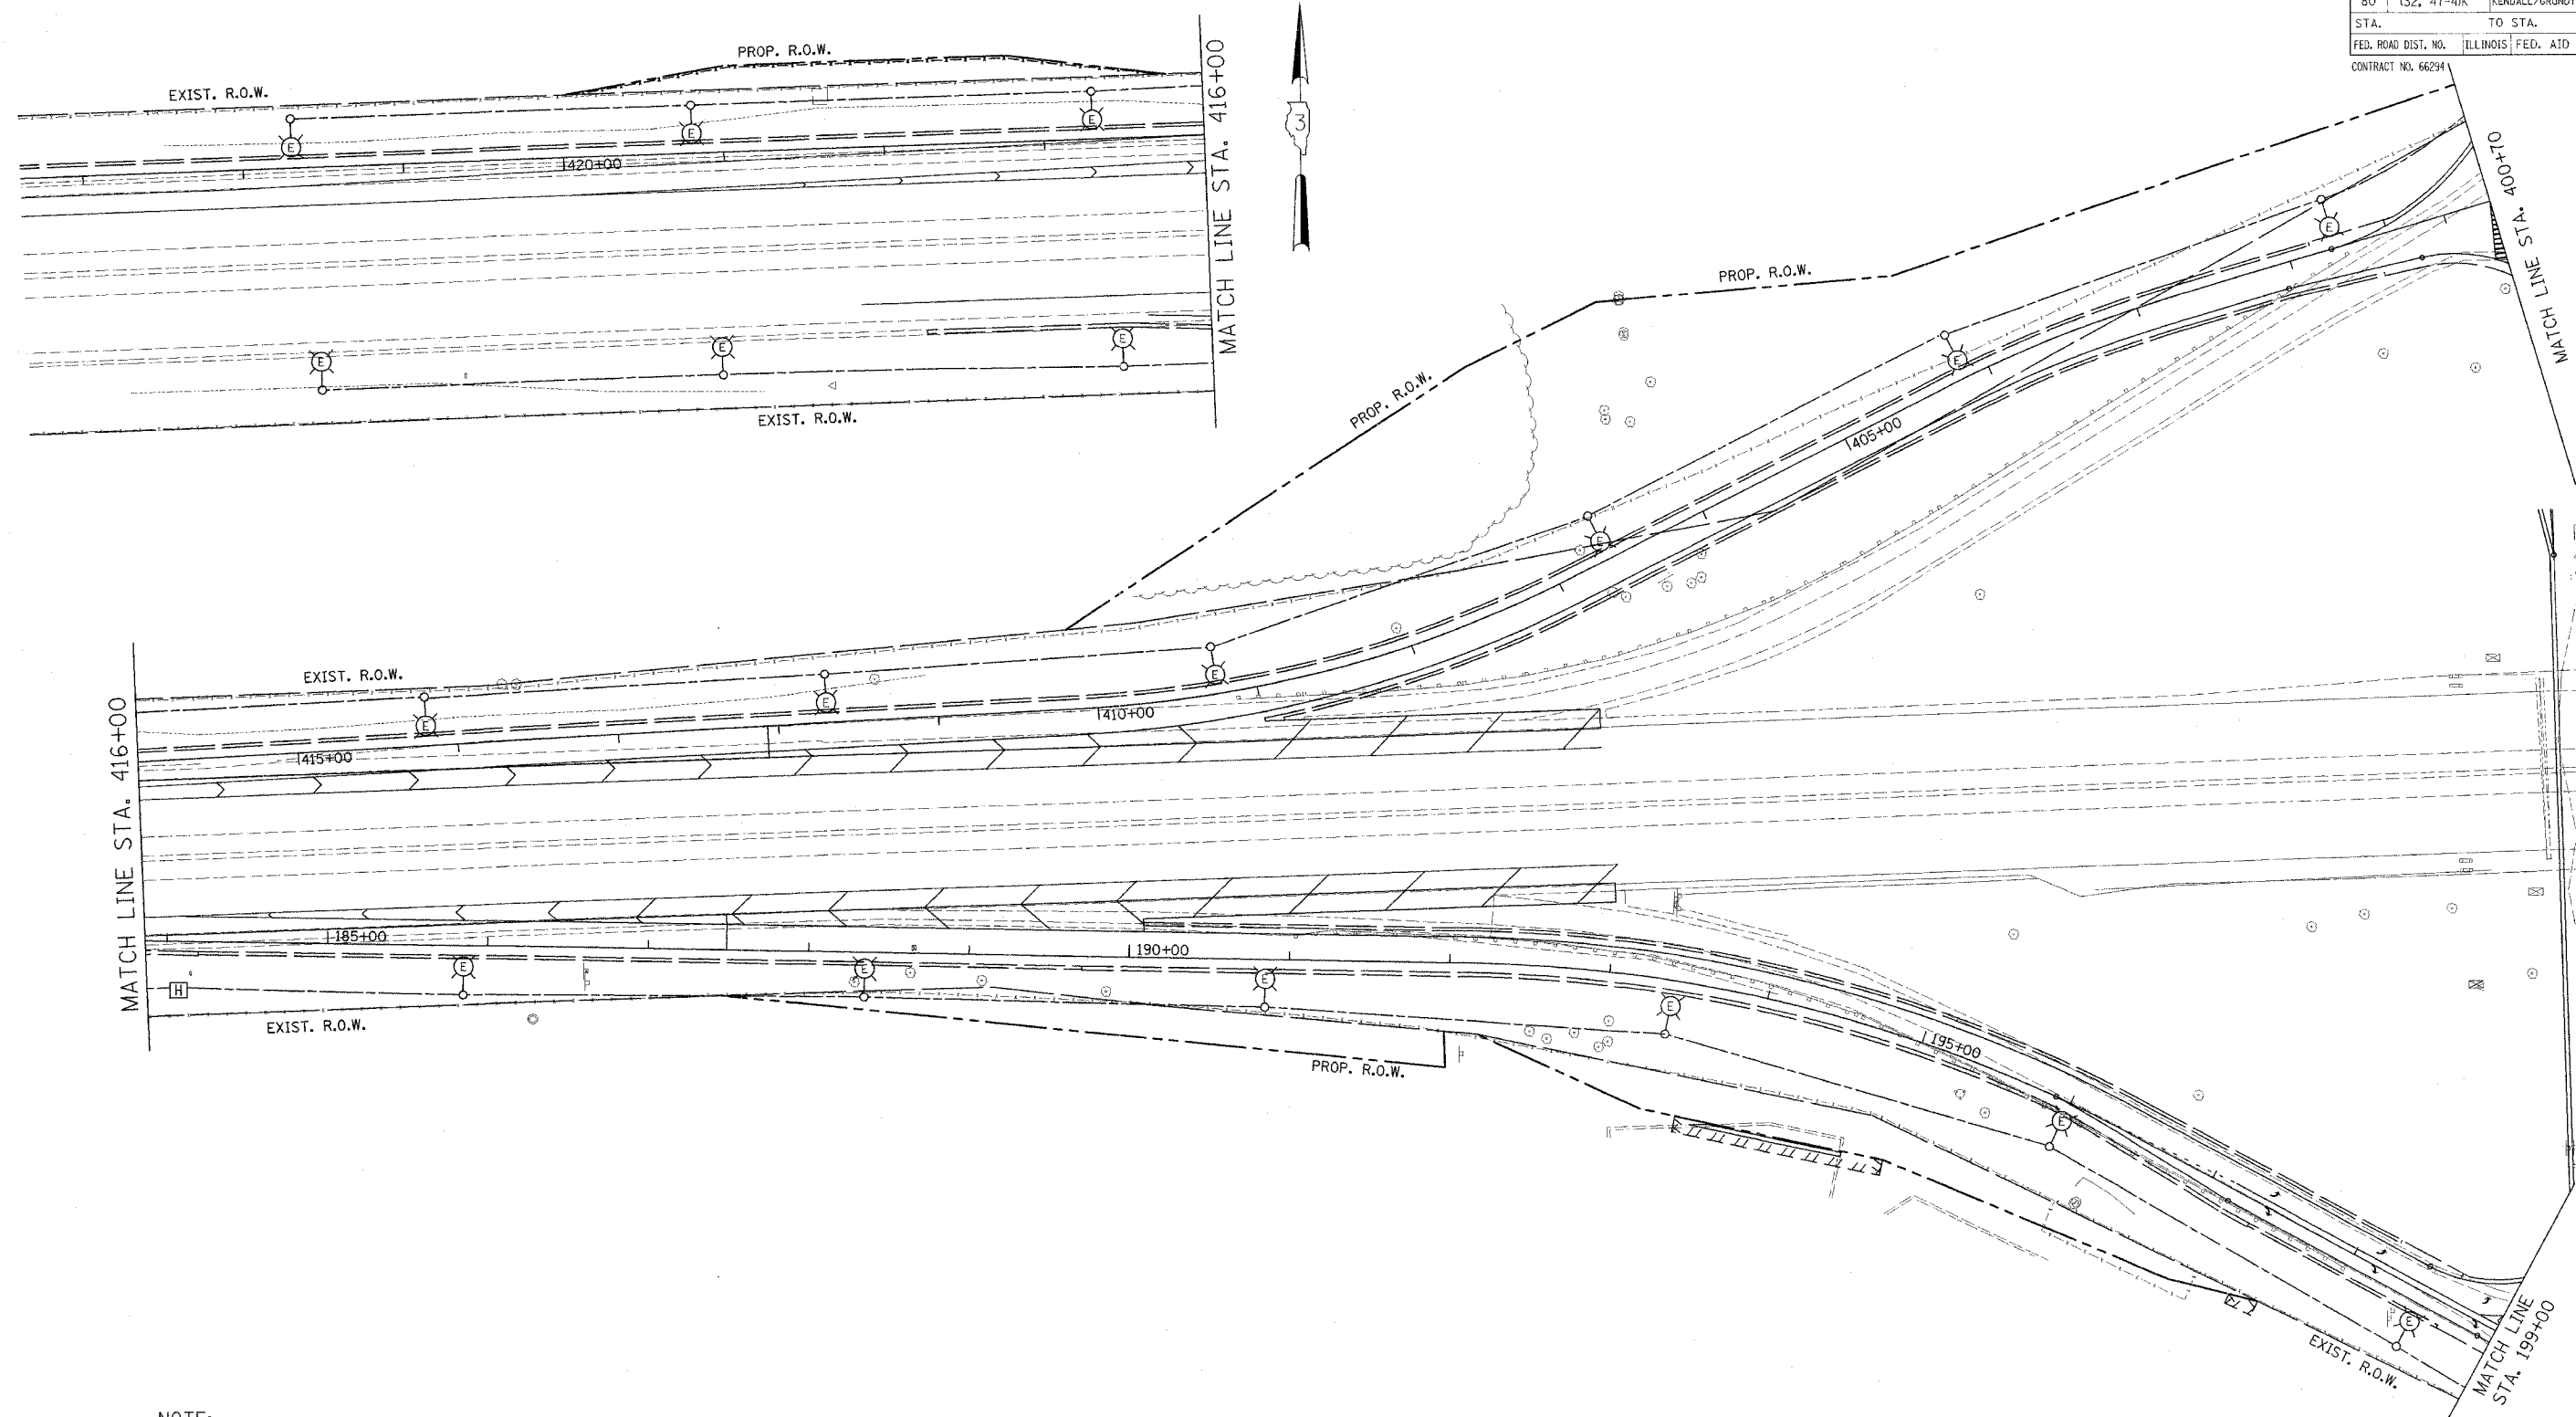

NOTE:
 ALL EXISTING LIGHT POLES SHOWN ON THIS DRAWING WERE INSTALLED IN PRIOR CONSTRUCTION STAGES. SEE THE OTHER TEMPORARY LIGHTING PLAN SHEETS FOR MORE INFORMATION.

REVISIONS	
NAME	DATE

ILLINOIS DEPARTMENT OF TRANSPORTATION
 FAI ROUTE 80 (I-80 AT MINOOKA INTERCHANGE)
 TEMPORARY LIGHTING
 RAMP "A" AND RAMP "C"
 SHEET 1 OF 2
 STAGE 1B, STAGE 2, STAGE 2B, AND STAGE 3
 SCALE: 1:50
 DATE: 2/10/06
 DRAWN BY: KGP/MAE
 CHECKED BY: MAE/PKG

GO GANDHI AND ASSOCIATES, INC.
 ENGINEERS AND PLANNERS
 6035 N. NORTHWEST HIGHWAY
 SUITE 300
 CHICAGO, ILLINOIS 60631 TEL: (773) 774-5910

PATRICK
 ENGINEERING INC.
 LISLE, ILLINOIS