


F.A.I. RTE.	SECTION	COUNTY	TOTAL SHEETS	SHEET NO.
74	(90-11)R-2; 90(13,14,14-1)R-1	TAZEWELL	1366	261
STA. 153+000		TO STA. 153+300		
FED. ROAD DIST. NO. 4		ILLINOIS FED. AID PROJECT		

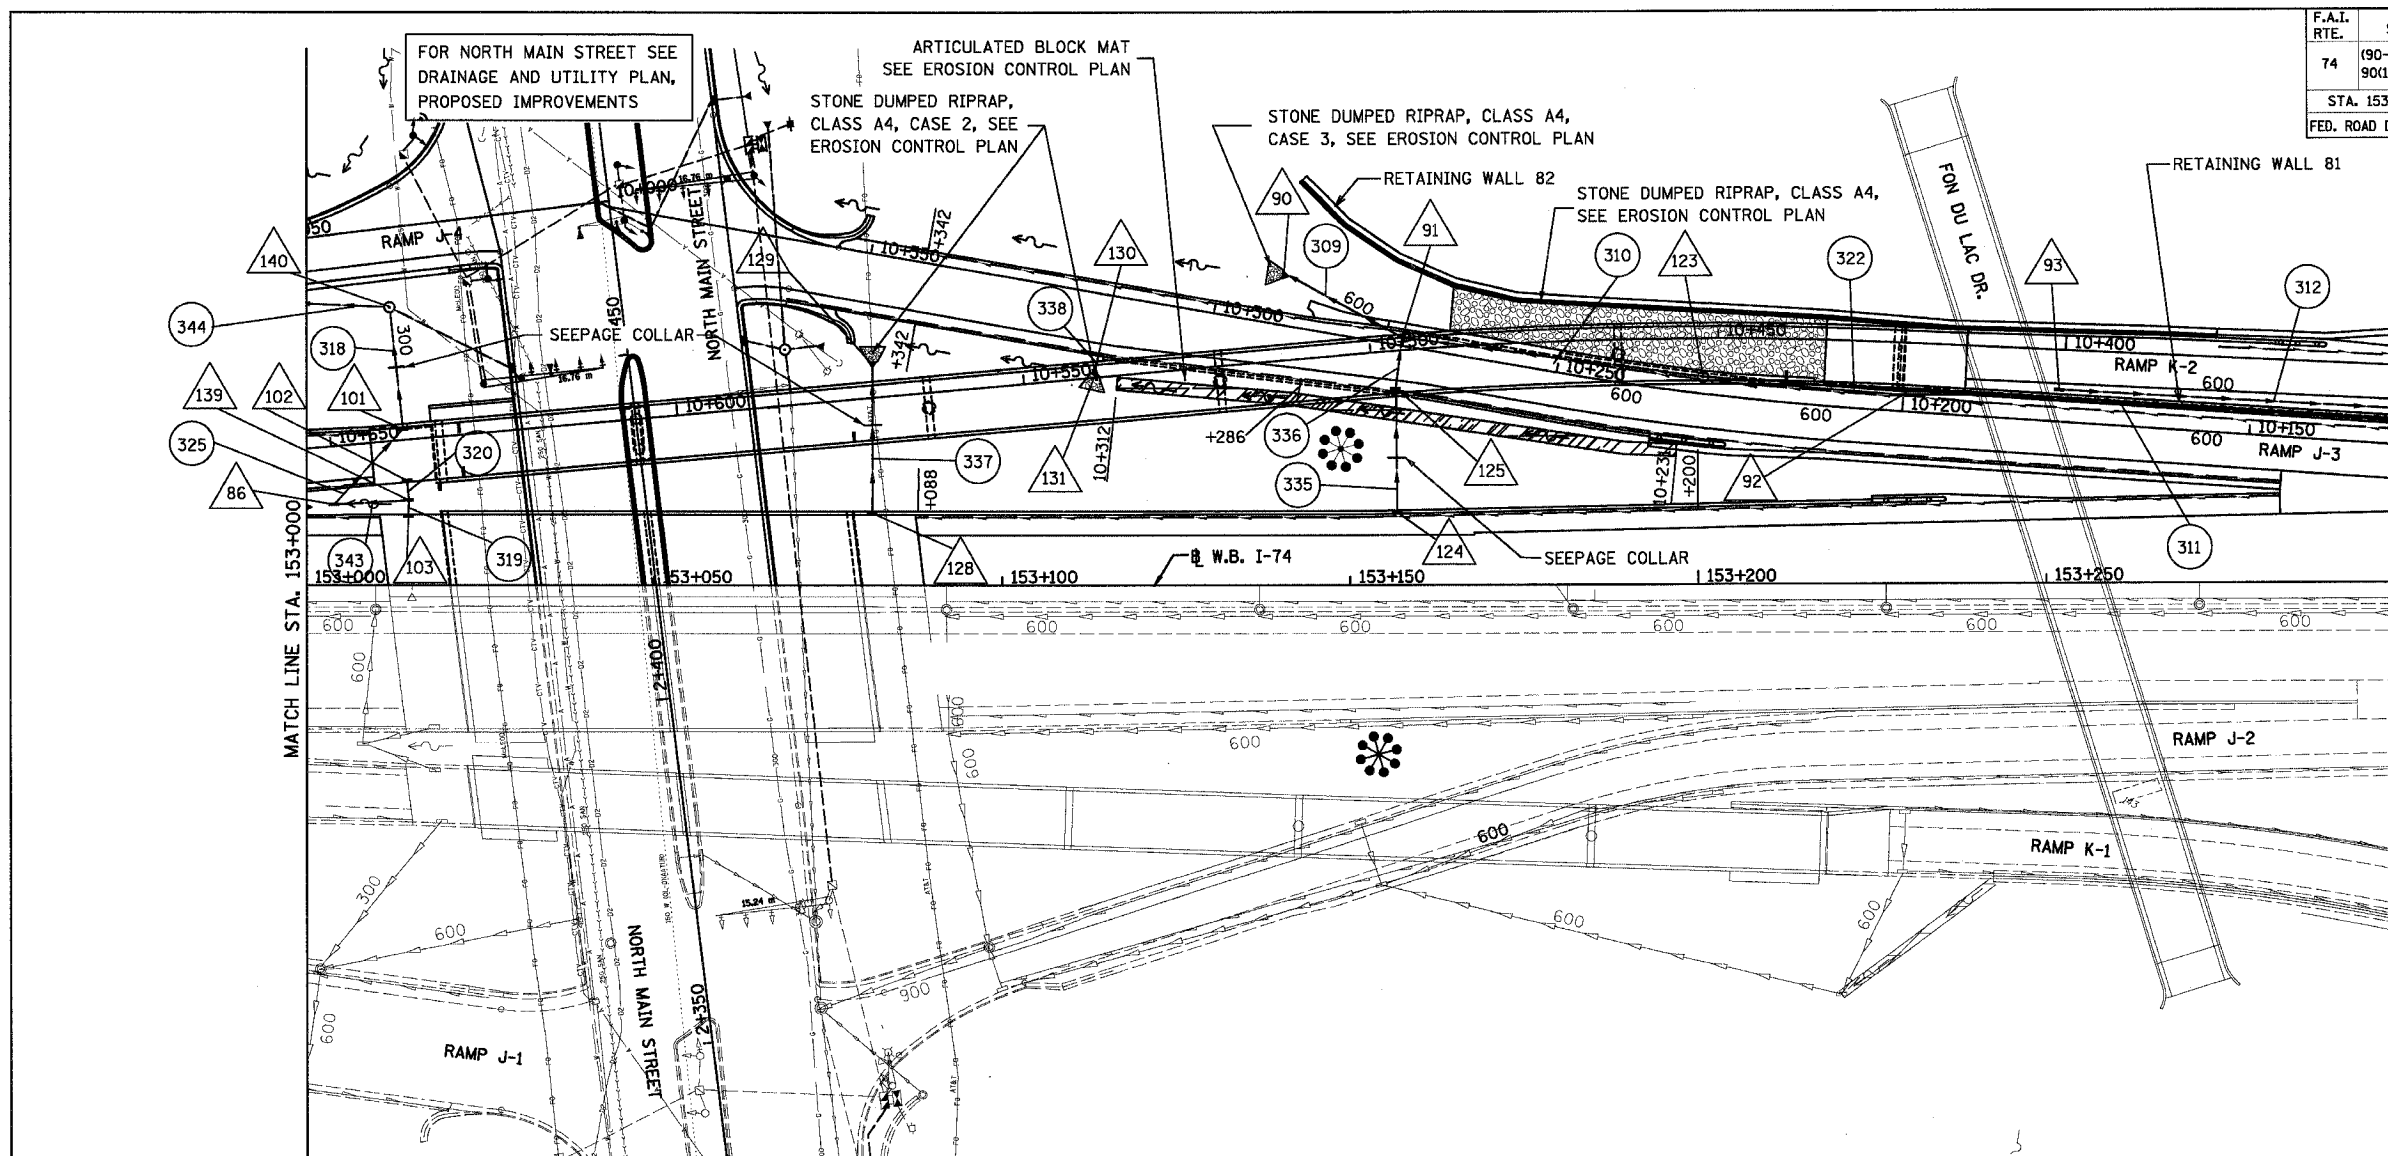

FOR NORTH MAIN STREET SEE DRAINAGE AND UTILITY PLAN, PROPOSED IMPROVEMENTS

ARTICULATED BLOCK MAT SEE EROSION CONTROL PLAN
STONE DUMPED RIPRAP, CLASS A4, CASE 2, SEE EROSION CONTROL PLAN

STONE DUMPED RIPRAP, CLASS A4, CASE 3, SEE EROSION CONTROL PLAN

STONE DUMPED RIPRAP, CLASS A4, SEE EROSION CONTROL PLAN

MATCH LINE STA. 153+000

MATCH LINE STA. 153+300

FOR NORTH MAIN STREET SEE DRAINAGE AND UTILITY PLAN, PROPOSED IMPROVEMENTS

EXISTING	PROPOSED	LEGEND
○	○	CATCH BASIN
□	—	INLET
⊙	⊙	MANHOLE
△	▲	CULVERT END SECTION
))	HEADWALL
*	*	SAG
↑	↑	SUMMIT
→	→	DITCH
~	~	DITCH FLOW
—	—	PIPE UNDERDRAIN
—	—	STORM SEWER
- - -	—	CULVERT LINE
	▨	ARTICULATED BLOCK MAT
	①	STRUCTURE NUMBER
	①	STORM SEWER PIPE NUMBER
	+638	UNDERDRAIN OUTLET
	*	HIGH MAST LIGHTING (SEE LIGHTING PLANS)

NOTE: FOR UNDERDRAIN INFORMATION SEE SCHEDULE OF QUANTITIES

PROPOSED DRAINAGE SHEET 3 OF 5

REVISIONS	
NAME	DATE

ILLINOIS DEPARTMENT OF TRANSPORTATION
F.A.I. ROUTE 74 (I-74)
DRAINAGE AND UTILITY PLAN
STA. 153+000 TO STA. 153+300 W.B. I-74
DRAWN BY RTG
CHECKED BY RTG
DATE 12-20-2004

