



F.A.I. RTE.	SECTION	COUNTY	TOTAL SHEETS	SHEET NO.
74		TAZEWELL	1366	271
STA. 2+300.000		TO STA. 2+450.000		
FED. ROAD DIST. NO. 4 ILLINOIS FED. AID PROJECT				
• (90-11R-2)9013,14,14-1R-1				

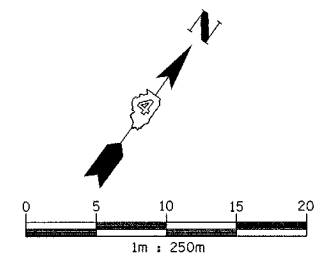

**EXISTING DRAINAGE AND UTILITY LEGEND**

- A — OVERHEAD ELECTRIC
- S — STORM SEWER
- SS — SANITARY SEWER
- - - - CULVERT PIPE
- T — TRENCH DRAIN
- U — UNDERGROUND TELEPHONE
- FO — UNDERGROUND FIBER OPTIC
- D — UNDERGROUND COMMUNICATIONS DUCT
- W — UNDERGROUND WATER MAIN
- G — UNDERGROUND GAS MAIN
- H — HEADWALL
- I — INLET
- C — CONC. END SECTION
- M — UTILITY MAN-HOLE
- E — ELECTRIC/TELEPHONE SPLICE BOX
- T — TRAFFIC SIGNAL HANDHOLE
- P — POWER POLE
- T — TELEPHONE POLE
- L — HIGH MAST LIGHT
- B — ABOVE GROUND TRANSFORMER
- V — WATER VALVE OR UTIL. BOX
- F — FIRE HYDRANT
- S — RAILROAD SWITCH
- X — RAILROAD SIGNAL
- J — FIBER OPTIC JUNCTION BOX

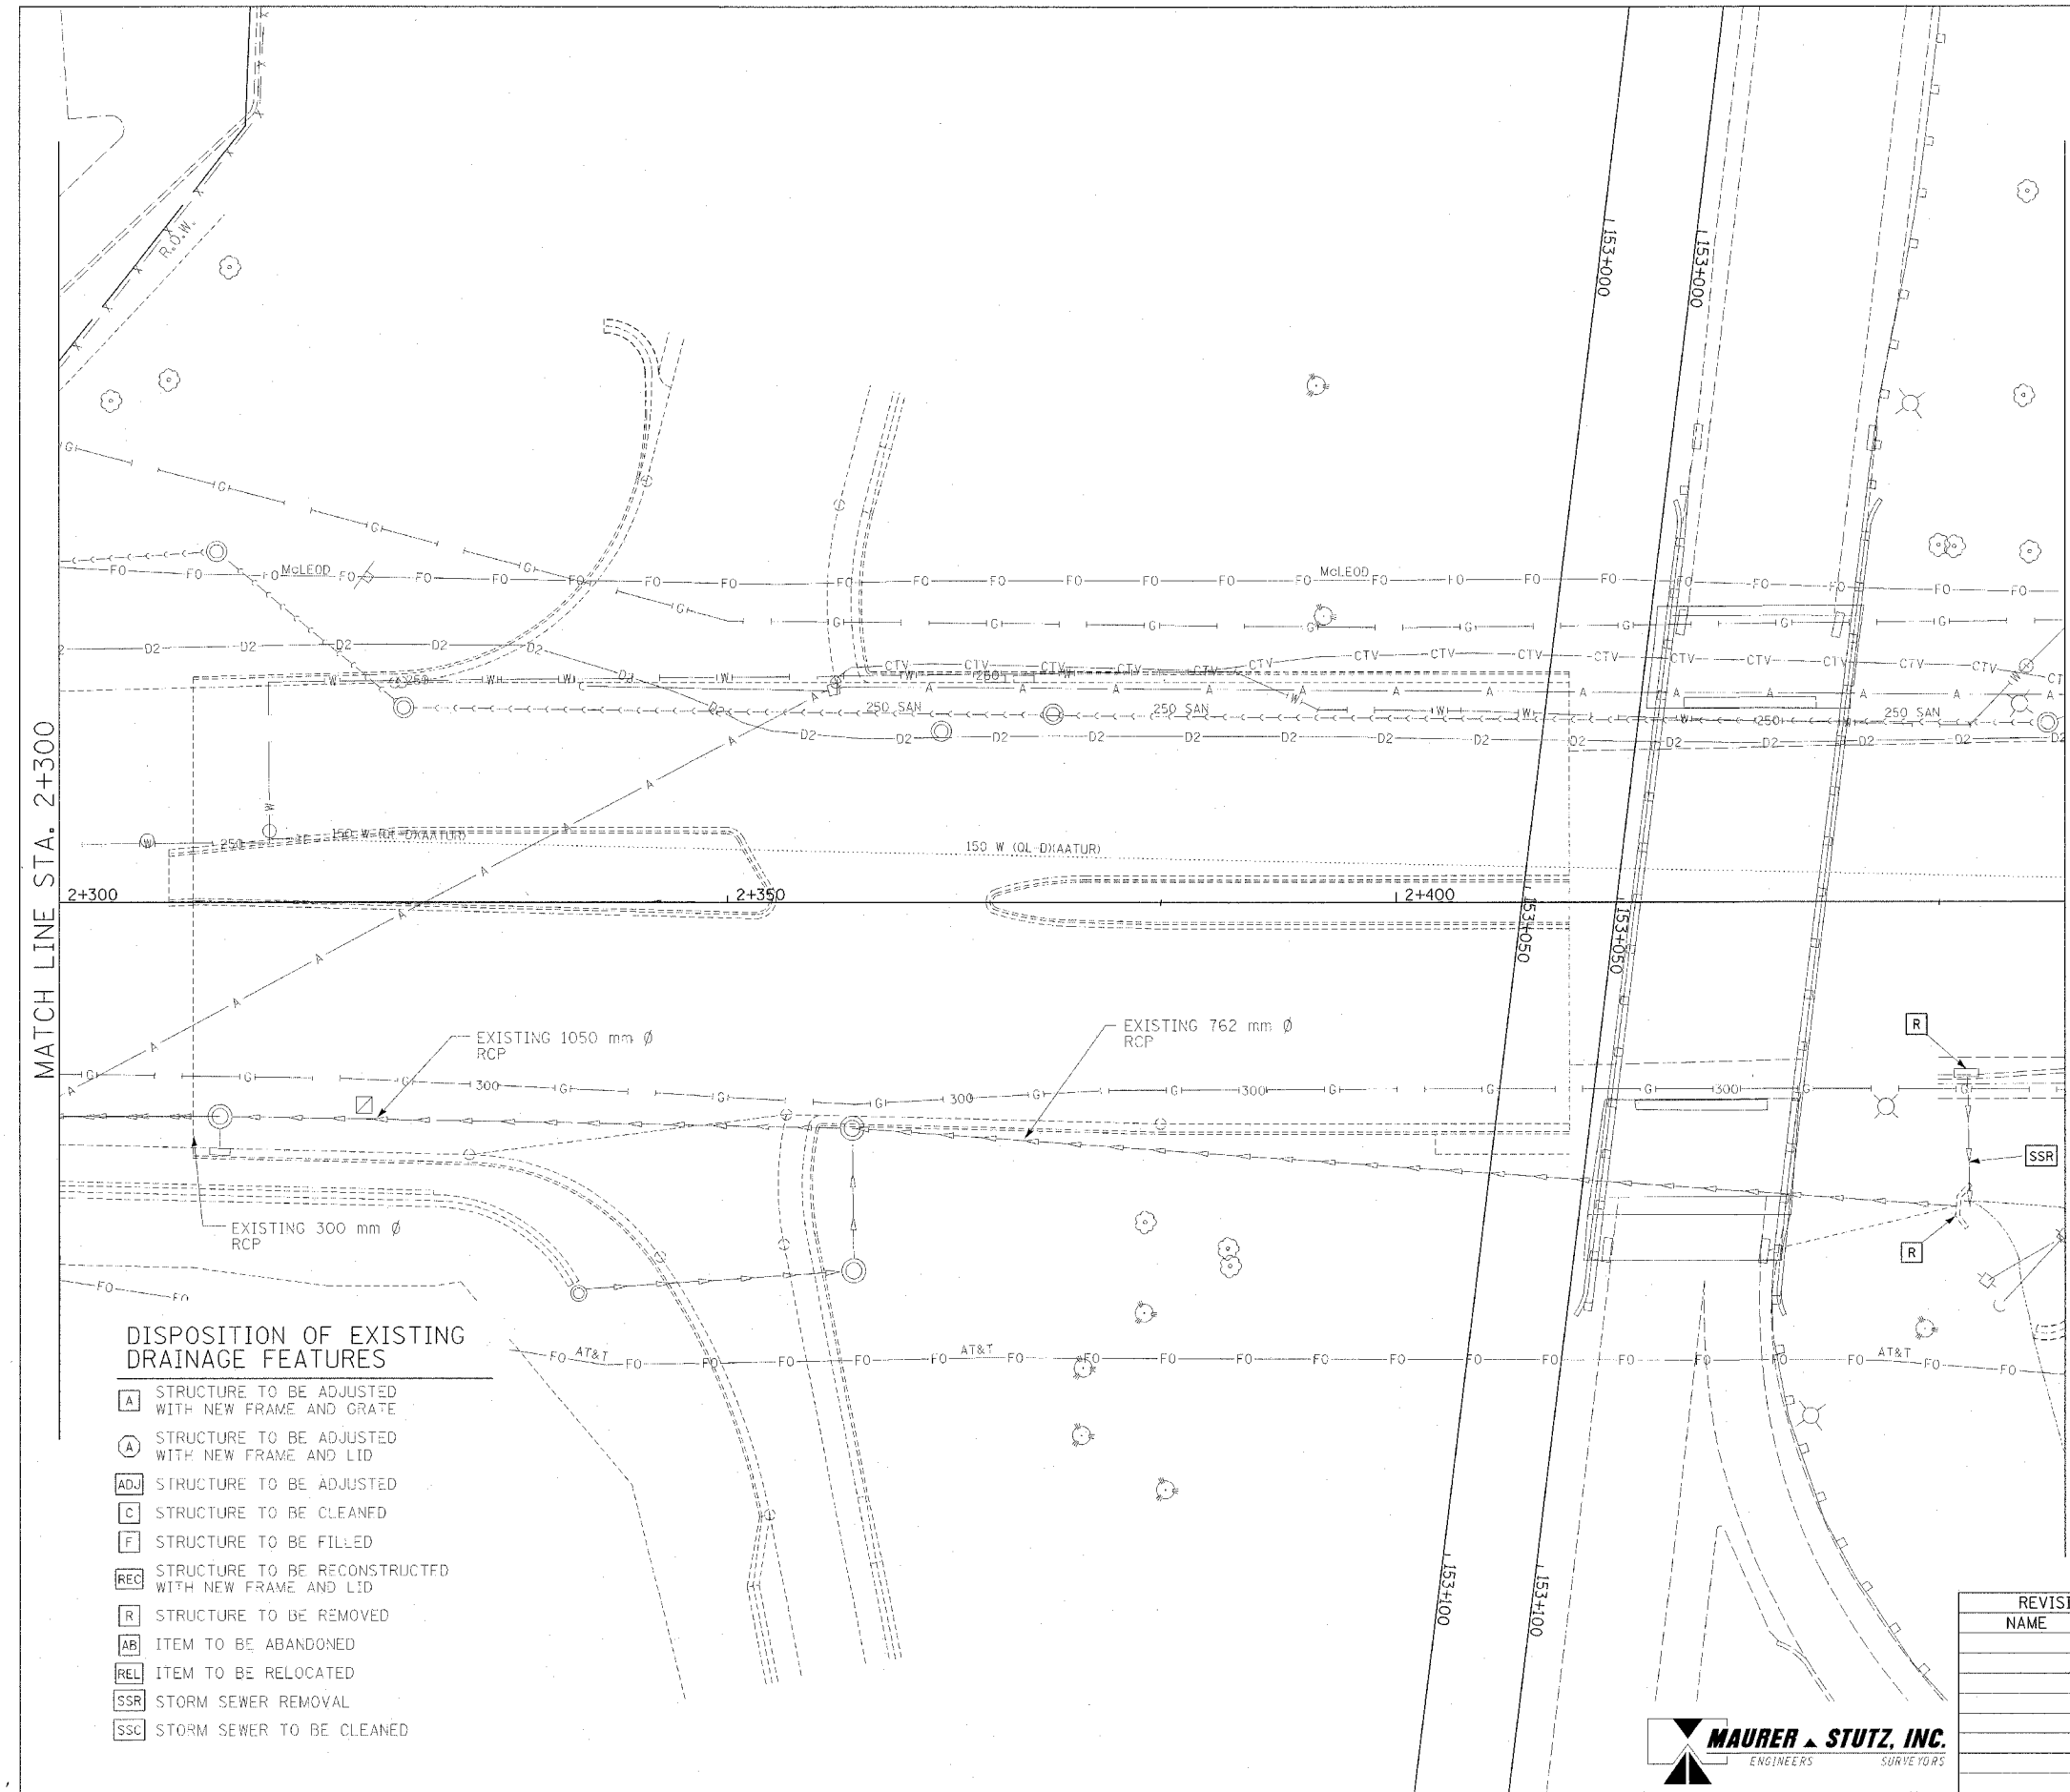

**DISPOSITION OF EXISTING DRAINAGE FEATURES**

- [A] STRUCTURE TO BE ADJUSTED WITH NEW FRAME AND GRATE
- [A] STRUCTURE TO BE ADJUSTED WITH NEW FRAME AND LID
- [ADJ] STRUCTURE TO BE ADJUSTED
- [C] STRUCTURE TO BE CLEANED
- [F] STRUCTURE TO BE FILLED
- [REC] STRUCTURE TO BE RECONSTRUCTED WITH NEW FRAME AND LID
- [R] STRUCTURE TO BE REMOVED
- [AB] ITEM TO BE ABANDONED
- [REL] ITEM TO BE RELOCATED
- [SSR] STORM SEWER REMOVAL
- [SSC] STORM SEWER TO BE CLEANED

**EXISTING CONDITIONS**

ILLINOIS DEPARTMENT OF TRANSPORTATION  
**DRAINAGE AND UTILITY PLAN**  
**MAIN STREET**  
 STA 2+300 TO 2+450

DATE 12/20/04  
 DRAWN BY JAM  
 CHECKED BY MJS

REVISIONS	
NAME	DATE

