



F.A.I. RTE.	SECTION	COUNTY	TOTAL SHEETS	SHEET NO.
74		TAZEWELL	1366	273
STA. 2+450.000 TO STA. 2+600.000				
FED. ROAD DIST. NO. 4 ILLINOIS FED. AID PROJECT				

• (90-111R-2,90113,14,14-1R-1

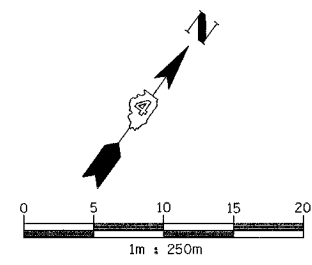

EXISTING DRAINAGE AND UTILITY LEGEND

- OVERHEAD ELECTRIC
- STORM SEWER
- SANITARY SEWER
- CULVERT PIPE
- TRENCH DRAIN
- UNDERGROUND TELEPHONE
- UNDERGROUND FIBER OPTIC
- UNDERGROUND COMMUNICATIONS DUCT
- UNDERGROUND WATER MAIN
- UNDERGROUND GAS MAIN
- HEADWALL
- INLET
- CONC END SECTION
- UTILITY MANHOLE
- ELECTRIC/TELEPHONE SPLICE BOX
- TRAFFIC SIGNAL HANDHOLE
- POWER POLE
- TELEPHONE POLE
- HIGH MAST LIGHT
- ABOVE GROUND TRANSFORMER
- WATER VALVE OR UTIL. BOX
- FIRE HYDRANT
- RAILROAD SWITCH
- RAILROAD SIGNAL
- FIBER OPTIC JUNCTION BOX

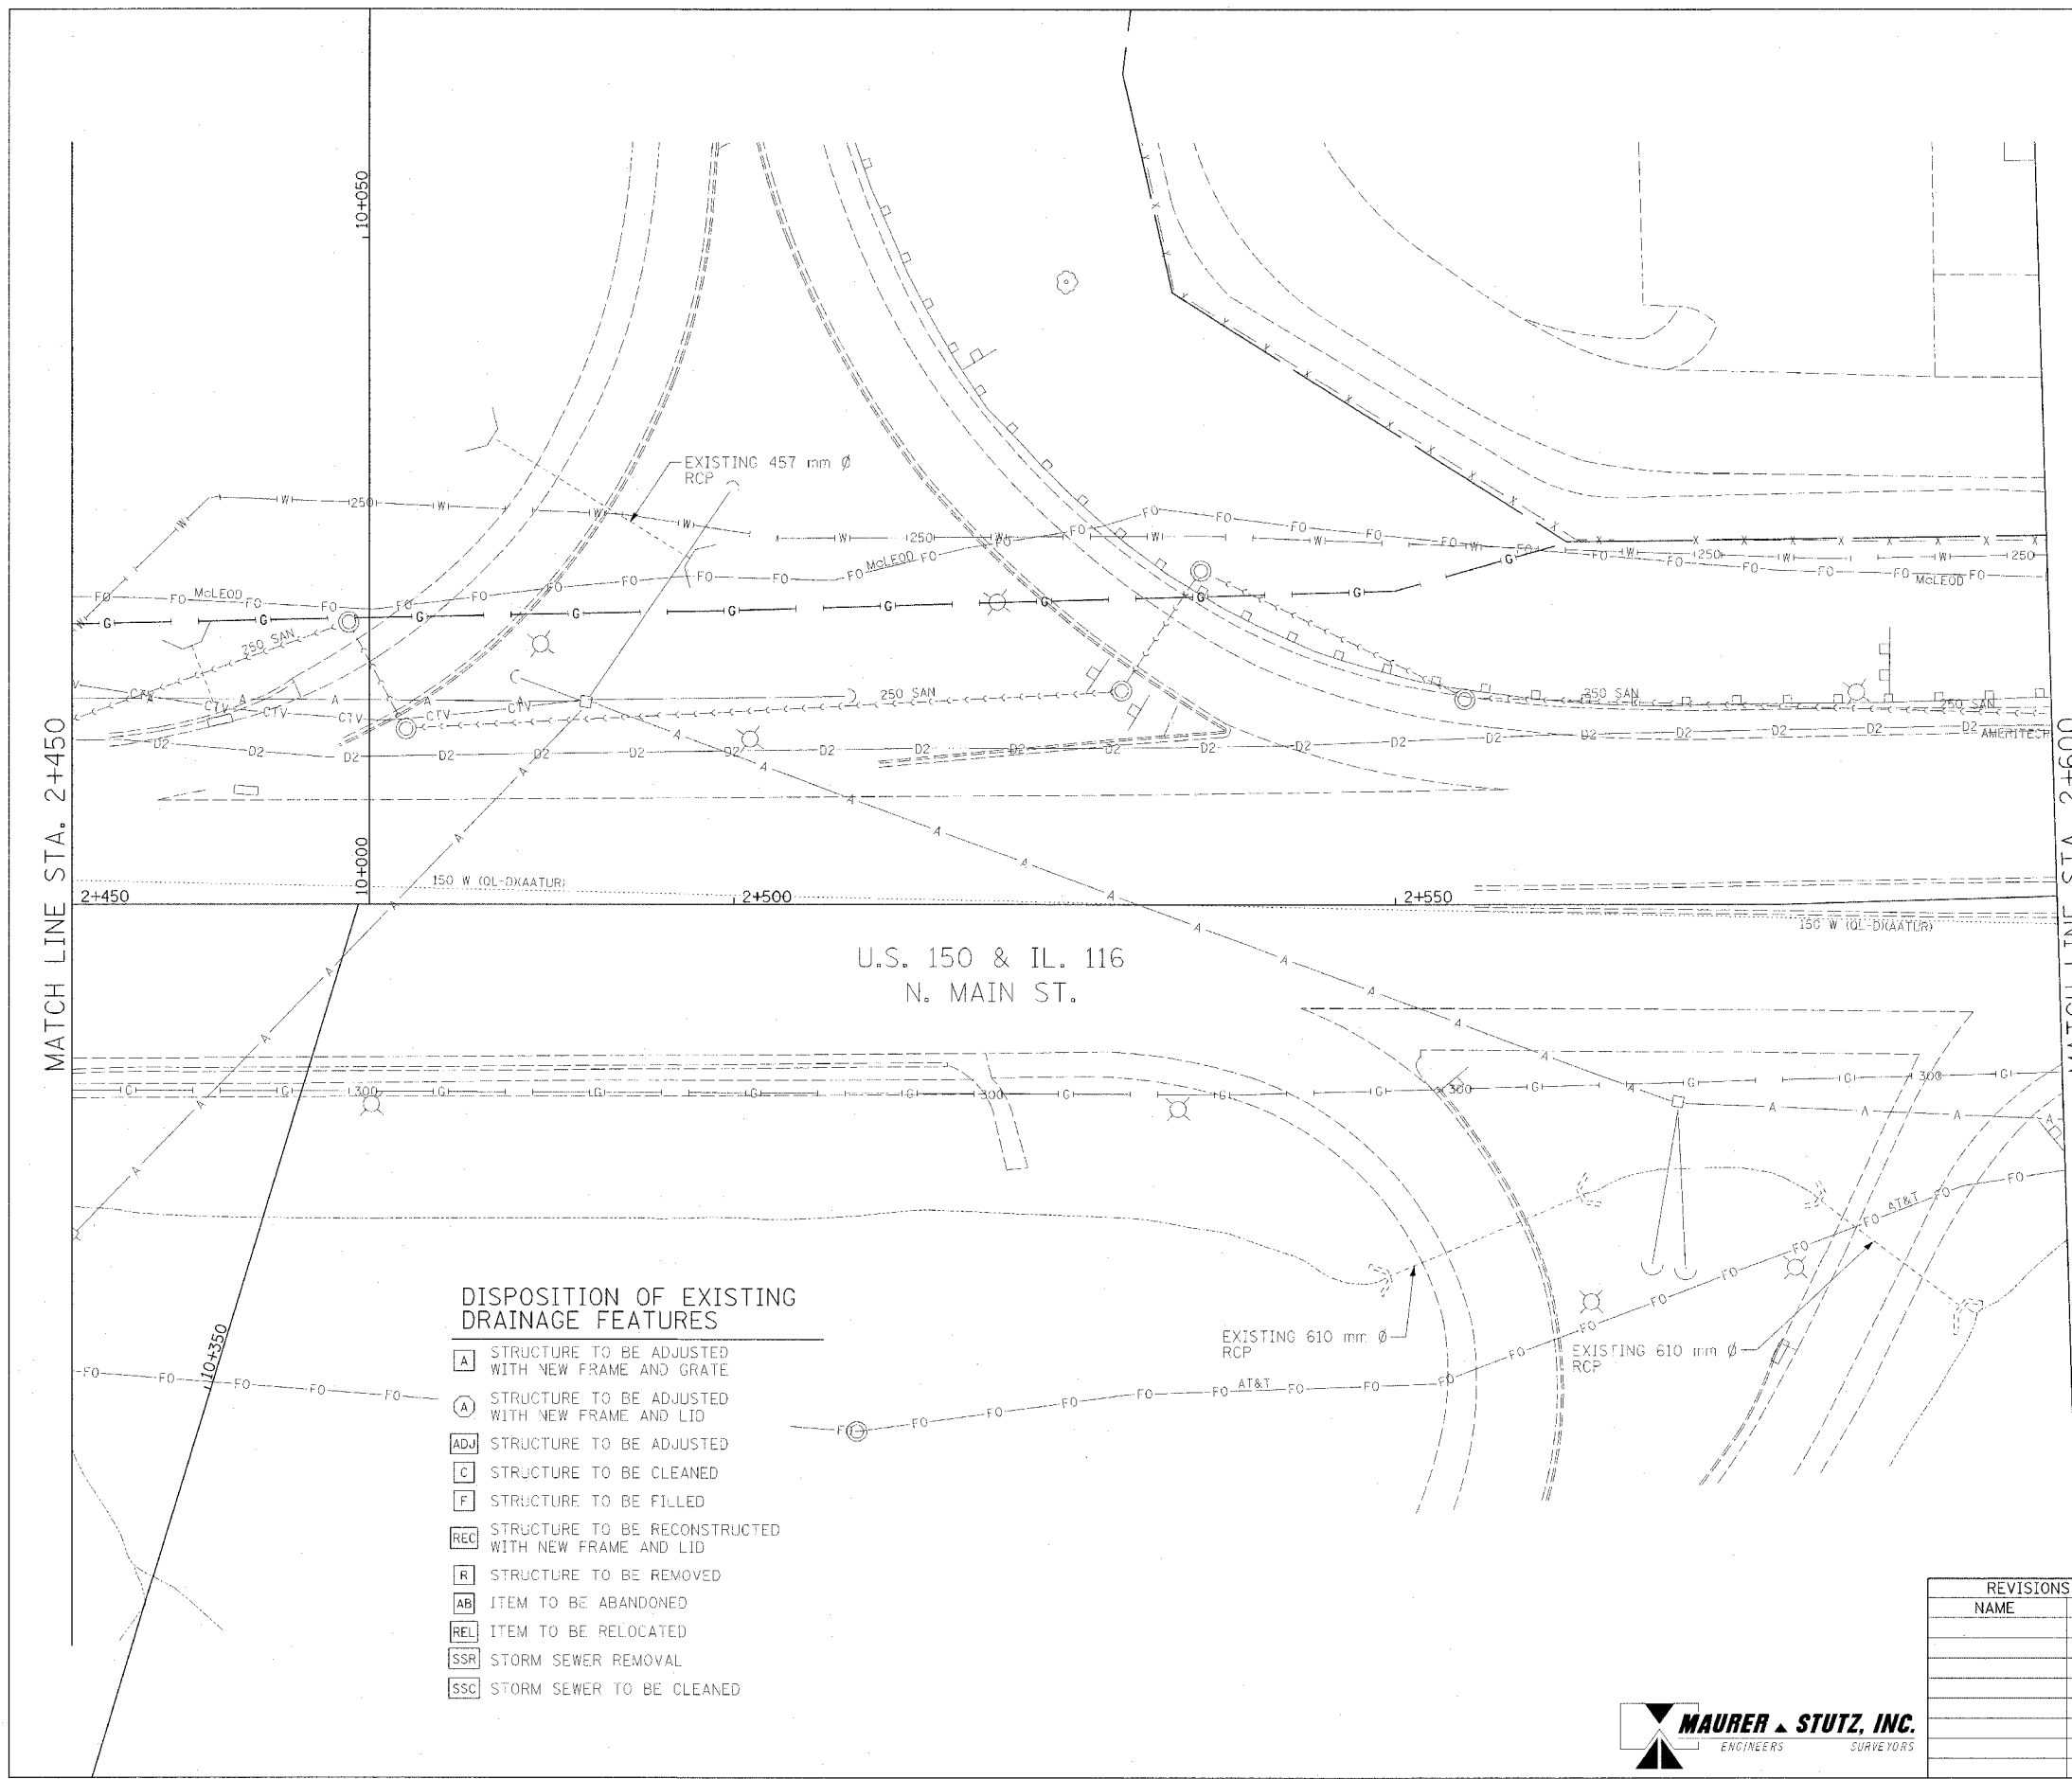

DISPOSITION OF EXISTING DRAINAGE FEATURES

- STRUCTURE TO BE ADJUSTED WITH NEW FRAME AND GRATE
- STRUCTURE TO BE ADJUSTED WITH NEW FRAME AND LID
- STRUCTURE TO BE ADJUSTED
- STRUCTURE TO BE CLEANED
- STRUCTURE TO BE FILLED
- STRUCTURE TO BE RECONSTRUCTED WITH NEW FRAME AND LID
- STRUCTURE TO BE REMOVED
- ITEM TO BE ABANDONED
- ITEM TO BE RELOCATED
- STORM SEWER REMOVAL
- STORM SEWER TO BE CLEANED

EXISTING CONDITIONS

REVISIONS	
NAME	DATE

ILLINOIS DEPARTMENT OF TRANSPORTATION
DRAINAGE AND UTILITY PLAN
MAIN STREET
 STA 2+450 TO 2+600

DATE 12/20/04

DRAWN BY JAM
 CHECKED BY MJS

