
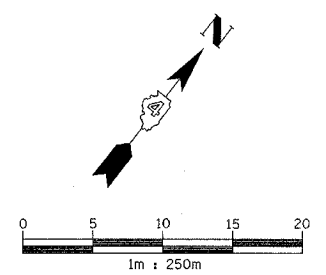


F.A.I. RTE.	SECTION	COUNTY	TOTAL SHEETS	SHEET NO.
74	*	TAZEWELL	1366	291
STA. 2+900.000		TO STA. 3+050.000		
FED. ROAD DIST. NO. 4 ILLINOIS FED. AID PROJECT				
* (90-11)R-2,901(13,14,14-1)R-1				

STRUCTURE NO.	104	104a	105	105b	105c	105d	106	107	107a	107b	108	108a	109	110
STATION	2+930.000	2+921.000	2+921.010	2+903.000	2+912.000	2+903.000	2+982.450	3+025.000	3+040.000	3+039.732	3+025.000	2+982.099	3+028.000	3+028.000
OFFSET	13.300 R	13.300 R	16.825 R	13.300 R	13.300 R	17.876 R	13.300 R	17.000 R	17.000 R	12.920 R	13.261 R	13.300 L	13,186 L	20,835 L
TYPE	INL G-1 SPE	INL G-1 SPE	MH TY A 1.2m	INL MH G-1 SPE 1.2m	INL G-1 SPE	MH TY A 1.5m	INL MH G-1 SPE 1.5m	MH TY A 1.2m	MH TY A 1.5m	INL G-1 SPE	INL G-1 SPE	INL MH G-1 SPE 1.5m	INL G-1 SPE	300mm PRC FLARED END SECTION
F & G	DIAGONAL	DIAGONAL	TY 1 CL	DIAGONAL	DIAGONAL	TY 1 CL	DIAGONAL	TY 37	TY 1 CL	DIAGONAL	DIAGONAL	DIAGONAL	DIAGONAL	-
CONTROL EL.	143.794	143.839	144.124	143.939	143.889	144.200	143.544	142.900	143.600	143.277	143.347	143.544	143.333	-
INV NW.	-	-	143.032	-	-	143.010	142.456	142.340	142.260	-	-	140.832	140.730	139.700
INV SE.	-	143.036	-	143.040	-	-	-	-	-	142.280	142.350	140.832	-	-
INV NE.	-	143.186	-	143.190	-	143.010	-	142.190	142.110	-	-	-	-	-
INV SW.	143.210	-	143.032	143.190	143.200	142.860	-	-	-	-	-	-	-	-
INV N.	-	-	-	-	-	-	-	-	-	-	-	-	-	-
INV S.	-	-	-	-	-	-	-	-	-	-	-	-	-	-
INV E.	-	-	-	-	-	-	-	-	-	-	-	-	-	-
INV W.	-	-	-	-	-	-	-	-	-	-	-	-	-	-
REMARKS	-	-	-	-	-	-	BUILD OVER EXIST PIPE	-	-	-	BUILD OVER EXIST PIPE	-	-	-

MATCH LINE STA. 2+900

MATCH LINE STA. 3+050

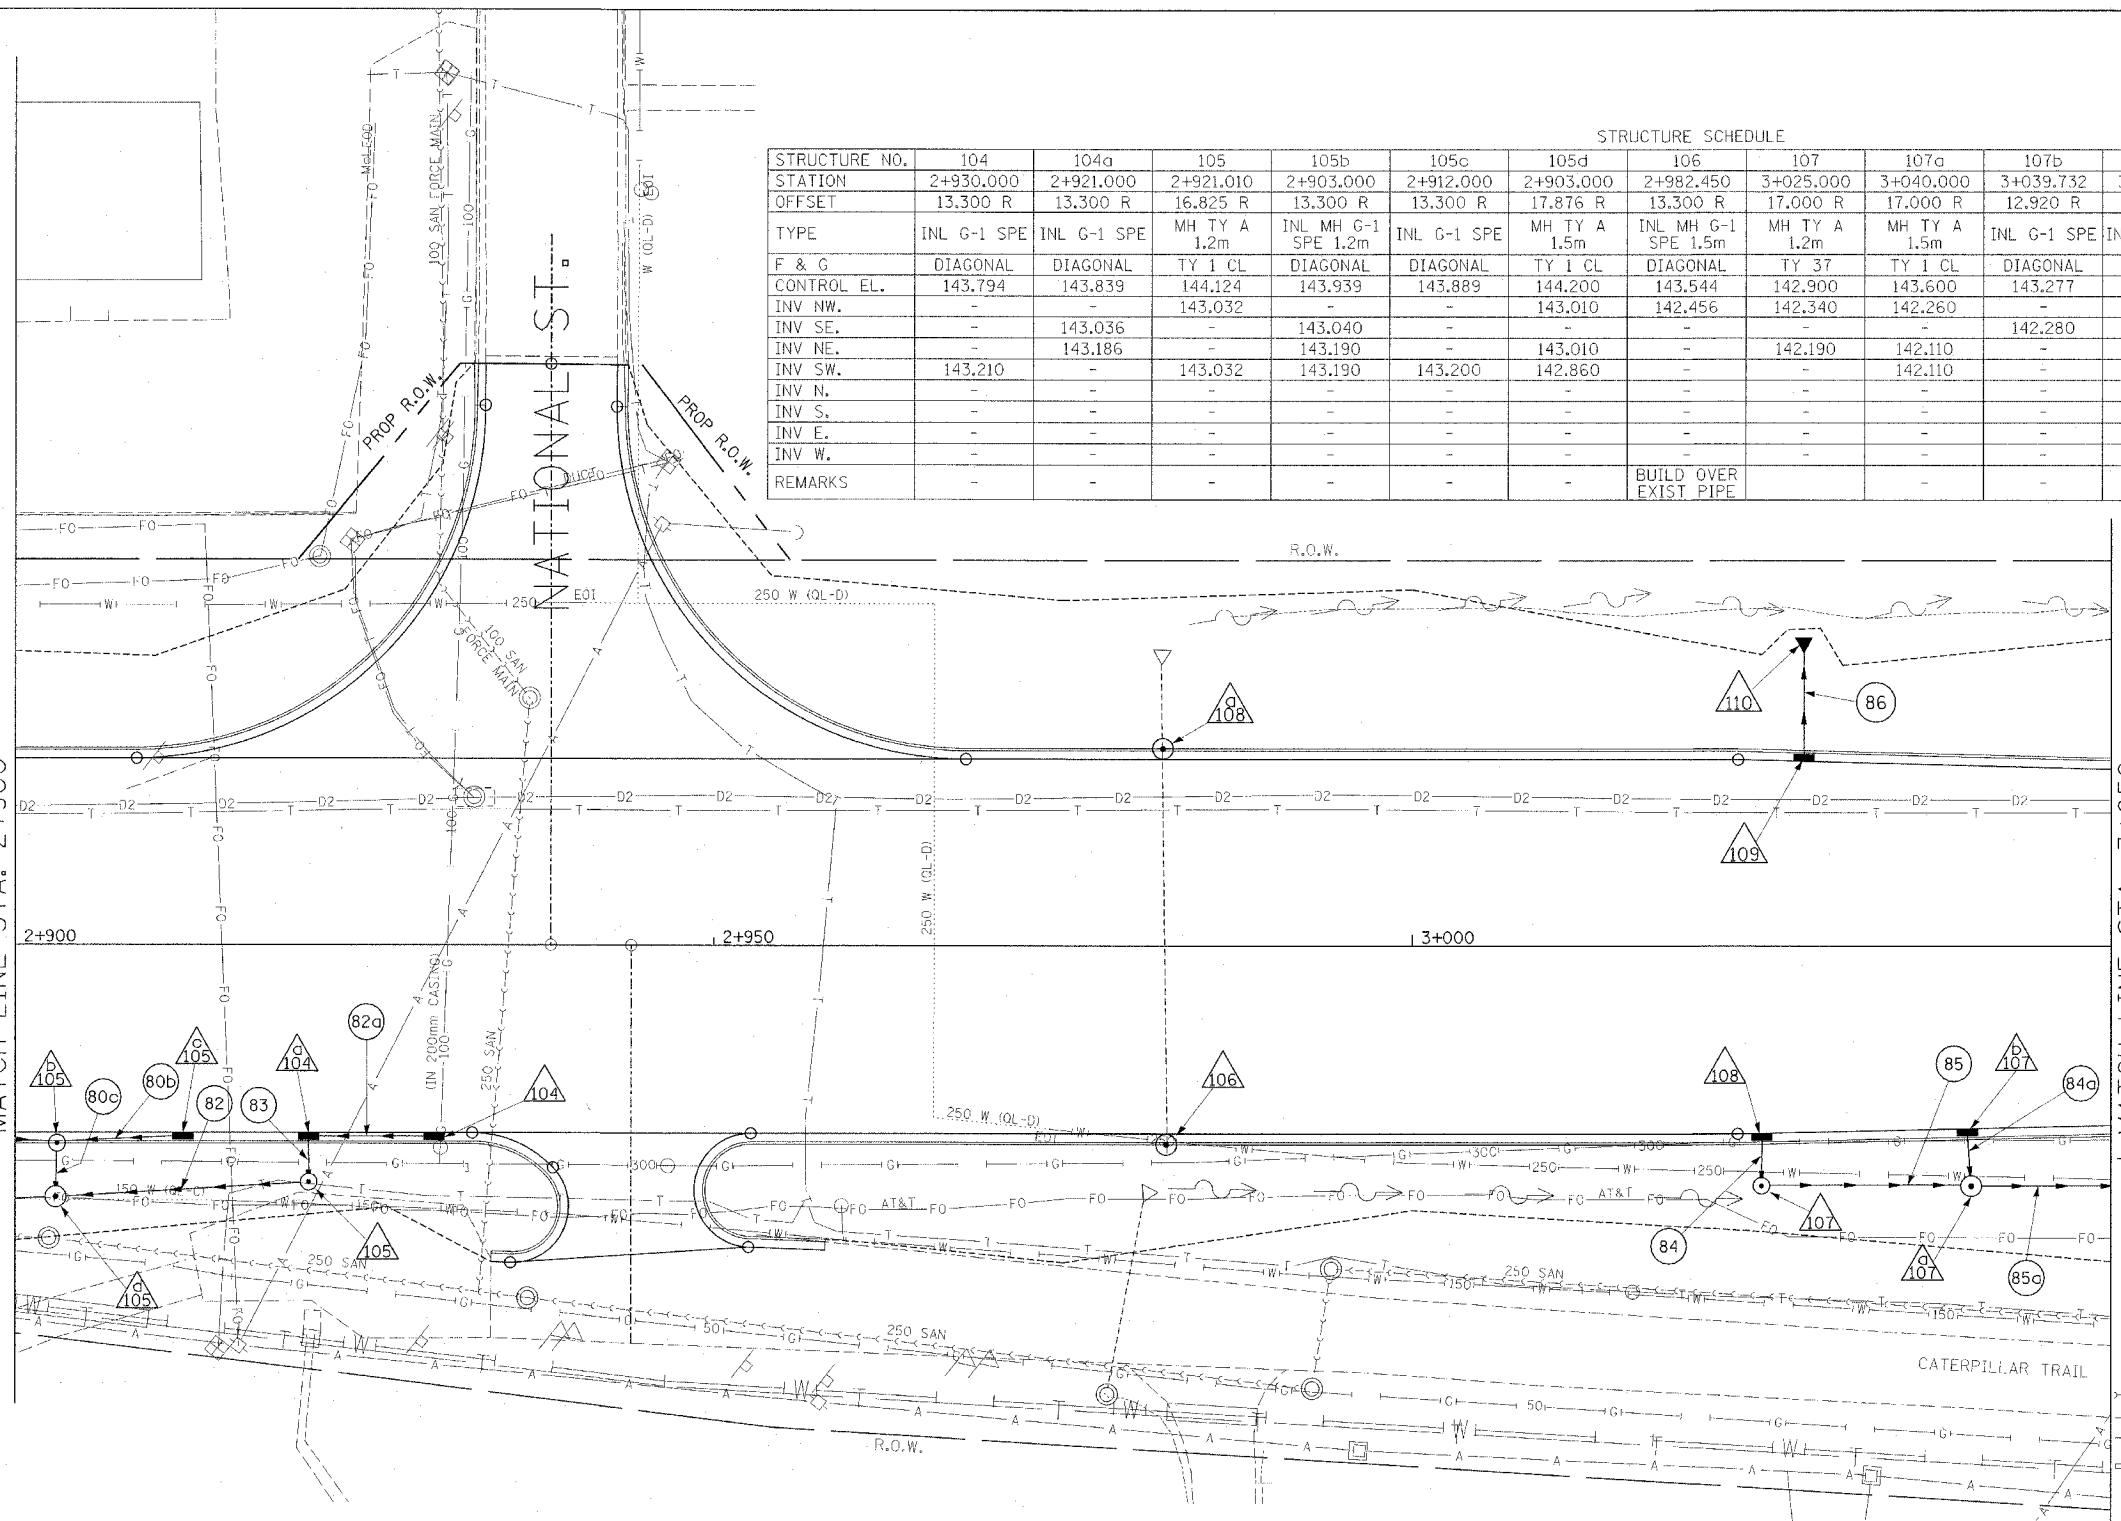

EXISTING	PROPOSED	DESCRIPTION
○	●	CATCH BASIN
○	○	INLET
○	○	MANHOLE
○	○	CONC END SECTION
○	○	SAG
○	○	SUMMIT
○	○	DITCH
○	○	SWALE
○	○	SANITARY SEWER
○	○	STORM SEWER
○	○	CULVERT PIPE
○	○	TRENCH DRAIN
△	△	STRUCTURE NUMBER
○	○	STORM SEWER PIPE NUMBER

PIPE NO.	80b	80c	82	82a	83	84	84a	85	85a	86
U/S-D/S	105c - 105b	105b - 105d	105 - 105d	104 - 104a	104a - 105	108 - 107	107b - 107a	107 - 107a	107a - 112a	109 - 110
LENGTH (m)	9.0	4.3	27.1	9.0	3.3	3.6	3.8	11.8	15.6	6.7
SIZE (mm)	300	450	450	300	450	300	300	450	600	300
CLASS/TYPE	A/1	A/1	A/1	A/1	A/1	A/1	A/2	A/2	A/2	A/2
T.B. (cu m)	0.6	0.5	-	0.5	0.4	0.3	0.5	-	-	2.4
REMARKS										

NAME	DATE

PROPOSED IMPROVEMENT  
 ILLINOIS DEPARTMENT OF TRANSPORTATION  
 DRAINAGE AND UTILITY PLAN  
 MAIN STREET  
 STA 2+900 TO 3+050  
 DATE 12/20/04  
 DRAWN BY JAM  
 CHECKED BY MJS

