


F.A.I. RTE.	SECTION	COUNTY	TOTAL SHEETS	SHEET NO.
74	*	TAZEWELL	1366	282

STA. 3+050.000 TO STA. 3+200.000
 FED. ROAD DIST. NO. 4 ILLINOIS FED. AID PROJECT
 * (90-11)R-2;90(13,14,14-1)R-1

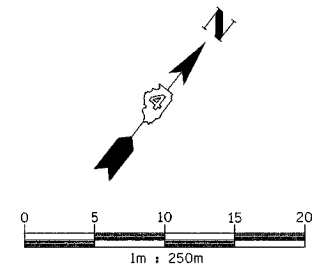


EXISTING DRAINAGE AND UTILITY LEGEND

- | | | | |
|------|---------------------------------|---|-------------------------------|
| —A— | OVERHEAD ELECTRIC | ⊙ | UTILITY MANHOLE |
| —S— | STORM SEWER | ⊠ | ELECTRIC/TELEPHONE SPLICE BOX |
| —SS— | SANITARY SEWER | ⊡ | TRAFFIC SIGNAL HANDHOLE |
| —C— | CULVERT PIPE | ⊞ | POWER POLE |
| —T— | TRENCH DRAIN | ⊕ | TELEPHONE POLE |
| —T— | UNDERGROUND TELEPHONE | ⊗ | HIGH MAST LIGHT |
| —FO— | UNDERGROUND FIBER OPTIC | ⊙ | ABOVE GROUND TRANSFORMER |
| —D— | UNDERGROUND COMMUNICATIONS DUCT | ⊙ | WATER VALVE OR UTIL. BOX |
| —W— | UNDERGROUND WATER MAIN | ⊙ | FIRE HYDRANT |
| —G— | UNDERGROUND GAS MAIN | ⊙ | RAILROAD SWITCH |
| — | HEADWALL | ⊗ | RAILROAD SIGNAL |
| — | INLET | ⊙ | FIBER OPTIC JUNCTION BOX |
| — | CONC END SECTION | | |

DISPOSITION OF EXISTING DRAINAGE FEATURES

- | | |
|-----|--|
| A | STRUCTURE TO BE ADJUSTED WITH NEW FRAME AND GRATE |
| Ⓐ | STRUCTURE TO BE ADJUSTED WITH NEW FRAME AND LID |
| ADJ | STRUCTURE TO BE ADJUSTED |
| C | STRUCTURE TO BE CLEANED |
| F | STRUCTURE TO BE FILLED |
| REC | STRUCTURE TO BE RECONSTRUCTED WITH NEW FRAME AND LID |
| R | STRUCTURE TO BE REMOVED |
| AB | ITEM TO BE ABANDONED |
| REL | ITEM TO BE RELOCATED |
| SSR | STORM SEWER REMOVAL |
| SSC | STORM SEWER TO BE CLEANED |

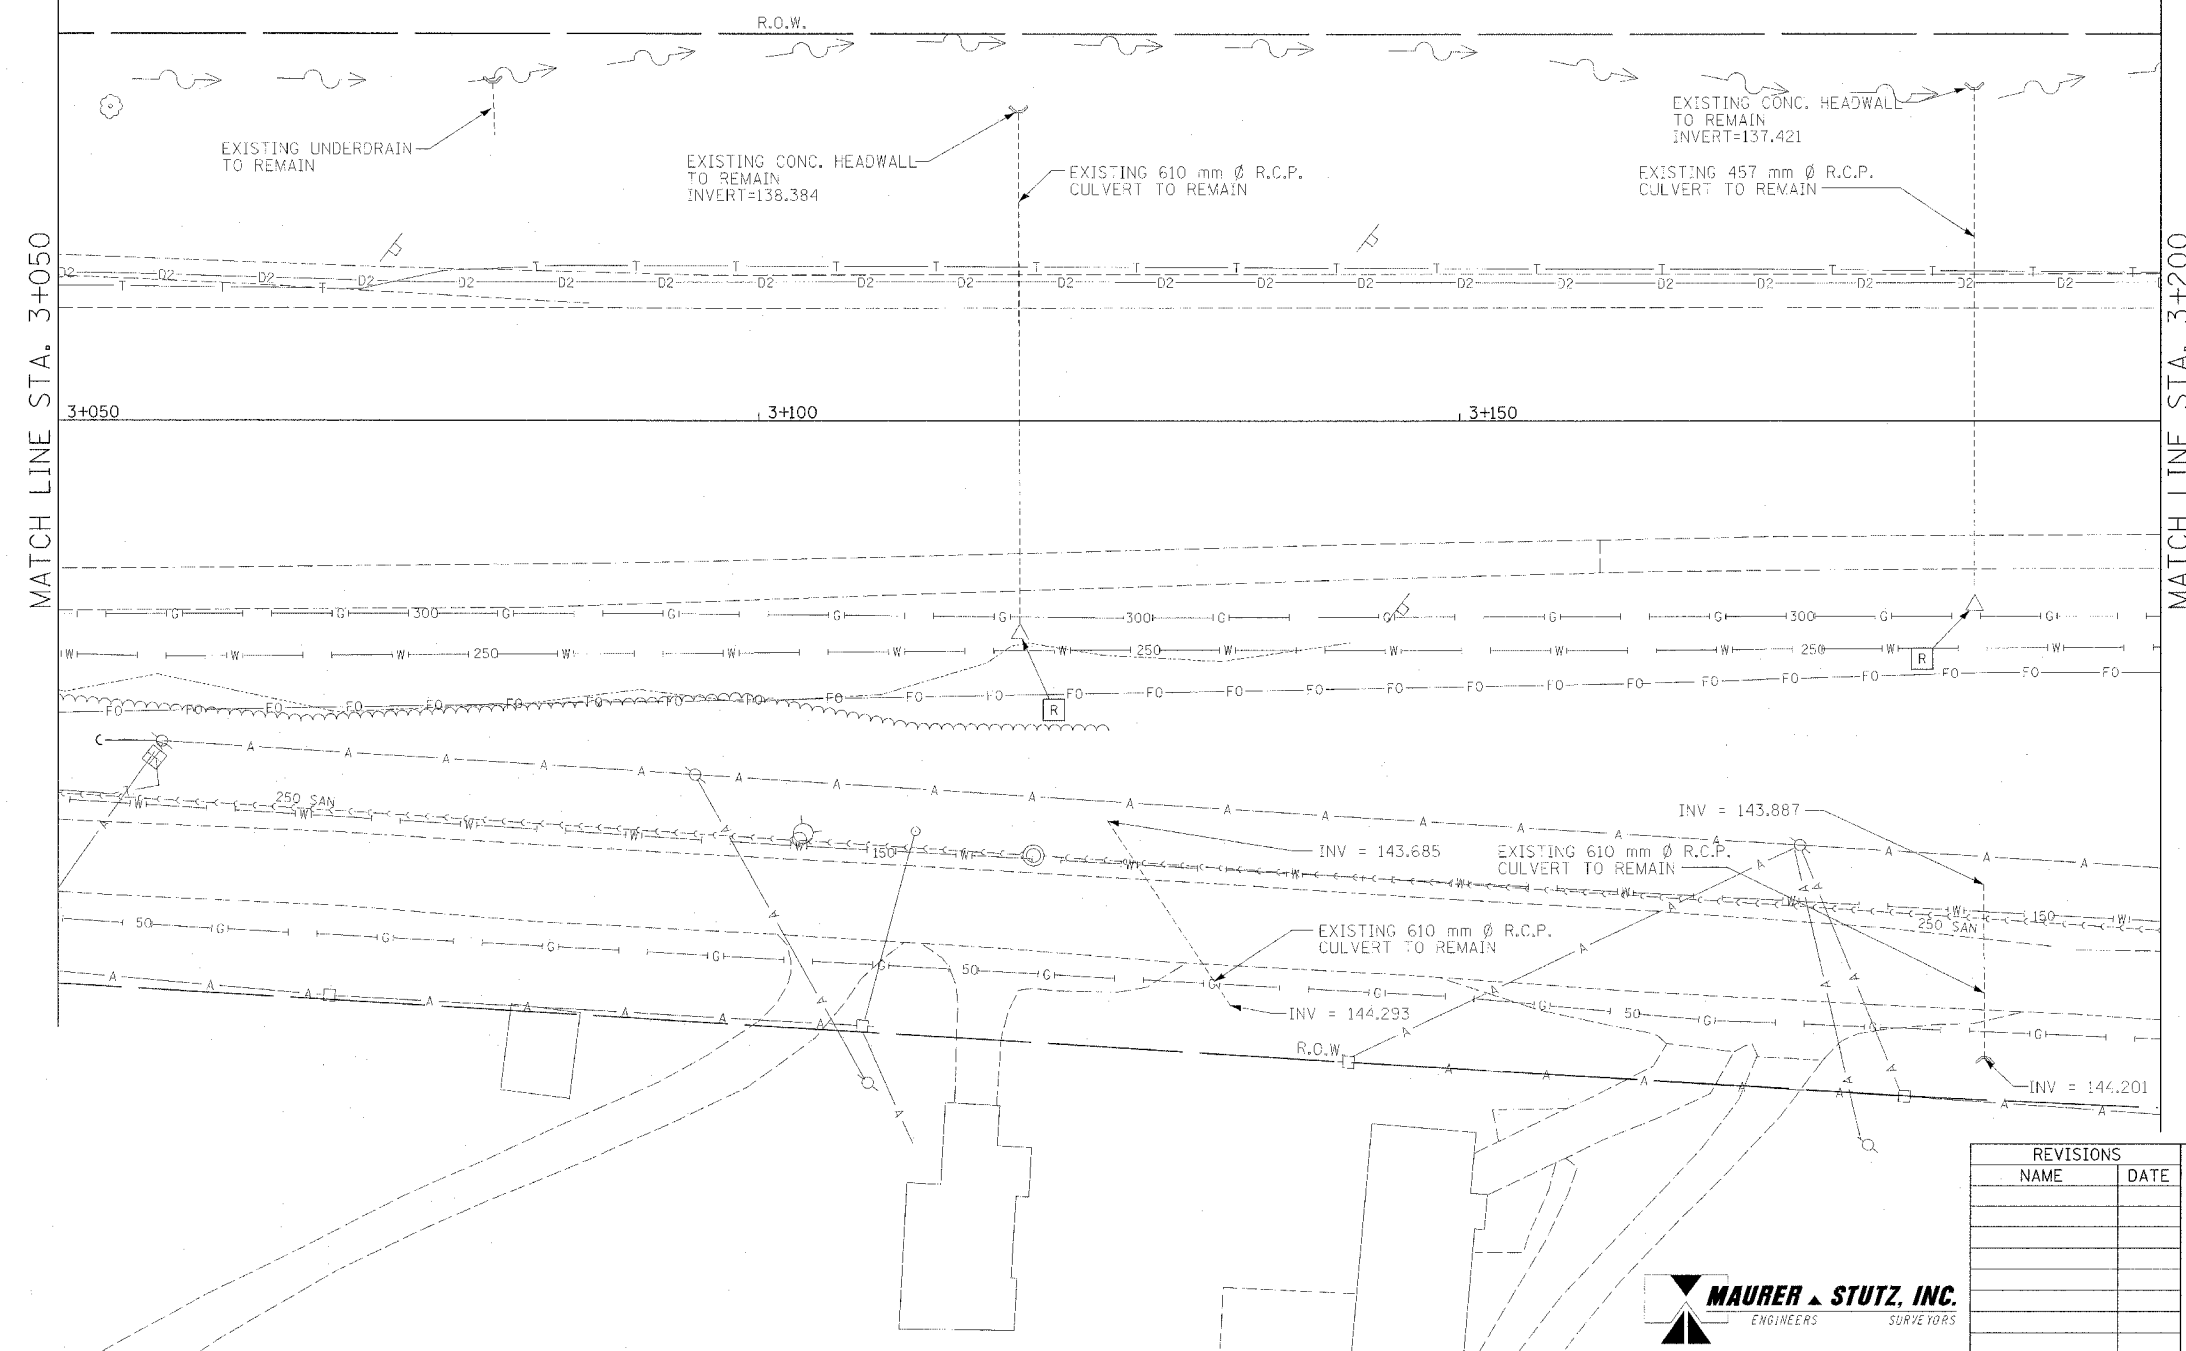

EXISTING CONDITIONS

REVISIONS	
NAME	DATE

ILLINOIS DEPARTMENT OF TRANSPORTATION
 DRAINAGE AND UTILITY PLAN
 MAIN STREET
 STA 3+050 TO 3+200
 DATE 12/20/04
 DRAWN BY JAM
 CHECKED BY MJS

