



F.A.I. RTE.	SECTION	COUNTY	TOTAL SHEETS	SHEET NO.
74	*	TAZEWELL	1366	287
STA. 3+350.000		TO STA. 3+500.000		
FED. ROAD DIST. NO. 4 ILLINOIS FED. AID PROJECT				
* (90-11R-2;90U13,14,14-1R-1				

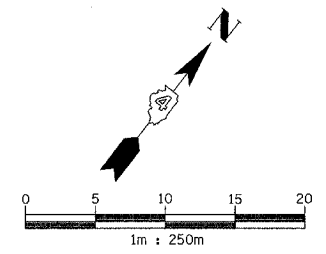

STRUCTURE SCHEDULE																
STRUCTURE NO.	131	132	133	133a	134	135	136	137	137a	138	139	140	140a	141		
STATION	3+380.000	3+380.000	3+417.000	3+420.000	3+416.924	3+460.000	3+460.000	3+462.000	3+475.000	3+475.000	3+417.027	3+460.000	3+462.000	3+490.000	3+490.000	3+460.000
OFFSET	14.500 R	11.450 R	14.300 R	16.944 R	11.450 R	15.000 R	12.123 R	12.172 R	12.524 R	15.470 R	11.350 L	11.350 L	11.350 L	12.876 R	15.822 R	20.250 L
TYPE	300mm PRC FLARED	INL G-1 SPE	600mm PRC FLARED	450mm PRC FLARED	INL MH G-1 SPE 1.5m	MH TY A 1.2m	INL G-1 DOUBLE SPECIAL	INL G-1 DOUBLE SPECIAL	INL G-1 SPE	MH TY A 1.2m	INL MH G-1 SPE 1.5m	INL G-1 DOUBLE SPECIAL	INL G-1 DOUBLE SPECIAL	INL G-1 SPE	MH TY A 1.2m	300mm PRC FLARED
F & G	END SECTION	DIAGONAL	END SECTION	END SECTION	DIAGONAL	TY 1 CL	DIAGONAL	DIAGONAL	DIAGONAL	TY 1 CL	DIAGONAL	DIAGONAL	DIAGONAL	DIAGONAL	TY 1 CL	END SECTION
CONTROL EL.	-	141.649	-	-	141.534	141.700	141.484	141.486	141.498	141.700	141.538	141.500	141.503	141.539	141.800	-
INV NW.	-	-	-	-	140.699	140.590	-	-	-	140.640	139.450	139.000	-	-	140.700	138.240
INV SE.	140.640	140.800	-	-	140.699	-	140.600	-	140.650	-	139.450	-	-	140.720	-	-
INV NE.	-	-	-	-	-	140.590	140.600	-	-	140.640	-	139.902	-	-	-	-
INV SW.	-	-	140.310	140.500	-	140.590	-	140.698	-	140.640	-	-	140.000	-	140.700	-
INV N.	-	-	-	-	-	-	-	-	-	-	-	-	-	-	-	-
INV S.	-	-	-	-	-	-	-	-	-	-	-	-	-	-	-	-
INV E.	-	-	-	-	-	-	-	-	-	-	-	-	-	-	-	-
INV W.	-	-	-	-	-	-	-	-	-	-	-	-	-	-	-	-
REMARKS	-	-	-	-	BUILD OVER EXIST PIPE	-	-	-	-	BUILD OVER EXIST PIPE	-	-	-	-	-	-

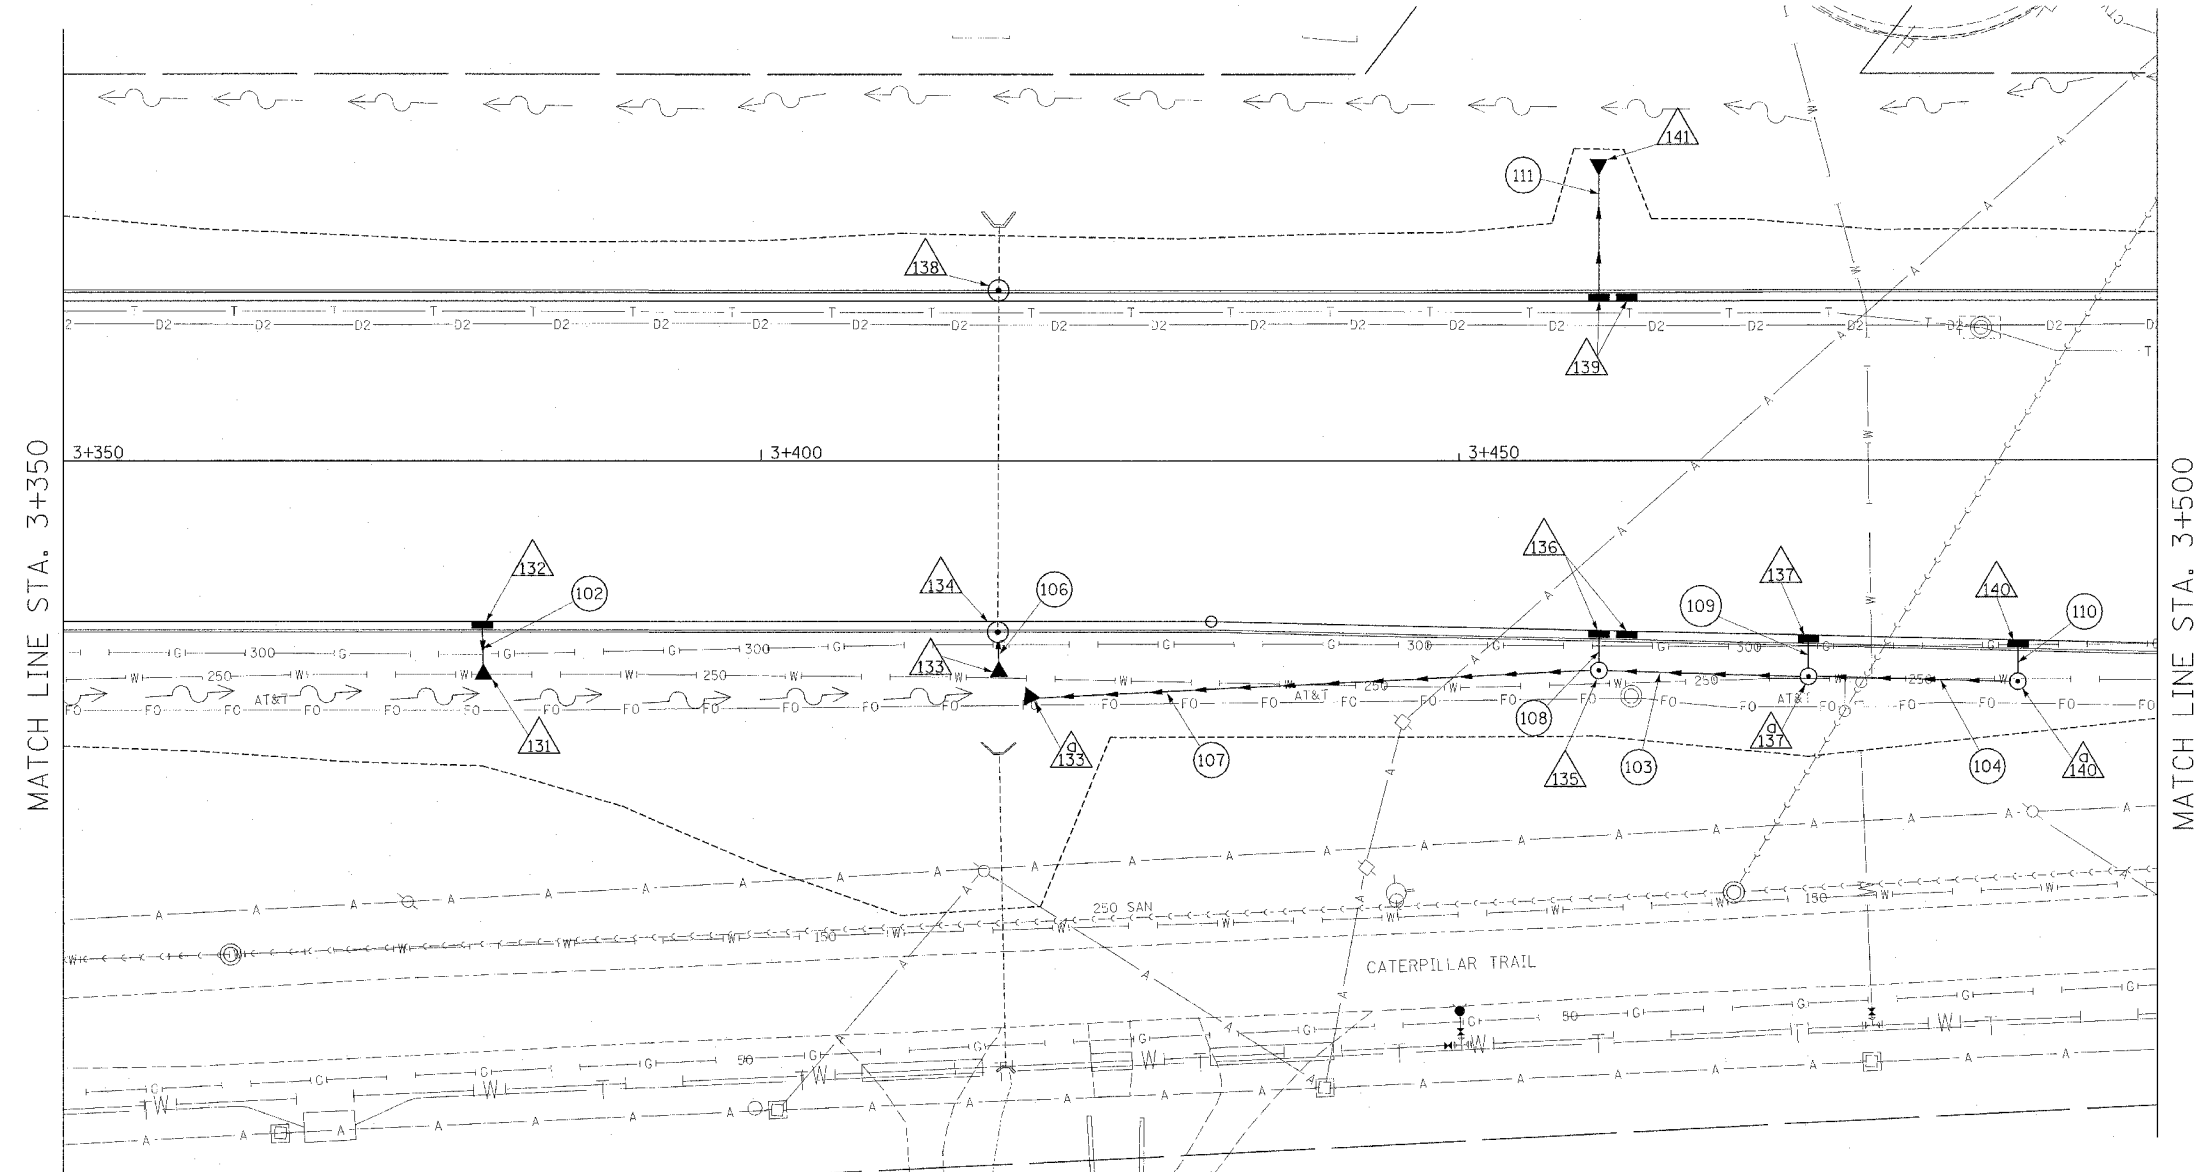

PIPE SCHEDULE									
PIPE NO.	102	103	106	104	107	108	109	110	111
U/S-D/S	132 - 131	137a - 135	133 - 134	140a - 137a	135 - 133a	136 - 135	137 - 137a	140 - 140a	139 - 141
LENGTH (m)	2.8	15.0	2.1	15.0	40.0	2.6	2.1	1.8	8.3
SIZE (mm)	300	450	600	300	450	450	300	300	300
CLASS/TYPE	A/1	A/2	A/1	A/1	A/1	A/1	A/1	A/1	A/2
T.B. (cu m)	0.5	-	0	-	-	0.6	0.4	0.4	2.1
REMARKS									

REVISIONS	
NAME	DATE



PROPOSED IMPROVEMENT

ILLINOIS DEPARTMENT OF TRANSPORTATION

DRAINAGE AND UTILITY PLAN  
 MAIN STREET  
 STA 3+350 TO 3+500

DATE 12/20/04

DRAWN BY JAM  
 CHECKED BY MJS