



F.A.I. RTE.	SECTION	COUNTY	TOTAL SHEETS	SHEET NO.
74	*	TAZEWELL	1366	293
STA. 3+800.000		TO STA. 3+950.000		
FED. ROAD DIST. NO. 4 ILLINOIS FED. AID PROJECT				
• (90-1DR-2,9013,14,14-1R-1				

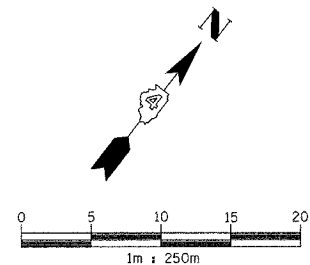

PIPE SCHEDULE										
PIPE NO.	123	123a	124	125	125a	126	127	128a	128b	128c
U/S-D/S	162 - 163	165 - 164	164 - 166	174 - 166	EXIST. - 164	168 - 169	170 - 171	166 - 167	167 - 172	172 - 173
LENGTH (m)	2.1	1.8	55.0	51.8	2.9	8.4	11.1	2.8	25.0	16.5
SIZE (mm)	300	300	750	450	300	300	300	750	750	750
CLASS/TYP	A/1	A/1	A/2	A/2	A/1	A/3	A/3	A/2	A/2	A/4
T.B. (cu m)	0.5	0.4	-	-	-	3.0	2.8	-	46.5	-
REMARKS					CONC. COLLAR					

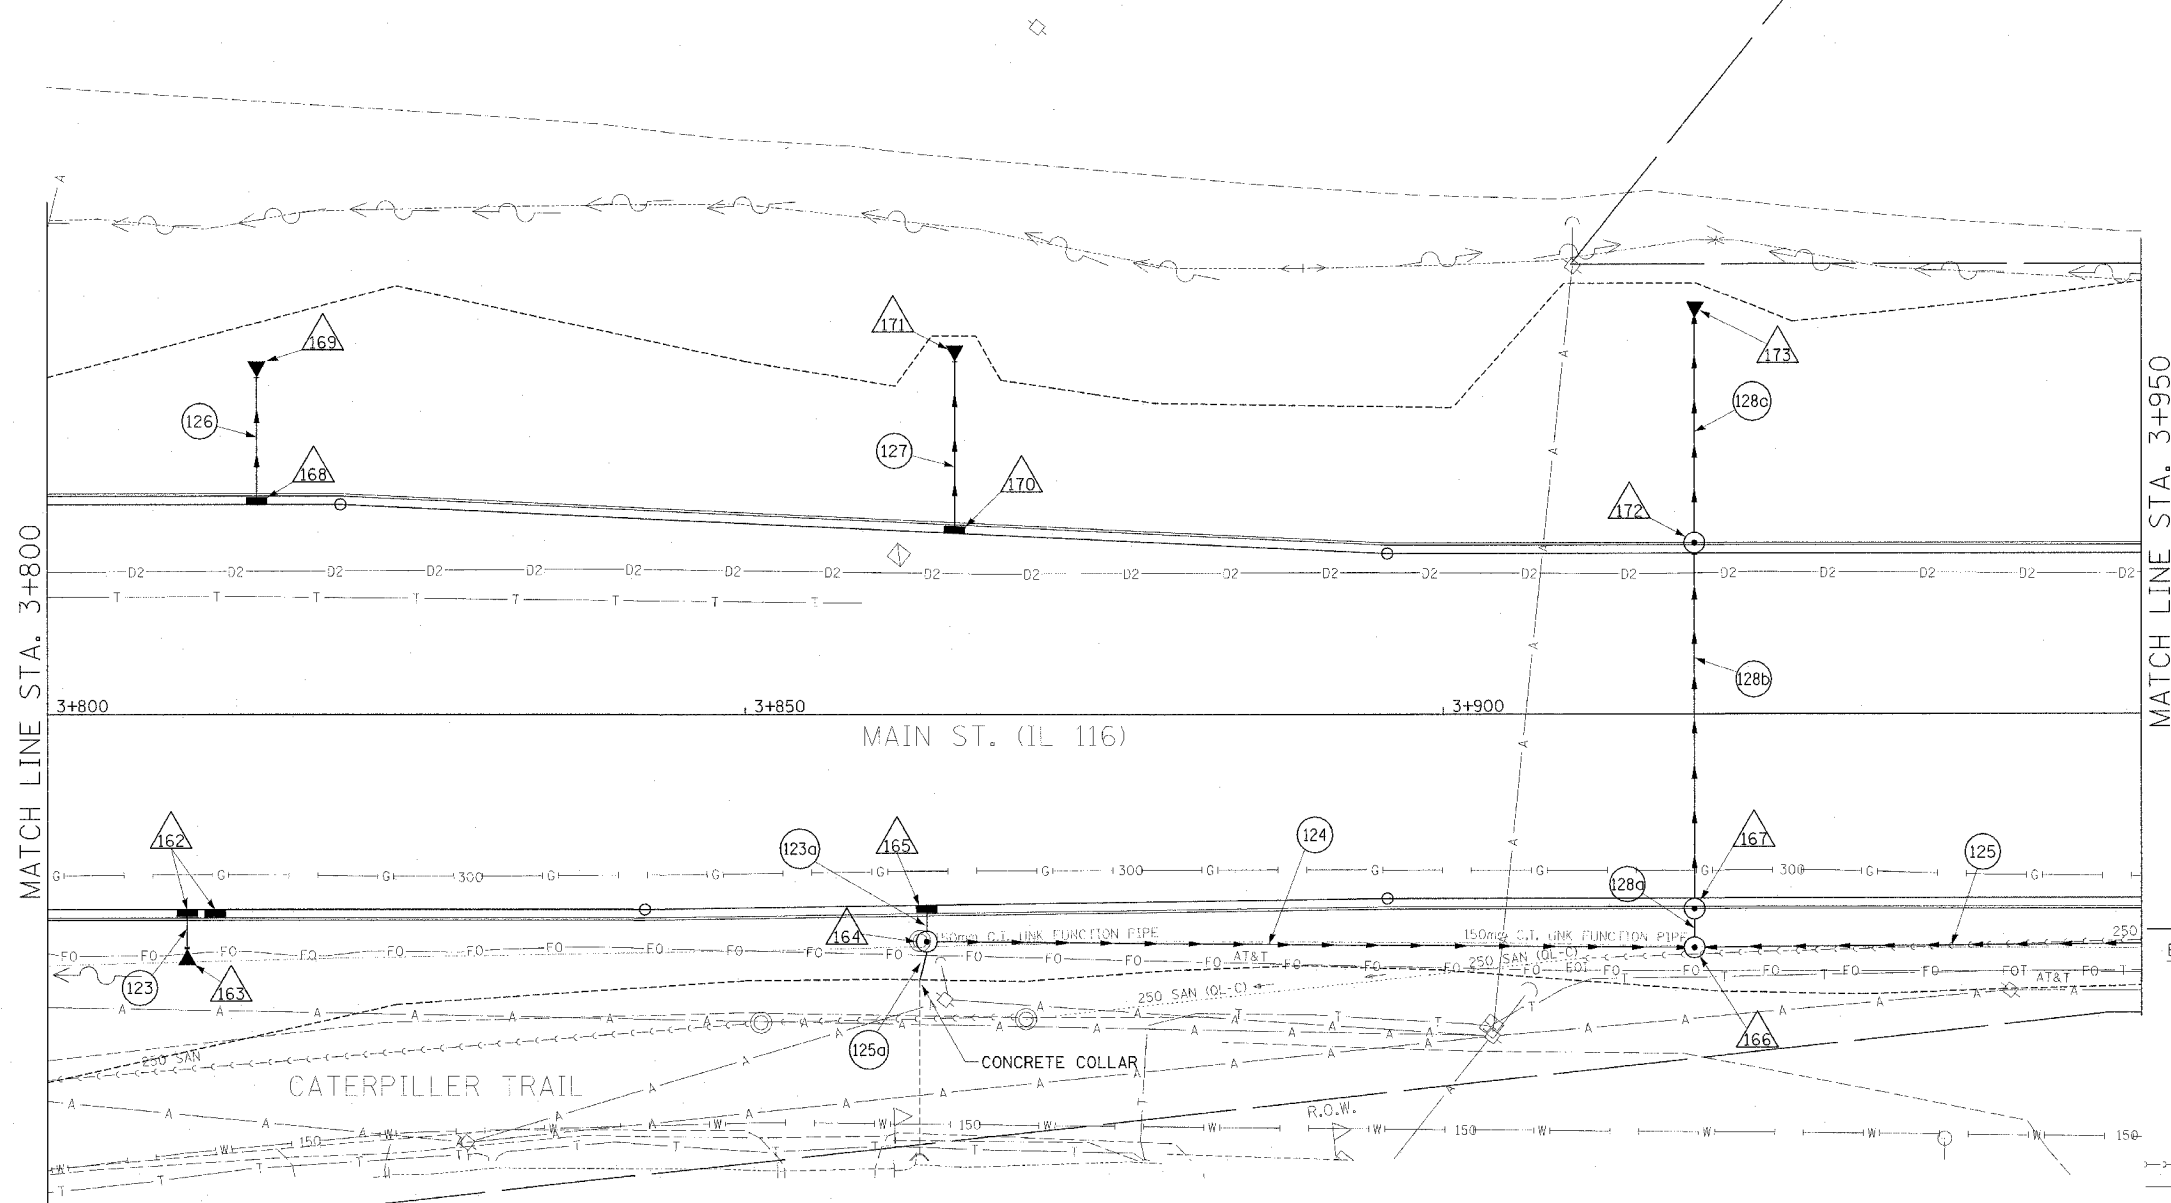

DRAINAGE LEGEND		
EXISTING	PROPOSED	
○	●	CATCH BASIN
○	○	INLET
○	○	MANHOLE
△	▲	CONC END SECTION
~	~	SAG
↑	↑	SUMMIT
↓	↓	DITCH
+	+	SWALE
—	—	SANITARY SEWER
—	—	STORM SEWER
—	—	CULVERT PIPE
—	—	TRENCH DRAIN
△		STRUCTURE NUMBER
○		STORM SEWER PIPE NUMBER

STRUCTURE SCHEDULE													
STRUCTURE NO.	162	163	164	165	166	167	168	169	170	171	172	173	
STATION	3+810.000	3+812.000	3+810.000	3+863.000	3+863.000	3+918.000	3+918.000	3+815.000	3+815.000	3+865.000	3+865.000	3+918.000	3+918.000
OFFSET	13.850 R	13.850 R	16.653 R	16.047 R	13.563 R	16.598 R	13.073 R	14.950 L	24.000 L	12.867 L	25.128 L	11.400 L	28.212 L
TYPE	INL G-1 DOUBLE SPECIAL		300mm PRC FLARED	MH TY A 1.5m	INL G-1 SPE	MH TY A 1.5m	INL MH G-1 SPE 1.5m	INL G-1 SPE	300mm PRC FLARED	INL G-1 SPE	300mm PRC FLARED	INL MH G-1 SPE 1.5m	750mm PRC FLARED
F & G	DIAGONAL	DIAGONAL	END SECTION	TY 1 CL	DIAGONAL	TY 1 CL	DIAGONAL	DIAGONAL	END SECTION	DIAGONAL	END SECTION	DIAGONAL	END SECTION
CONTROL EL.	144.510	144.531	-	145.300	145.031	145.700	145.580	144.522	145.056	-	-	145.580	-
INV NW.	-	-	-	144.160	-	143.740	143.700	141.000	140.150	141.500	141.230	139.910	139.620
INV SE.	143.410	-	143.350	144.300	144.180	-	143.700	-	-	-	-	143.240	-
INV NE.	143.410	-	-	144.160	-	143.890	-	-	-	-	-	-	-
INV SW.	-	143.508	-	-	-	143.890	-	-	-	-	-	-	-
INV N.	-	-	-	-	-	-	-	-	-	-	-	-	-
INV S.	-	-	-	-	-	-	-	-	-	-	-	-	-
INV E.	-	-	-	-	-	-	-	-	-	-	-	-	-
INV W.	-	-	-	-	-	-	-	-	-	-	-	-	-
REMARKS	-	-	-	-	-	-	-	-	-	-	-	-	-

REVISIONS	
NAME	DATE



PROPOSED IMPROVEMENT

ILLINOIS DEPARTMENT OF TRANSPORTATION

DRAINAGE AND UTILITY PLAN

MAIN STREET

STA 3+800 TO 3+950

DATE 12/20/04

DRAWN BY JAM

CHECKED BY MJS