


STRUCTURE SCHEDULE																		
STRUCTURE NO.	174	174a	175	175a	176	176a	176b	177	178	179	180	181	182	182a	184	184a	185	
STATION	3+970.000	4+001.000	3+970.000	4+001.000	4+030.000	4+053.000	4+053.000	4+030.000	4+032.000	4+097.000	4+097.000	3+970.000	3+970.000	4+035.000	4+100.000	4+100.000	4+100.000	
OFFSET	16.169 R	15.438 R	13.073 R	12.493 R	14.821 R	14.133 R	11.186 R	11.725 R	11.696 R	12.975 R	10.029 R	11.400 L	26.900 L	10.555 L	0.669 R	9.581 L	0.319 R	27.815 L
TYPE	MH TY A 1.2m	MH TY A 1.2m	INL G-1 SPE	INL G-1 SPE	MH TY A 1.2m	MH TY A 1.2m	INL G-1 SPE	INLET G-1 DOUBLE SPECIAL	MH TY A 1.2m	INL G-1 SPE	INL G-1 SPE	300mm PRC FLARED	300mm PRC FLARED	INL MH G-1 SPE 1.5m	EXISTING	INL MH G-1 SPE 1.2m	MH TY A 1.2m	300mm PRC FLARED
F & G	TY 1 CL	TY 1 CL	DIAGONAL	DIAGONAL	TY 1 CL	TY 1 CL	DIAGONAL	DIAGONAL	DIAGONAL	TY 1 CL	DIAGONAL	DIAGONAL	DIAGONAL	DIAGONAL	EXISTING	DIAGONAL	TY 1 OL	END SECTION
CONTROL EL.	146.400	146.750	146.161	146.566	147.150	147.300	147.171	146.931	146.954	147.700	147.436	146.083	142.080	146.660	146.761	147.219	147.375	-
INV NW.	145.410	145.040	-	-	145.790	145.860	-	-	-	146.400	-	-	-	142.920	143.450	142.000	146.000	140.900
INV SE.	-	-	145.460	145.060	-	-	145.880	145.830	-	-	-	-	-	142.920	-	145.450	-	-
INV NE.	144.410	145.030	-	-	145.610	145.860	-	145.830	-	-	-	-	-	-	-	-	-	-
INV SW.	144.410	145.030	-	-	145.460	145.860	-	-	145.928	146.340	-	-	-	-	-	-	-	-
INV N.	-	-	-	-	-	-	-	-	-	-	-	-	-	-	-	-	-	-
INV S.	-	-	-	-	-	-	-	-	-	-	-	-	-	-	-	-	-	-
INV E.	-	-	-	-	-	-	-	-	-	-	-	-	-	-	-	-	-	-
INV W.	-	-	-	-	-	-	-	-	-	-	-	-	-	-	-	-	-	-
REMARKS	-	-	-	-	-	-	-	-	-	-	-	-	-	BUILD OVER EXIST PIPE	-	-	-	-

F.A.I. RTE.	SECTION	COUNTY	TOTAL SHEETS	SHEET NO.
74	*	TAZEWELL	1366	295
STA. 3+950.000		TO STA. 4+100.000		
FED. ROAD DIST. NO. 4 ILLINOIS FED. AID PROJECT				
* (90-111R-2,90113,14,14-1R-1				

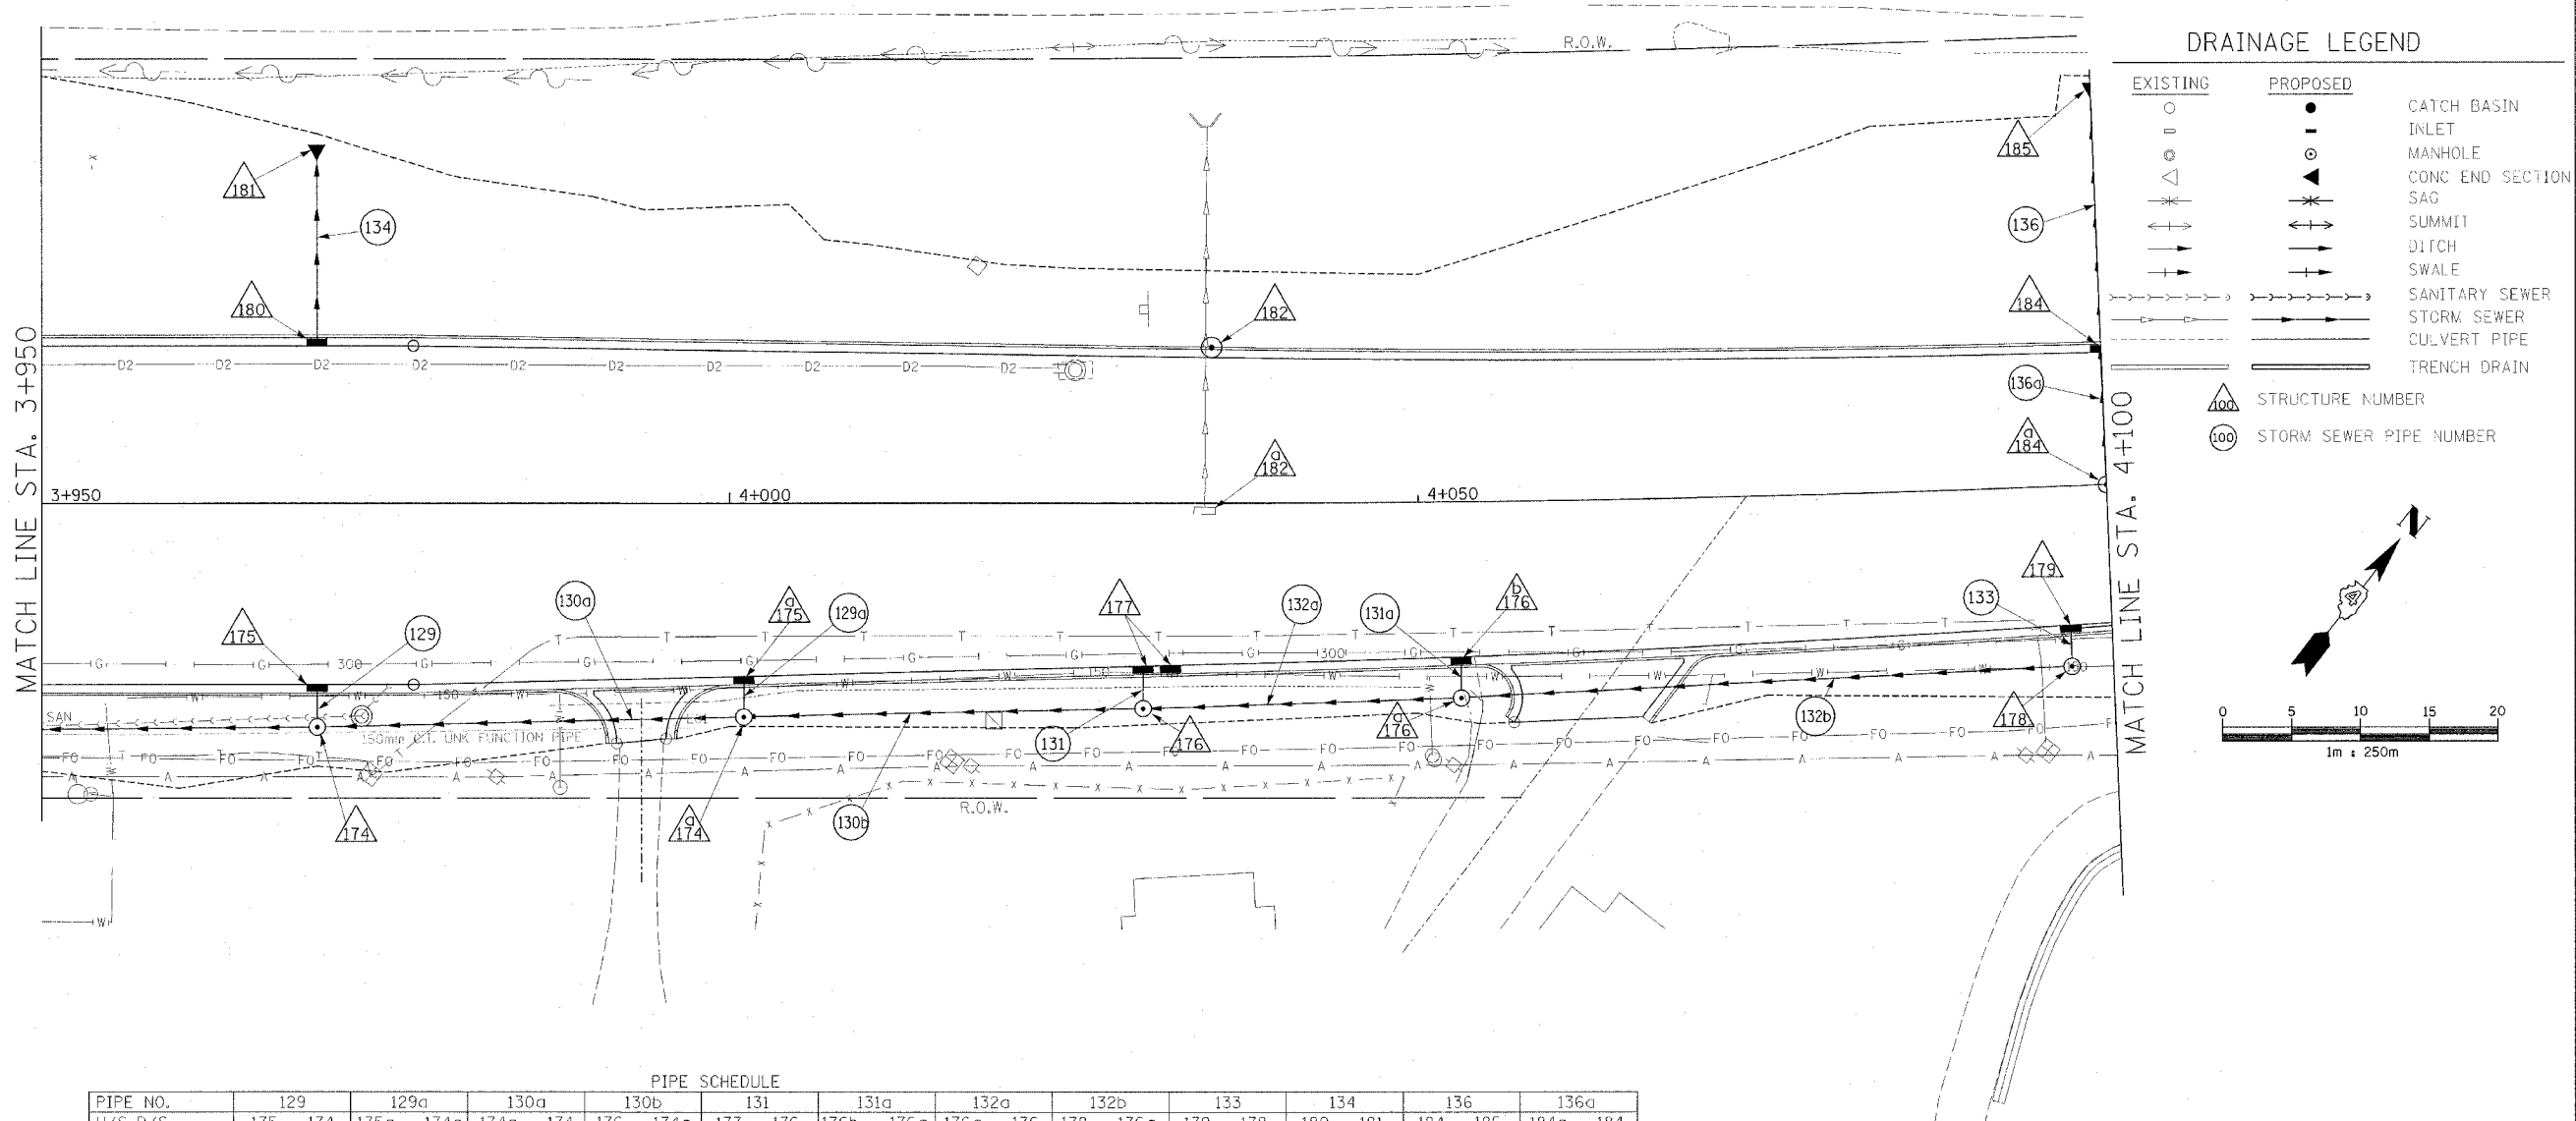

PIPE SCHEDULE												
PIPE NO.	129	129a	130a	130b	131	131a	132a	132b	133	134	136	136a
U/S-D/S	175 - 174	175a - 174a	174a - 174	176 - 174a	177 - 176	176b - 176a	176a - 176	178 - 176a	179 - 178	180 - 181	184 - 185	184a - 184
LENGTH (m)	1.8	1.7	31.0	29.2	2.0	1.6	23.0	44.4	1.7	14.8	17.5	10.3
SIZE (mm)	300	300	450	450	300	300	300	300	300	300	300	300
TYPE/CLASS	A/1	A/1	A/2	A/2	A/2	A/2	A/2	A/2	A/1	A/3	A/4	A/1
T.B. (cu m)	0.3	1.1	7.9	-	0.5	0.6	-	8.1	0.5	3.3	4.4	7.7
REMARKS												

REVISIONS	
NAME	DATE

PROPOSED IMPROVEMENT
 ILLINOIS DEPARTMENT OF TRANSPORTATION
 DRAINAGE AND UTILITY PLAN
 MAIN STREET
 STA 3+950 TO 4+100
 DRAWN BY JAM
 CHECKED BY MJS
 DATE 12/20/04

