
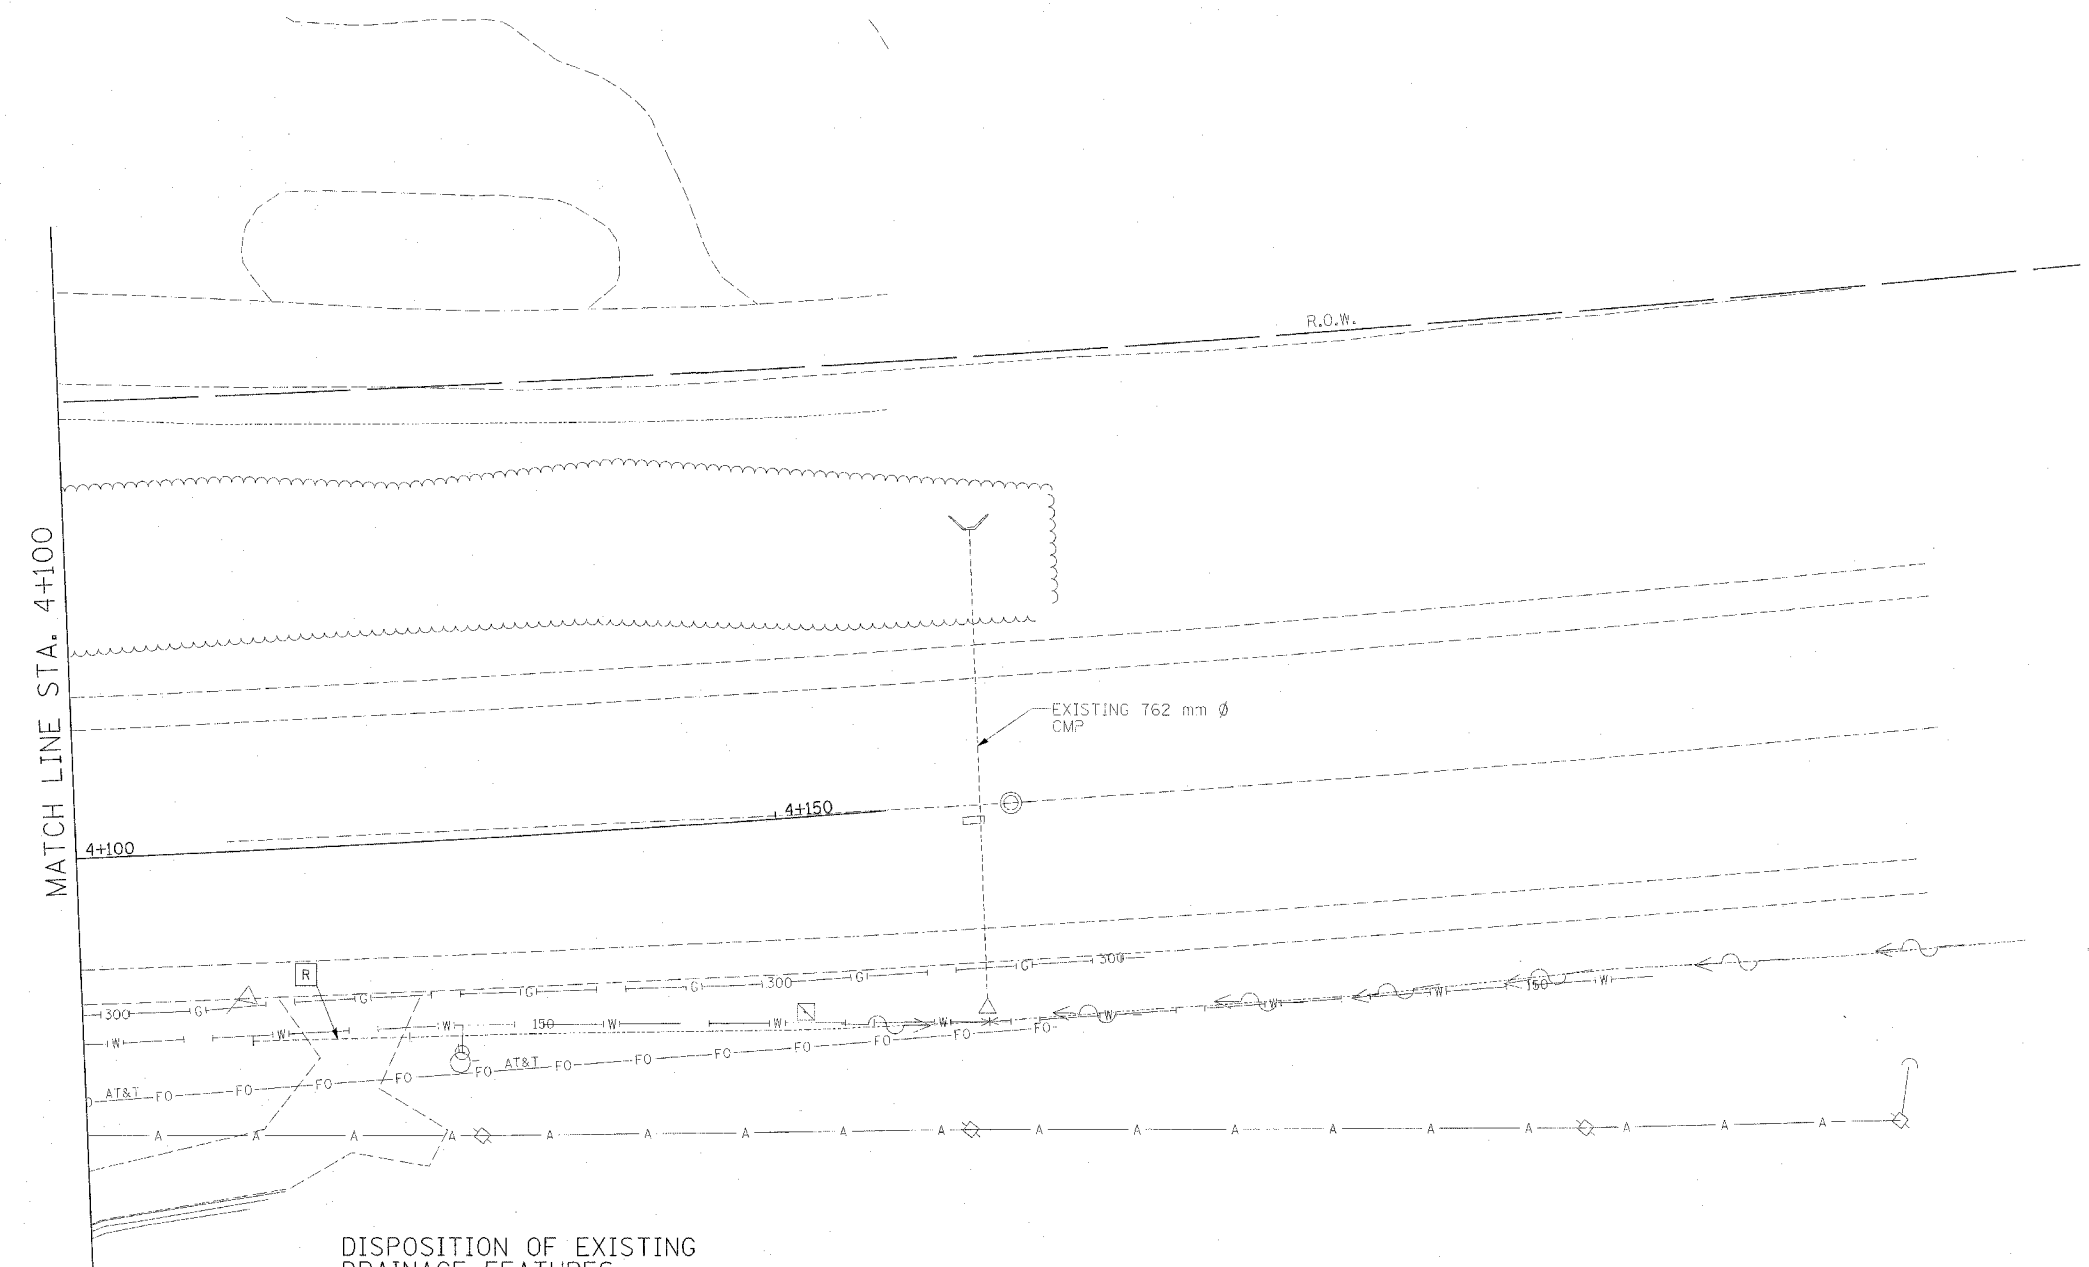


F.A.I. RTE.	SECTION	COUNTY	TOTAL SHEETS	SHEET NO.
74		TAZEWELL	1366	296
STA. 4+100.000		TO STA. 4+156.000		
FED. ROAD DIST. NO. 4		ILLINOIS FED. AID PROJECT		
• (90-1)R-2;90(13,14,14-1)R-1				

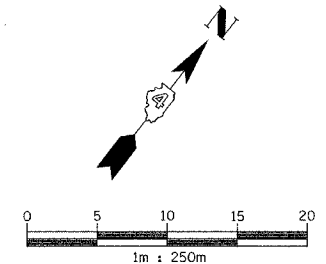

**EXISTING DRAINAGE AND UTILITY LEGEND**

- A — OVERHEAD ELECTRIC
- S — STORM SEWER
- S — SANITARY SEWER
- C — CULVERT PIPE
- T — TRENCH DRAIN
- T — UNDERGROUND TELEPHONE
- FO — UNDERGROUND FIBER OPTIC
- D — UNDERGROUND COMMUNICATIONS DUCT
- W — UNDERGROUND WATER MAIN
- G — UNDERGROUND GAS MAIN
- H — HEADWALL
- I — INLET
- C — CONC END SECTION
- M — UTILITY MANHOLE
- S — ELECTRIC/TELEPHONE SPLICE BOX
- T — TRAFFIC SIGNAL HANDHOLE
- P — POWER POLE
- T — TELEPHONE POLE
- L — HIGH MAST LIGHT
- T — ABOVE GROUND TRANSFORMER
- V — WATER VALVE OR UTIL. BOX
- F — FIRE HYDRANT
- S — RAILROAD SWITCH
- S — RAILROAD SIGNAL
- J — FIBER OPTIC JUNCTION BOX

**DISPOSITION OF EXISTING DRAINAGE FEATURES**

- [A] STRUCTURE TO BE ADJUSTED WITH NEW FRAME AND GRATE
- [A] STRUCTURE TO BE ADJUSTED WITH NEW FRAME AND LID
- [ADJ] STRUCTURE TO BE ADJUSTED
- [C] STRUCTURE TO BE CLEANED
- [F] STRUCTURE TO BE FILLED
- [REC] STRUCTURE TO BE RECONSTRUCTED WITH NEW FRAME AND LID
- [R] STRUCTURE TO BE REMOVED
- [AB] ITEM TO BE ABANDONED
- [REL] ITEM TO BE RELOCATED
- [SSR] STORM SEWER REMOVAL
- [SSC] STORM SEWER TO BE CLEANED

**EXISTING CONDITIONS**

REVISIONS		ILLINOIS DEPARTMENT OF TRANSPORTATION DRAINAGE AND UTILITY PLAN MAIN STREET STA 4+100 TO 4+156
NAME	DATE	
		DRAWN BY JAM CHECKED BY MJS DATE 12/20/04

