


STREET LIGHTING - BILL OF MATERIAL - THIS SHEET


PAY ITEM	UNIT	QUANTITY
HIGH MAST LUMINAIRE, (INSTALL ONLY)	EACH	5
LIGHT TOWER, INSTALL ONLY	EACH	1
LIGHT TOWER FOUNDATION	METER	6.1

F.A.I. RTE.	SECTION	COUNTY	TOTAL SHEETS	SHEET NO.
74	*	TAZEWELL	1366	1220
STA. 154+150		TO STA. 154+500		
FED. ROAD DIST. NO.	ILLINOIS	FED. AID PROJECT		
* (90-11R-2)90(13, 14, 14-1R-1		CONTRACT NO. 68201		

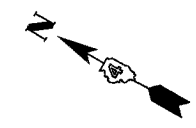


MATCH LINE STA. 154+150 (EB)
(SEE LIGHTING SHEET 9)

END OF LIGHTING IMPROVEMENT

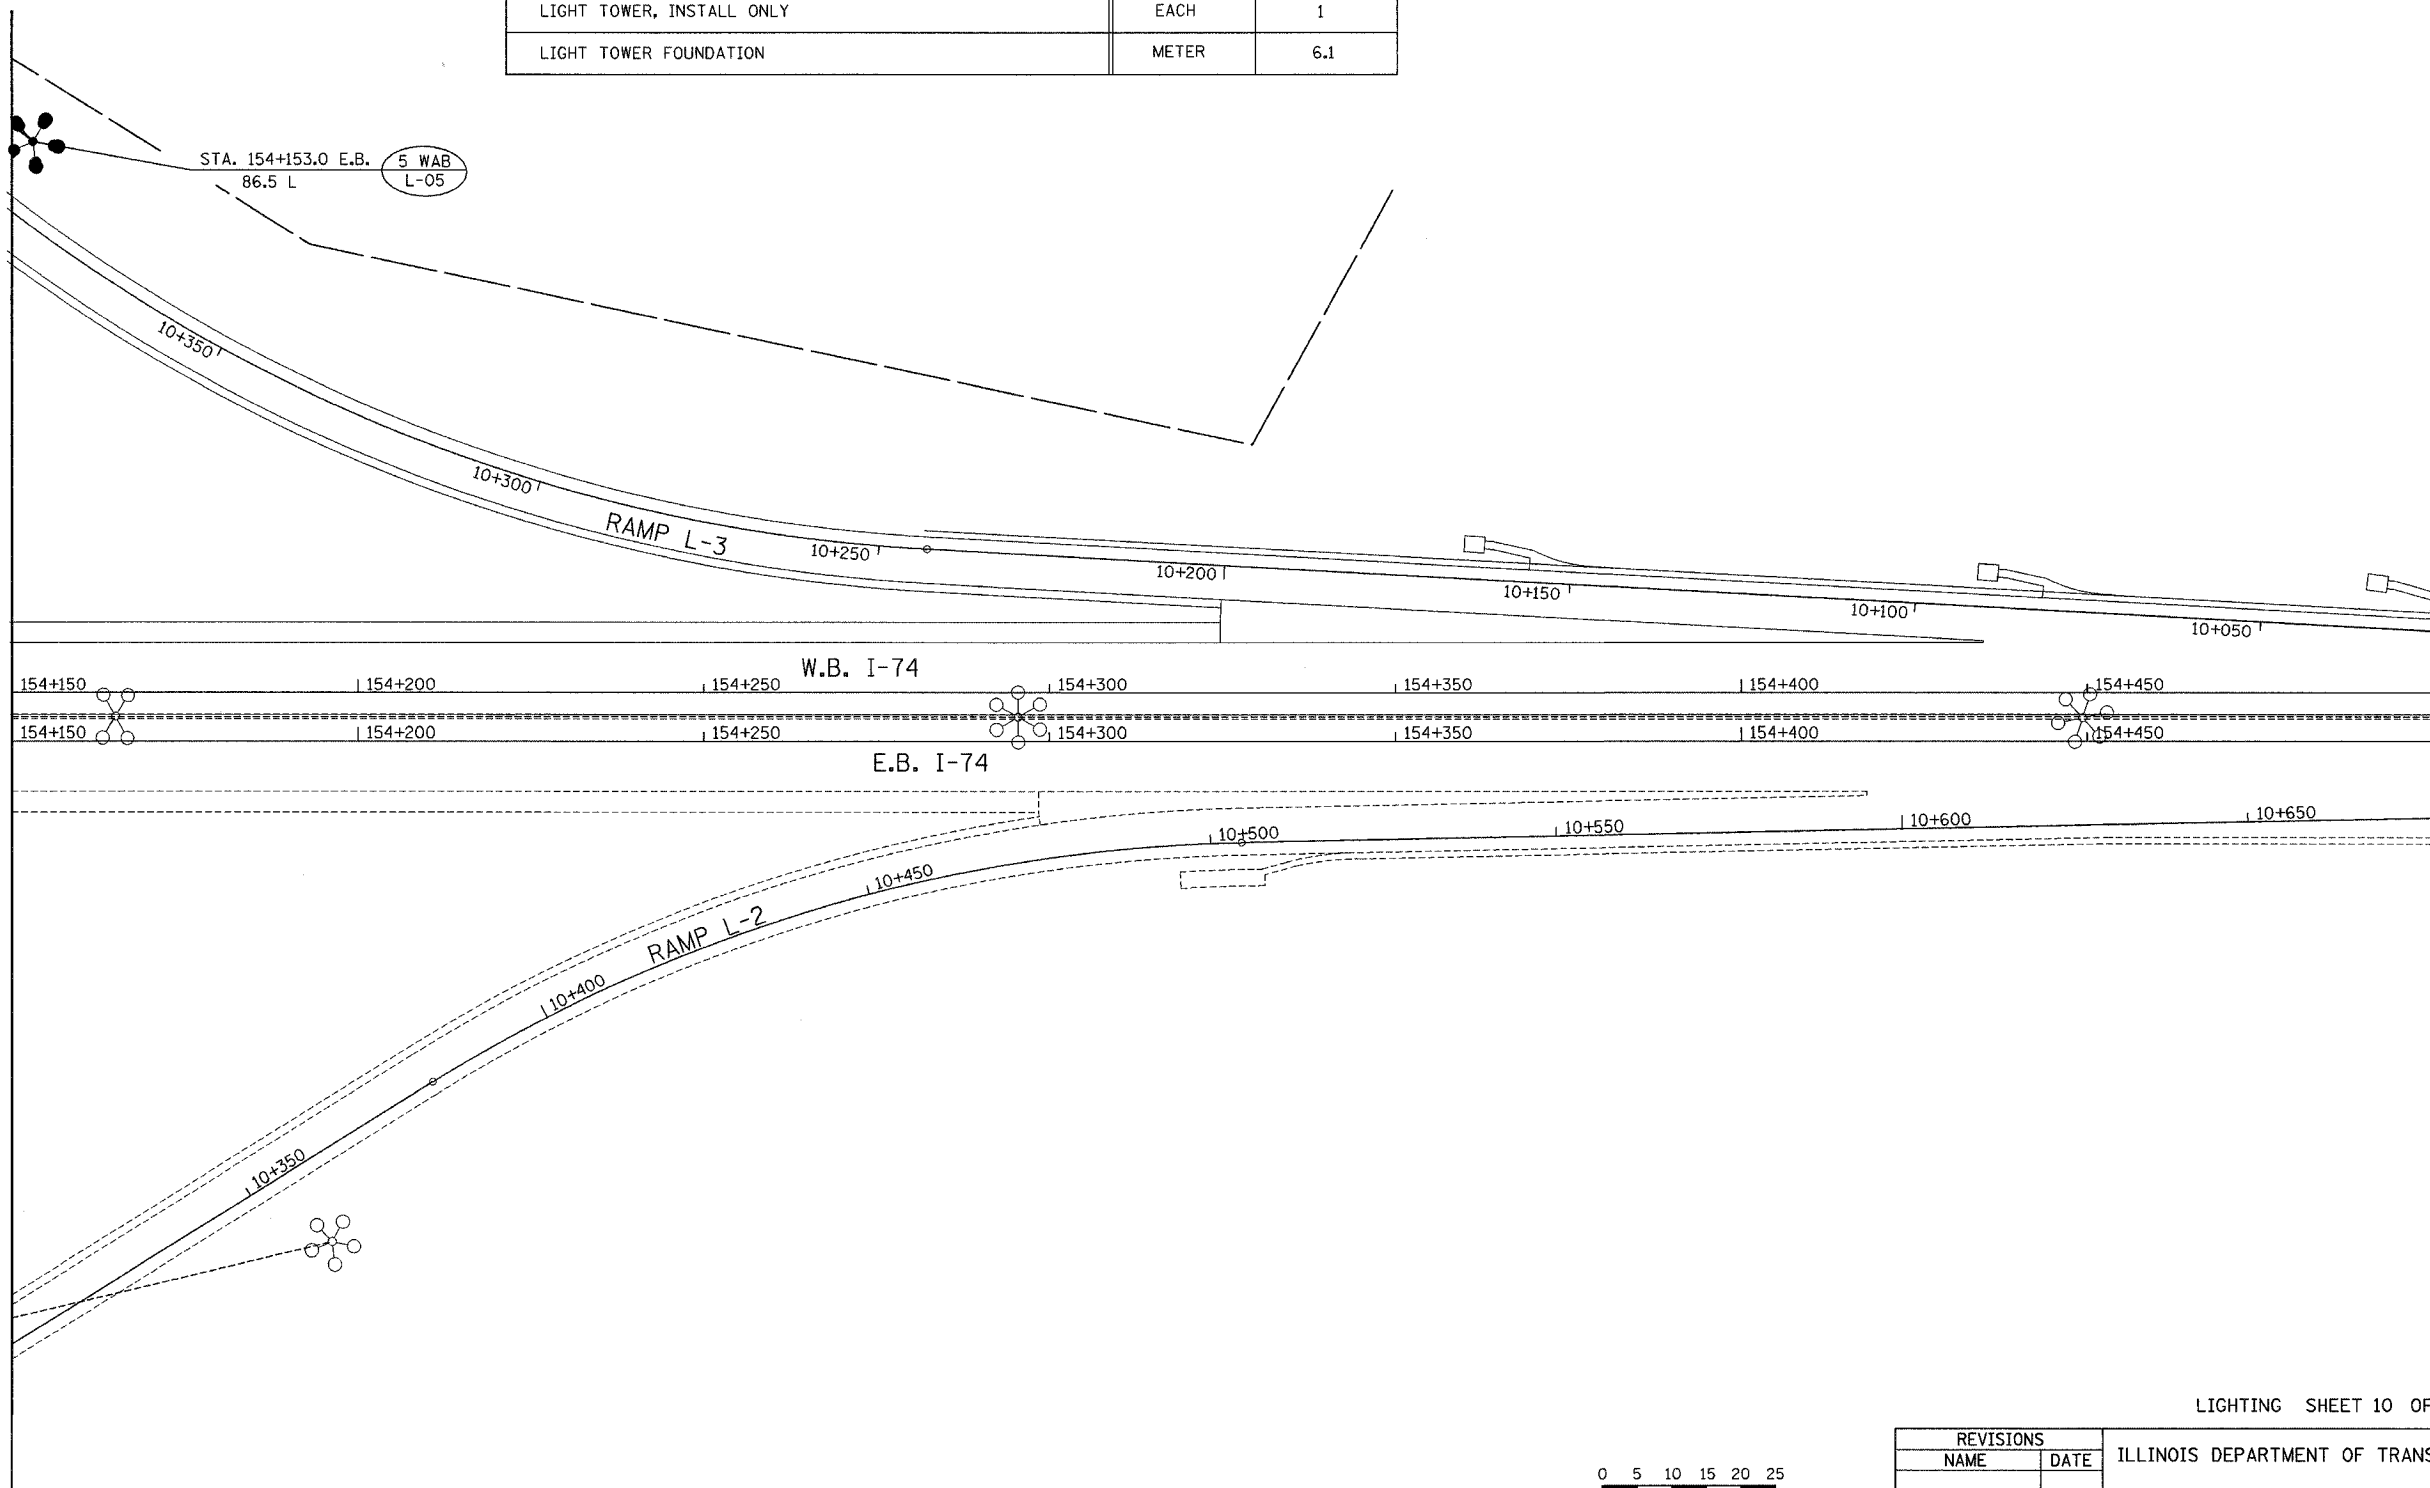

 12/20/2004 12:41:17 PM m:\p00_13573\lighting\74\contract\111106-707-4.dwg



ab alfred benesch & company
CONSULTING ENGINEERS
205 NORTH MICHIGAN AVENUE, CHICAGO, ILLINOIS 60601

REVISIONS	
NAME	DATE

LIGHTING SHEET 10 OF 41
ILLINOIS DEPARTMENT OF TRANSPORTATION
PROPOSED LIGHTING PLAN
W.B. I-74
STA. 154+150 TO STA. 154+500
DRAWN BY DJK
CHECKED BY MKR
DATE: 12/20/04