

 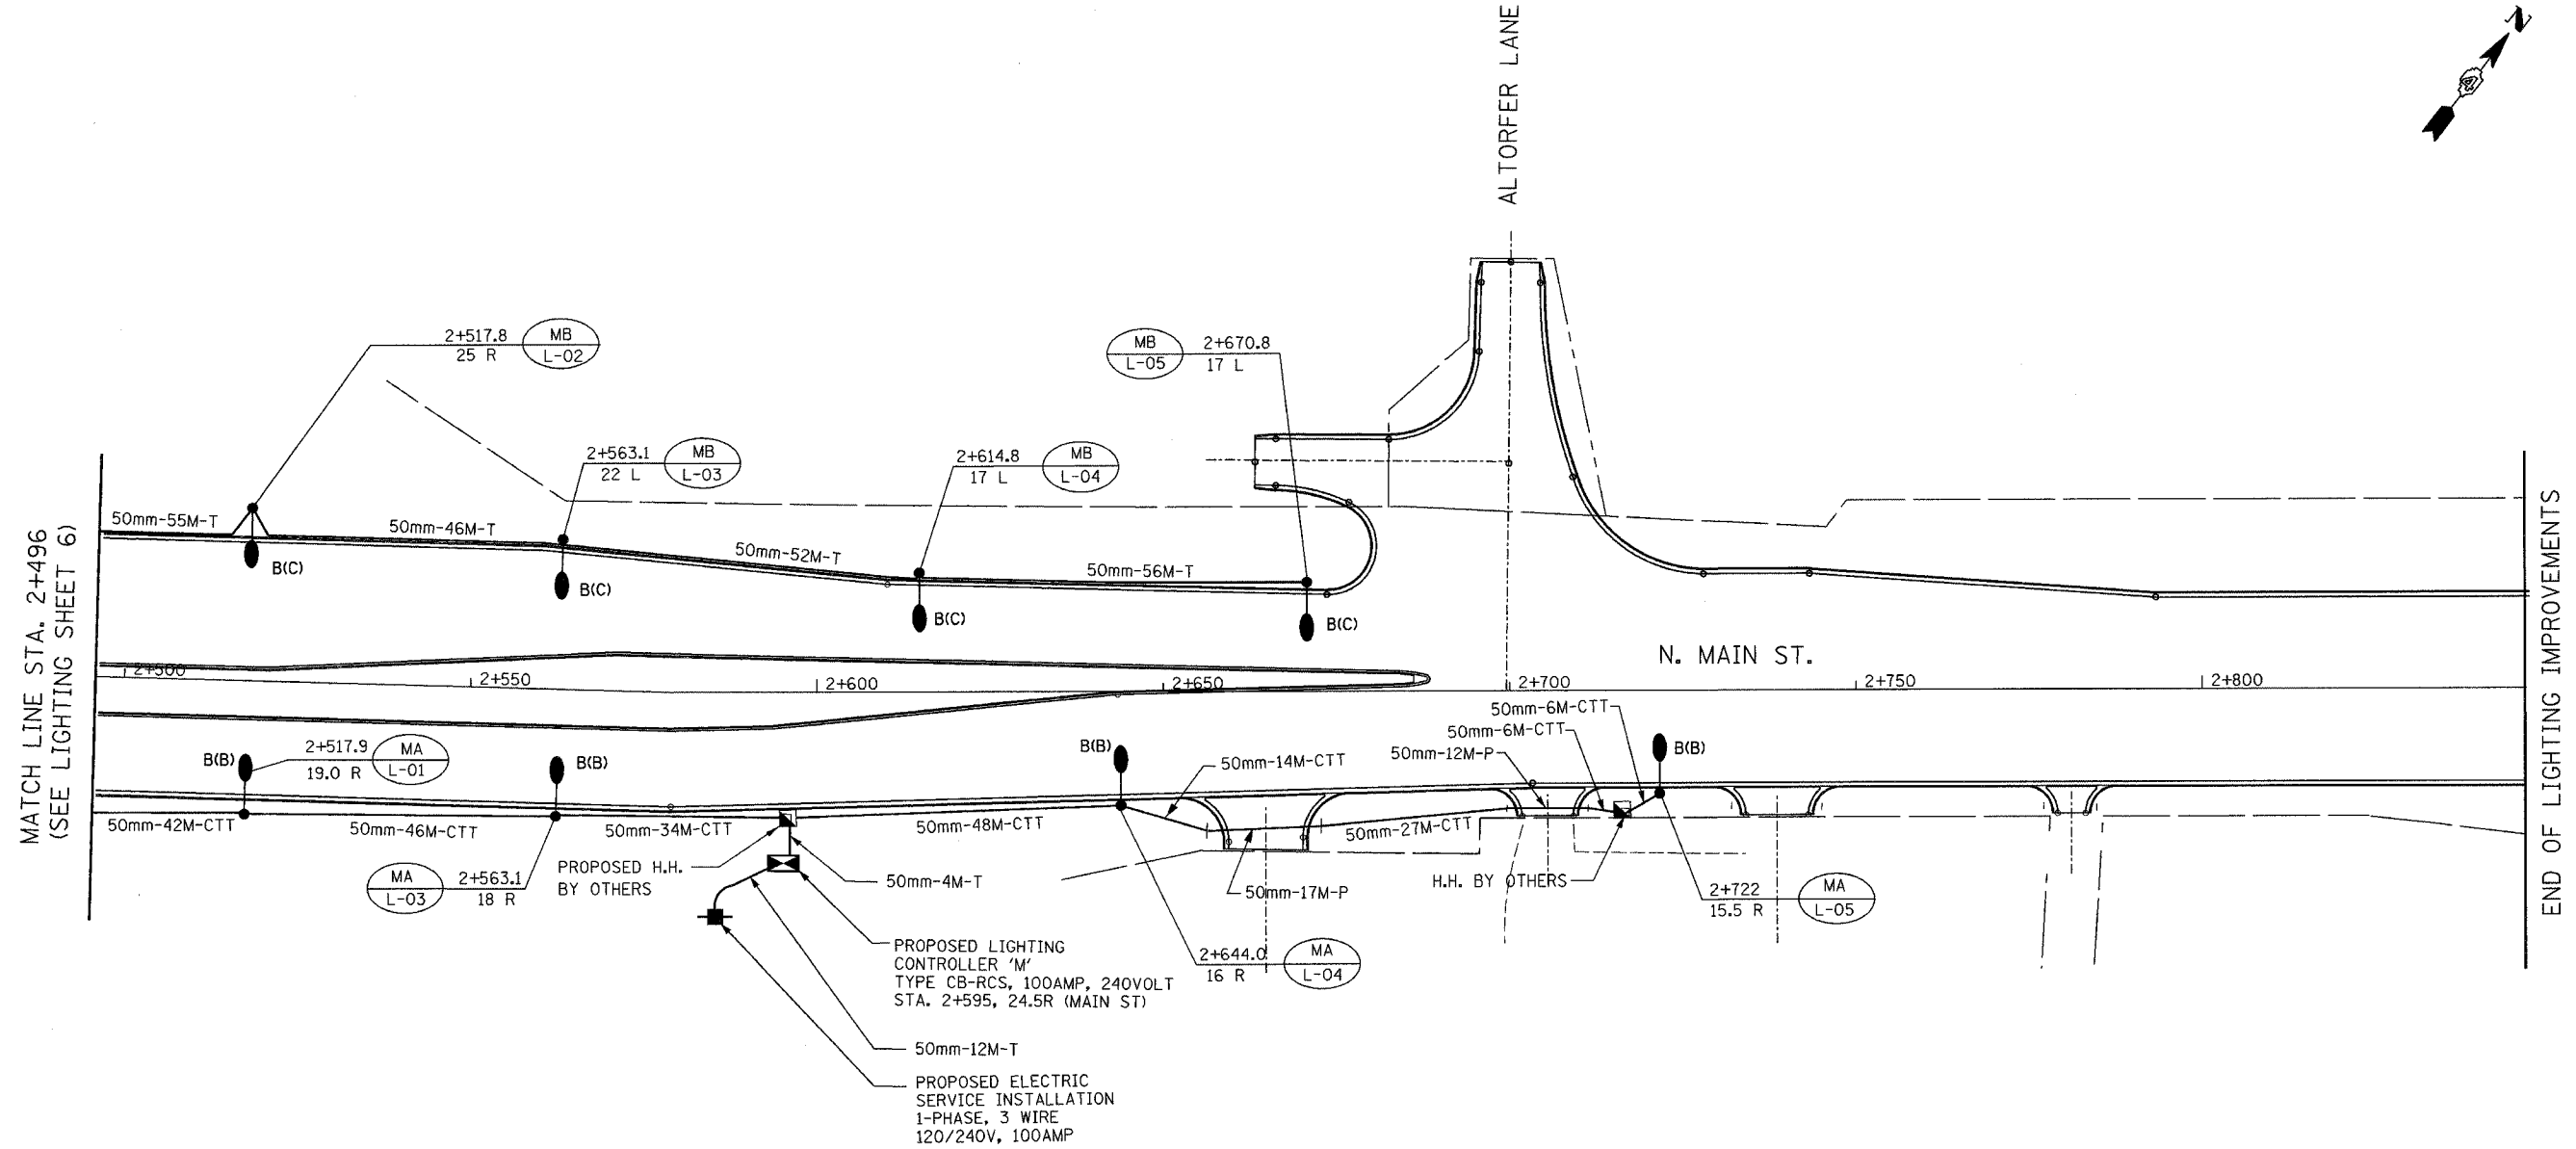


F.A.I. RTE.	SECTION	COUNTY	TOTAL SHEETS	SHEET NO.
74		TAZEWELL	1366	1222
STA.		TO STA.		
FED. ROAD DIST. NO.		ILLINOIS FED. AID PROJECT		
		• (90-11R-2)90(13, 14, 14-DR-1		
CONTRACT NO. 68201				

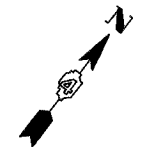

STREET LIGHTING - BILL OF MATERIALS - THIS SHEET

PAY ITEM	UNIT	QUANTITY
ELECTRIC SERVICE INSTALLATION	EACH	1
LIGHTING CONTROLLER TYPE CB-RCS 100AMP-240VOLT	EACH	1
LUMINAIRE, SODIUM VAPOR, HORIZONTAL MOUNT, 400 WATT	EACH	8
CONDUIT IN TRENCH, 50MM DIA., PVC	METER	448.0
CONDUIT PUSHED, 50MM DIA., PVC	METER	29.0
TRENCH AND BACKFILL FOR ELECTRICAL WORK	METER	225.0
LIGHT POLE, ALUMINUM, TRANSFORMER BASE, 13.5M M.H., 2.4M DAVIT ARM	EACH	8
LIGHT POLE FOUNDATION, 600mm DIAMETER	EACH	20.0



**ab** **alfred benesch & company**  
CONSULTING ENGINEERS  
205 NORTH MICHIGAN AVENUE, CHICAGO, ILLINOIS 60601

REVISIONS	
NAME	DATE

ILLINOIS DEPARTMENT OF TRANSPORTATION  
PROPOSED LIGHTING PLAN  
N. MAIN ST.  
STA. 2+496 TO STA. 2+847  
DRAWN BY DJK  
CHECKED BY MKR  
DATE: 12/20/04

m:\pco\13573\LIGHTING\Contract\111103-7\main.dwg  
 1:58:48 PM  
 12/20/2004