

INDEX OF SHEETS AND STANDARDS

SHEET NO.	TITLE
1.	COVER SHEET, INDEX TO SHEETS, AND HIGHWAY STANDARDS
2.	LEGEND, ABBREVIATIONS AND HIGHWAY STANDARDS
3.	GENERAL NOTES
4.-5.	SUMMARY OF QUANTITIES
6.-8.	SCHEDULE OF MATERIALS
9.	STRUCTURAL DESIGN DATA AND TYPICAL SECTIONS
10.-11.	ALIGNMENT AND TIES AND BENCHMARKS
12.	MAINTENANCE OF TRAFFIC PLAN - STAGE I
13.	MAINTENANCE OF TRAFFIC PLAN - STAGE II
14.	MAINTENANCE OF TRAFFIC PLAN - STAGE III
15.-21.	GEOMETRIC PLAN: U.S. ROUTE 52
22.-24.	GEOMETRIC PLAN: RIVER ROAD
25.-31.	DRAINAGE AND UTILITY PLAN: U.S. ROUTE 52
32.-34.	DRAINAGE AND UTILITY PLAN: RIVER ROAD
35.	TEMPORARY EROSION CONTROL PLAN: U.S. ROUTE 52
36.	TEMPORARY EROSION CONTROL PLAN: RIVER ROAD
37.	PAVEMENT MARKING AND LANDSCAPING PLAN: U.S. ROUTE 52
38.	PAVEMENT MARKING AND LANDSCAPING PLAN: RIVER ROAD AND RAVEN ROAD
39.-42.	DISTRICT 1 STANDARD TRAFFIC DESIGN DETAILS
43.	EXISTING FLASHING BEACON INSTALLATION REMOVAL AND TEMPORARY FLASHING BEACON INSTALLATION PLAN
44.	TRAFFIC SIGNAL INSTALLATION PLAN: U.S. ROUTE 52 AT RIVER ROAD
45.	TRAFFIC SIGNAL CABLE PLAN AND PHASE DESIGNATION DIAGRAM: U.S. ROUTE 52 AT RIVER ROAD
46.	INTERCONNECT PLAN: U.S. ROUTE 52 FROM RIVER ROAD TO BROOKSHORE DRIVE
47.	INTERCONNECT SCHEMATIC AND SCHEDULE OF QUANTITIES: U.S. ROUTE 52 FROM RIVER ROAD TO I-55 EAST FRONTAGE ROAD
48.	MAST ARM MOUNTED STREET NAME SIGNS
49.	LIGHTING PLAN: ONE-LINE DIAGRAM
50.-52.	LIGHTING PLAN: U.S. ROUTE 52
53.	LIGHTING PLAN: RIVER ROAD
54.-55.	LIGHTING DETAILS
56.	HAMMEL CREEK - BOX CULVERT PLAN
57.	HAMMEL CREEK - BOX CULVERT SECTIONS
58.	HAMMEL CREEK - BOX CULVERT DETAILS
59.	U.S. ROUTE 52 - BOX CULVERT PLAN AND DETAILS
60.	U.S. ROUTE 52 - BOX CULVERT SECTION
61.	RIVER ROAD - BOX CULVERT PLAN AND DETAILS
62.	RIVER ROAD - BOX CULVERT SECTIONS
63.	U.S. ROUTE 52 & RIVER ROAD - BOX CULVERT DETAILS
64.	DISTRICT 1 BUTT JOINT AND BITUMINOUS TAPER DETAILS
65.	DISTRICT 1 TRAFFIC CONTROL AND PROTECTION FOR SIDE ROADS, INTERSECTIONS AND DRIVEWAYS
66.	DISTRICT 1 PAVEMENT PATCHING FOR BITUMINOUS SURFACED PAVEMENT
67.	DISTRICT 1 DRIVEWAY DETAILS DISTANCE BETWEEN R.O.W. AND FACE OF CURB/EDGE OF SHOULDER
68.	DISTRICT 1 TYPICAL APPLICATIONS RAISED REFLECTIVE PAVEMENT MARKERS (SNOW FLOW RESISTANT)
69.	DISTRICT 1 TYPICAL PAVEMENT MARKING DETAILS
70.	DISTRICT 1 TEMPORARY PAVEMENT MARKING LETTERS AND SYMBOLS FOR TRAFFIC STAGING
71.	DISTRICT 1 SIGNING FOR FLAGGING OPERATIONS AT WORK ZONE OPENINGS
72.	DISTRICT 1 TEMPORARY INFORMATION SIGNING
73.	DISTRICT 1 BENCHING DETAIL FOR ENMBANKMENT WIDENING
74.	DISTRICT 1 MANHOLE WITH RESTRICTOR PLATE
75.-82.	CROSS SECTIONS: U.S. ROUTE 52
83.-85.	CROSS SECTIONS: RIVER ROAD

STANDARD NO. HIGHWAY STANDARDS  
SEE SHT. NO. 2 FOR STANDARDS

TRAFFIC DATA  
U.S. ROUTE 52  
POSTED OR DESIGN SPEED = 40 MPH  
2015 ADT = 12,000

RIVER ROAD  
POSTED OR DESIGN SPEED = 40 MPH  
2015 ADT = 7,000

DESIGN DESIGNATION  
U.S. ROUTE 52: 12,000 (22) ARTERIAL 3.83 (B=20)  
RIVER ROAD: 7,000 (22) COLLECTOR 0.71 (B=20)

1" = 100'  
1" = 10'

1" = 50'

1" = 40'

1" = 30'

1" = 20'

FULL SIZE PLANS HAVE BEEN PREPARED USING STANDARD ENGINEERING SCALES. REDUCED SIZED PLANS WILL NOT CONFORM TO STANDARD SCALES. IN MAKING MEASUREMENTS ON REDUCED SIZE PLANS, THE ABOVE SCALES SHALL BE USED.

CONTRACT NO. 83786

STATE OF ILLINOIS  
DEPARTMENT OF TRANSPORTATION  
DIVISION OF HIGHWAYS  
**PLANS FOR PROPOSED  
F.A.P. ROUTE 0607 (U.S. ROUTE 52)(JEFFERSON STREET)  
F.A.U. ROUTE 0356 (RIVER ROAD) TO FAU ROUTE 0375 (RAVEN ROAD)**  
PROJECT NO.: F-0607 (070)  
SECTION NO.: 01-00014-00-FP  
JOB NO.: C-91-371-01  
**ROADWAY WIDENING, RESURFACING, AND TRAFFIC SIGNALS  
VILLAGE OF SHOREWOOD, ILLINOIS  
WILL COUNTY**

PROJECT LIMITS  
LOCATION: U.S. ROUTE 52  
BEGIN CONSTRUCTION  
STA. 19+14



R. 9. E.

PROJECT LIMITS  
LOCATION: RIVER ROAD  
BEGIN CONSTRUCTION  
STA. 50+45

STA. 55+00.21 RIVER ROAD  
STA. 24+92.09 U.S. ROUTE 52



PROJECT LIMITS  
LOCATION: RIVER ROAD  
END CONSTRUCTION  
STA. 58+22

PROJECT LIMITS  
LOCATION: U.S. ROUTE 52  
END CONSTRUCTION  
STA. 51+50

GROSS LENGTH OF IMPROVEMENT = 4,013 LIN. FT. OR 0.76 MILES  
NET LENGTH OF IMPROVEMENT = 4,013 LIN. FT. OR 0.76 MILES




Baxter & Woodman

CALL JULIE 1-800-892-0123  
48 HOURS BEFORE YOU DIG  
EXCLUDING SAT., SUN. & HOLIDAYS

Burlington, Wisconsin 262.763.7834 Crystal Lake, Illinois 815.459.1260 DeKalb, Illinois 815.787.3111 Mokena, Illinois 708.478.2090 Grayslake, Illinois 847.223.5088 Rockford, Illinois 815.489.1551

(OFFICE WHICH PREPARED PLANS)

F.A.P. ROUTE NO.	SECTION	COUNTY	TOTAL SHEETS	SHEET NO.
0607	01-00014-00-FP	WILL	85/1	1
STA.	TO STA.			
FED. ROAD DIST. NO.	ILLINOIS	FED AID PROJECT	F-0607 (070)	
CONTRACT NO.: 83786				

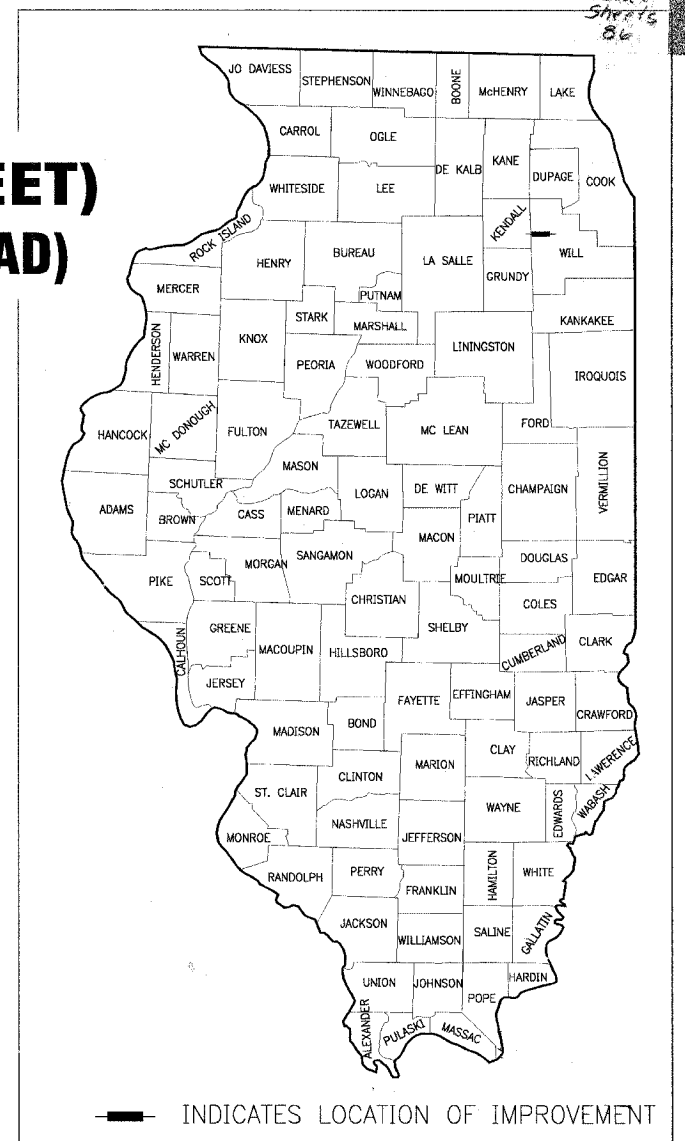

INDICATES LOCATION OF IMPROVEMENT

PROJECT MANAGER: [Signature] 12/27/04  
STRUCTURAL ENGINEER: [Signature]  
"LICENSE EXPIRES 11-30-05"

BAXTER & WOODMAN, INC.  
STATE OF ILLINOIS - PROFESSIONAL DESIGN FIRM  
LICENSE NO. - 184-001121 - EXPIRES 4/30/2005  
DATE: 12-21-04

STATE OF ILLINOIS  
DEPARTMENT OF TRANSPORTATION  
DIVISION OF HIGHWAYS

APPROVED: [Signature] 20 04 LOCAL AGENCY REPRESENTATIVE  
APPROVED: [Signature] January 10, 20 05 LOCAL ROADS ENGINEER  
APPROVED: [Signature] January 10, 20 05 DISTRICT ENGINEER

PRINTED BY THE AUTHORITY OF THE STATE OF ILLINOIS

SCHAUMBURG, IL. 708-705-4406 CHAD RIDDLE, P.E. I.D.O.T. FEDERAL AID DESIGN ENGINEER

108520-RDWG 10/20/04 11:57 BY: DEK  
COPYRIGHT © 2004 BY BAXTER & WOODMAN, INC.  
ALL RIGHTS RESERVED. NO PART OF THESE DRAWINGS  
MAY BE REPRODUCED OR TRANSMITTED IN ANY FORM  
WITHOUT PERMISSION OF BAXTER & WOODMAN, INC.