


LOCATION 4 STRUCTURE NO. 029-0021


IL 78 & 97

OVER LACY DITCH
INFORMATION ONLY

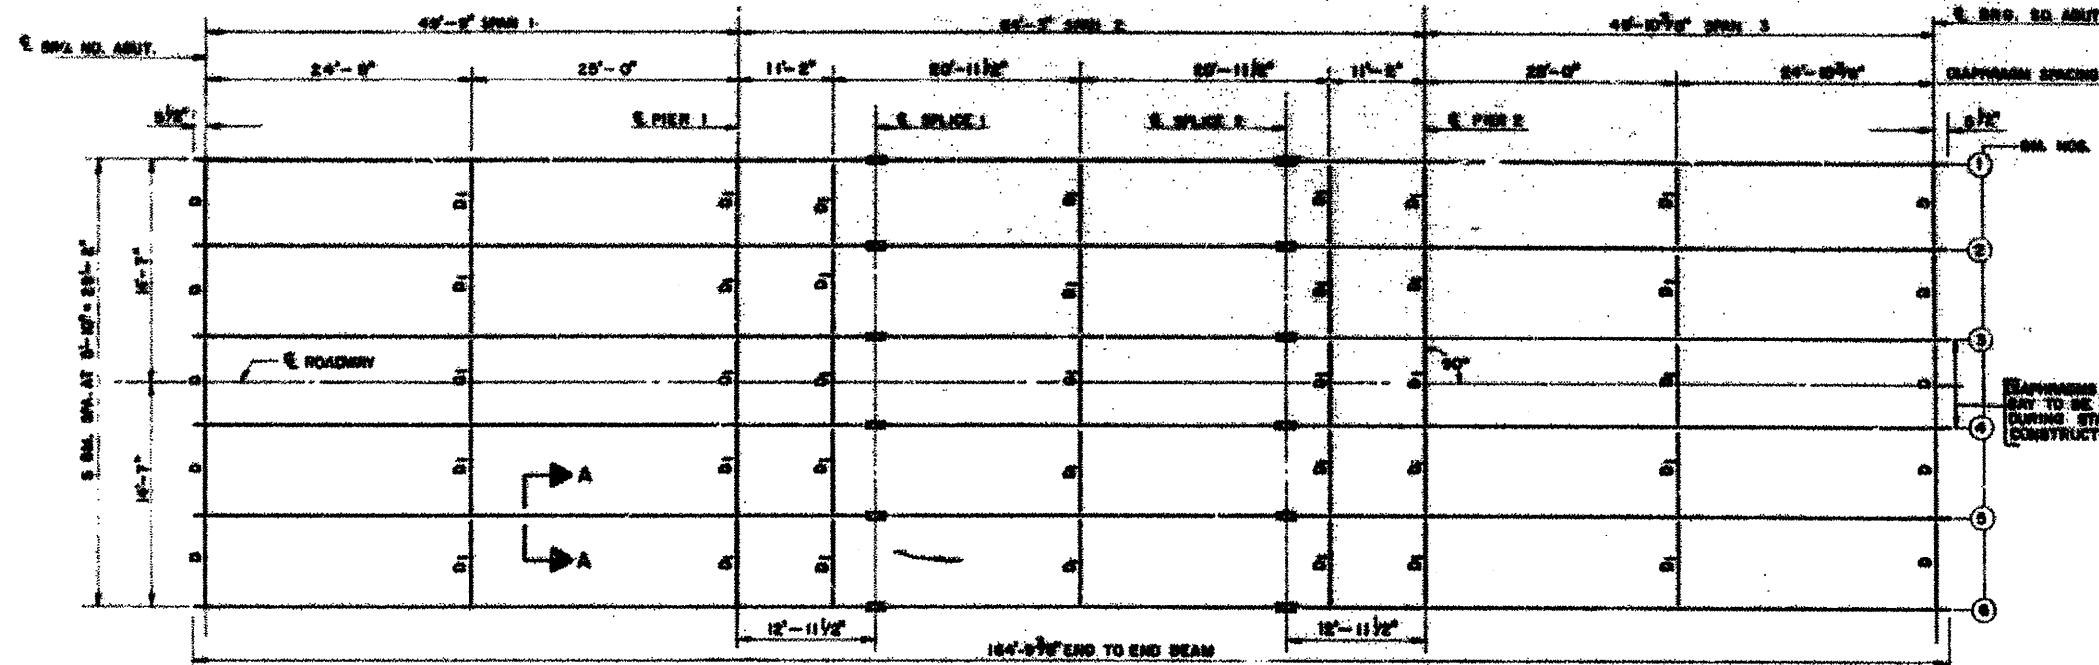


FRAMING PLAN

D- END DIAPHRAGM (W12 x 40)
D1- INTERIOR DIAPHRAGM (W10 x 26)

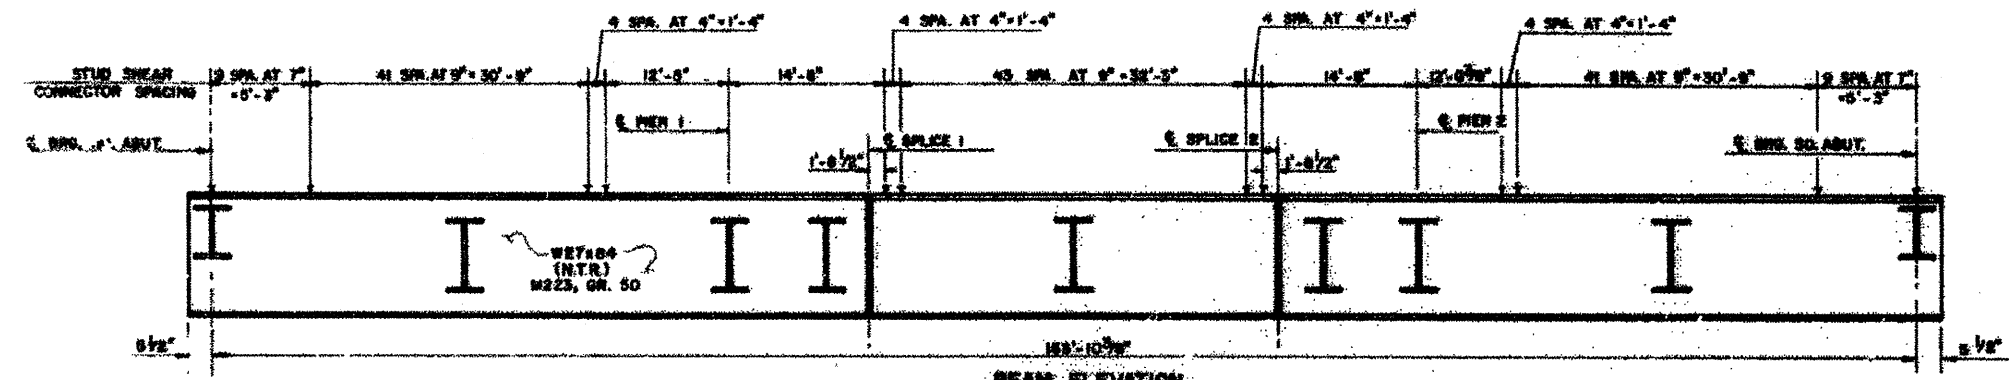


BEAM ELEVATION

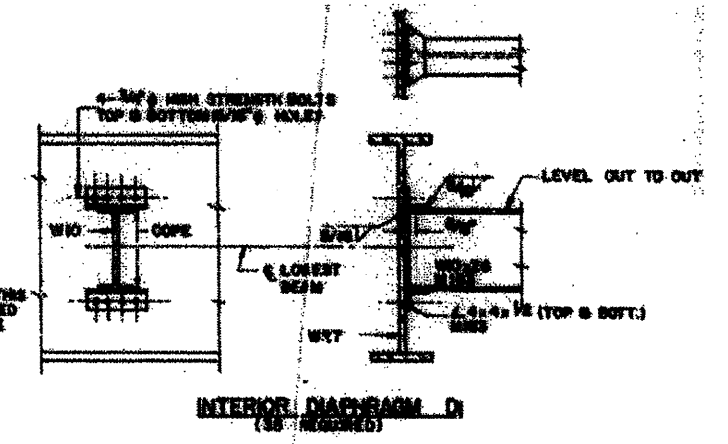

INTERIOR DIAPHRAGM D1
(36 REQUIRED)

NOTE: HARDENED WASHERS
SHALL BE REQUIRED
OVER ALL HOLES IN
DIAPHRAGM CONNECTIONS.

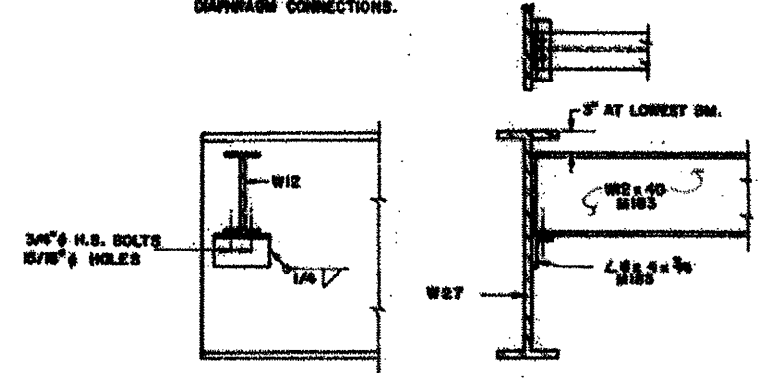

END DIAPHRAGM D
(10 REQUIRED)

FILE NAME = 68996 4-29-2011.dgn	USER NAME = inglistj	DESIGNED - DRAWN -	REVISED - REVISED -	STATE OF ILLINOIS DEPARTMENT OF TRANSPORTATION	SCALE: _____	SHEET NO. _____ OF _____ SHEETS	STA. _____ TO STA. _____	F.A. RTE. var	SECTION D4 Bridge Metalizing 201	COUNTY FULTON	TOTAL SHEETS 19	SHEET NO. 18
PLOT SCALE = 28.7998' / IN.		CHECKED -	REVISED -		CONTRACT NO. 68996				ILLINOIS FED. AID PROJECT			
PLOT DATE = 2/14/2011		DATE -	REVISED -									