
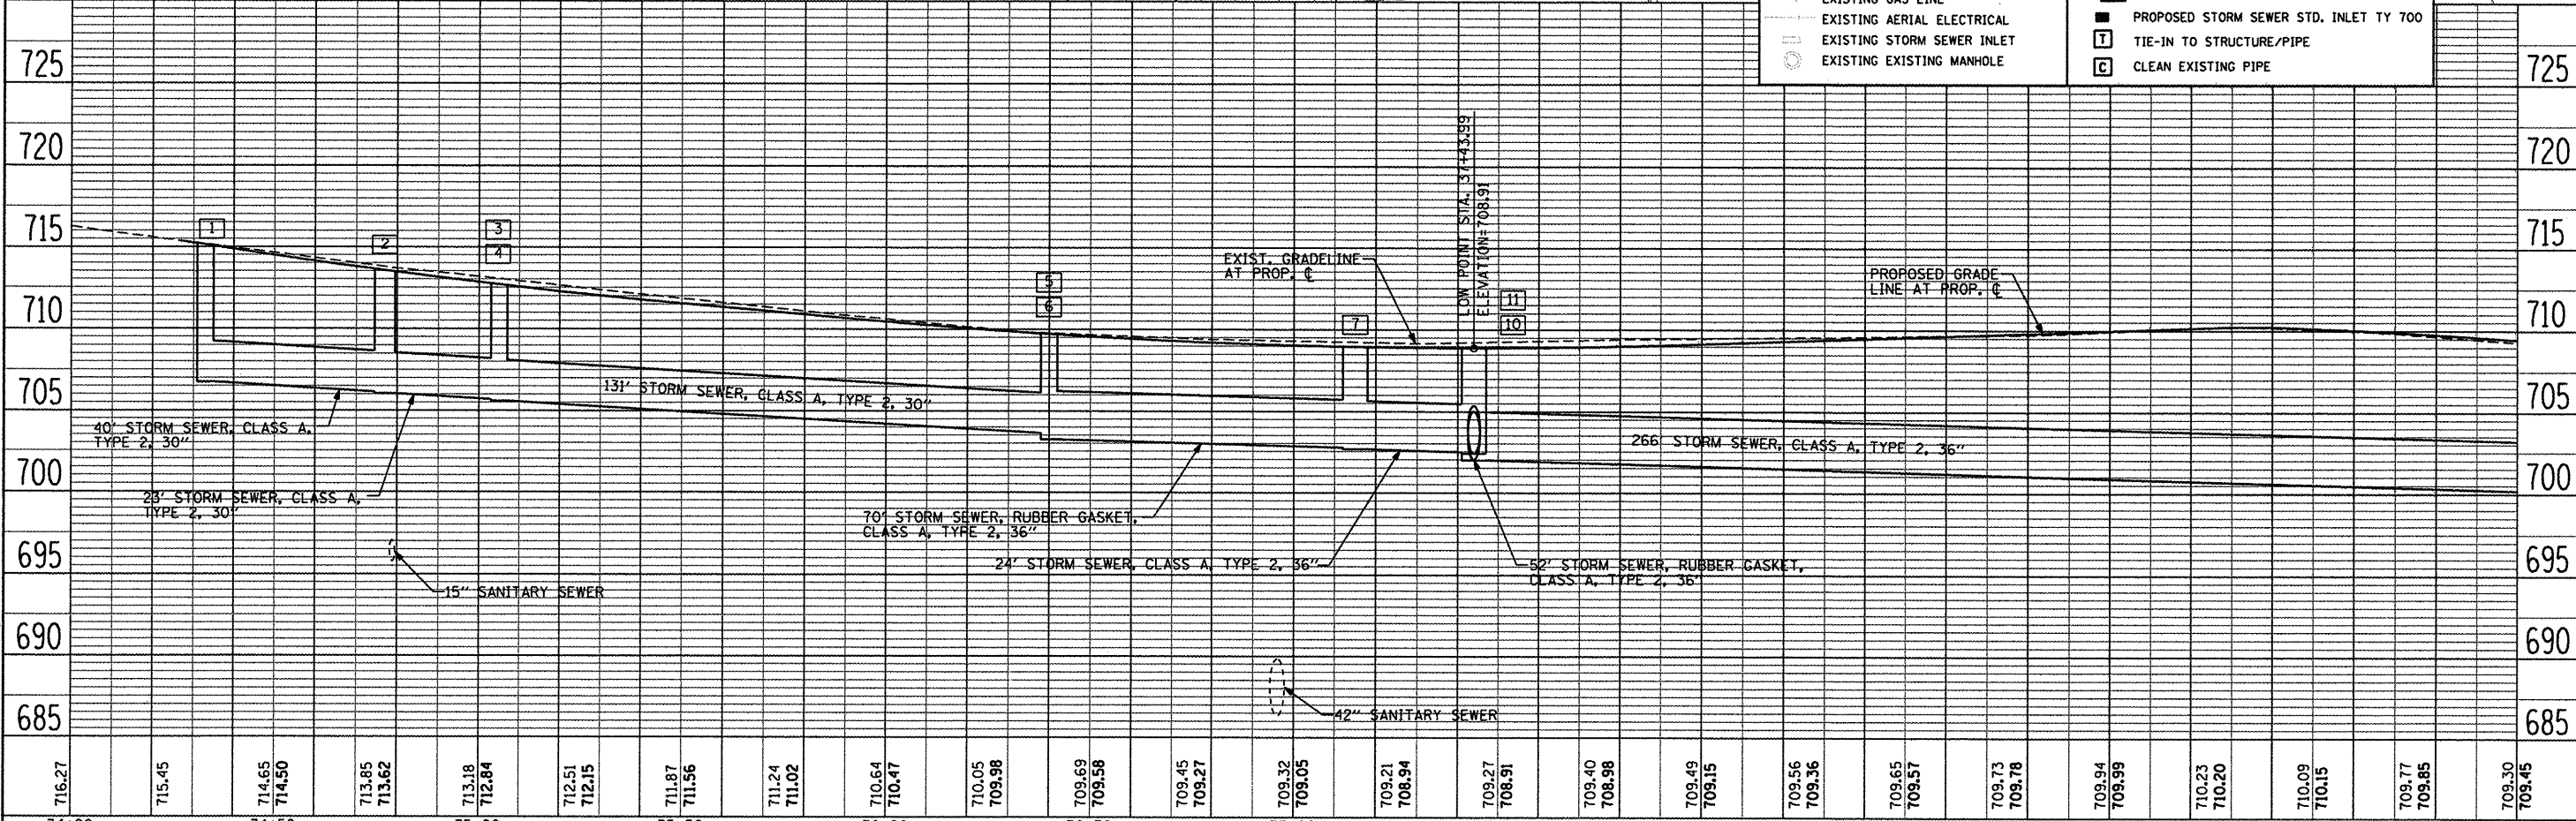


DATE	
BY	
CHECKED	
DESIGNED	
DRAWN	
NOTED	
NO.	

DATE	
BY	
CHECKED	
DESIGNED	
DRAWN	
NOTED	
NO.	

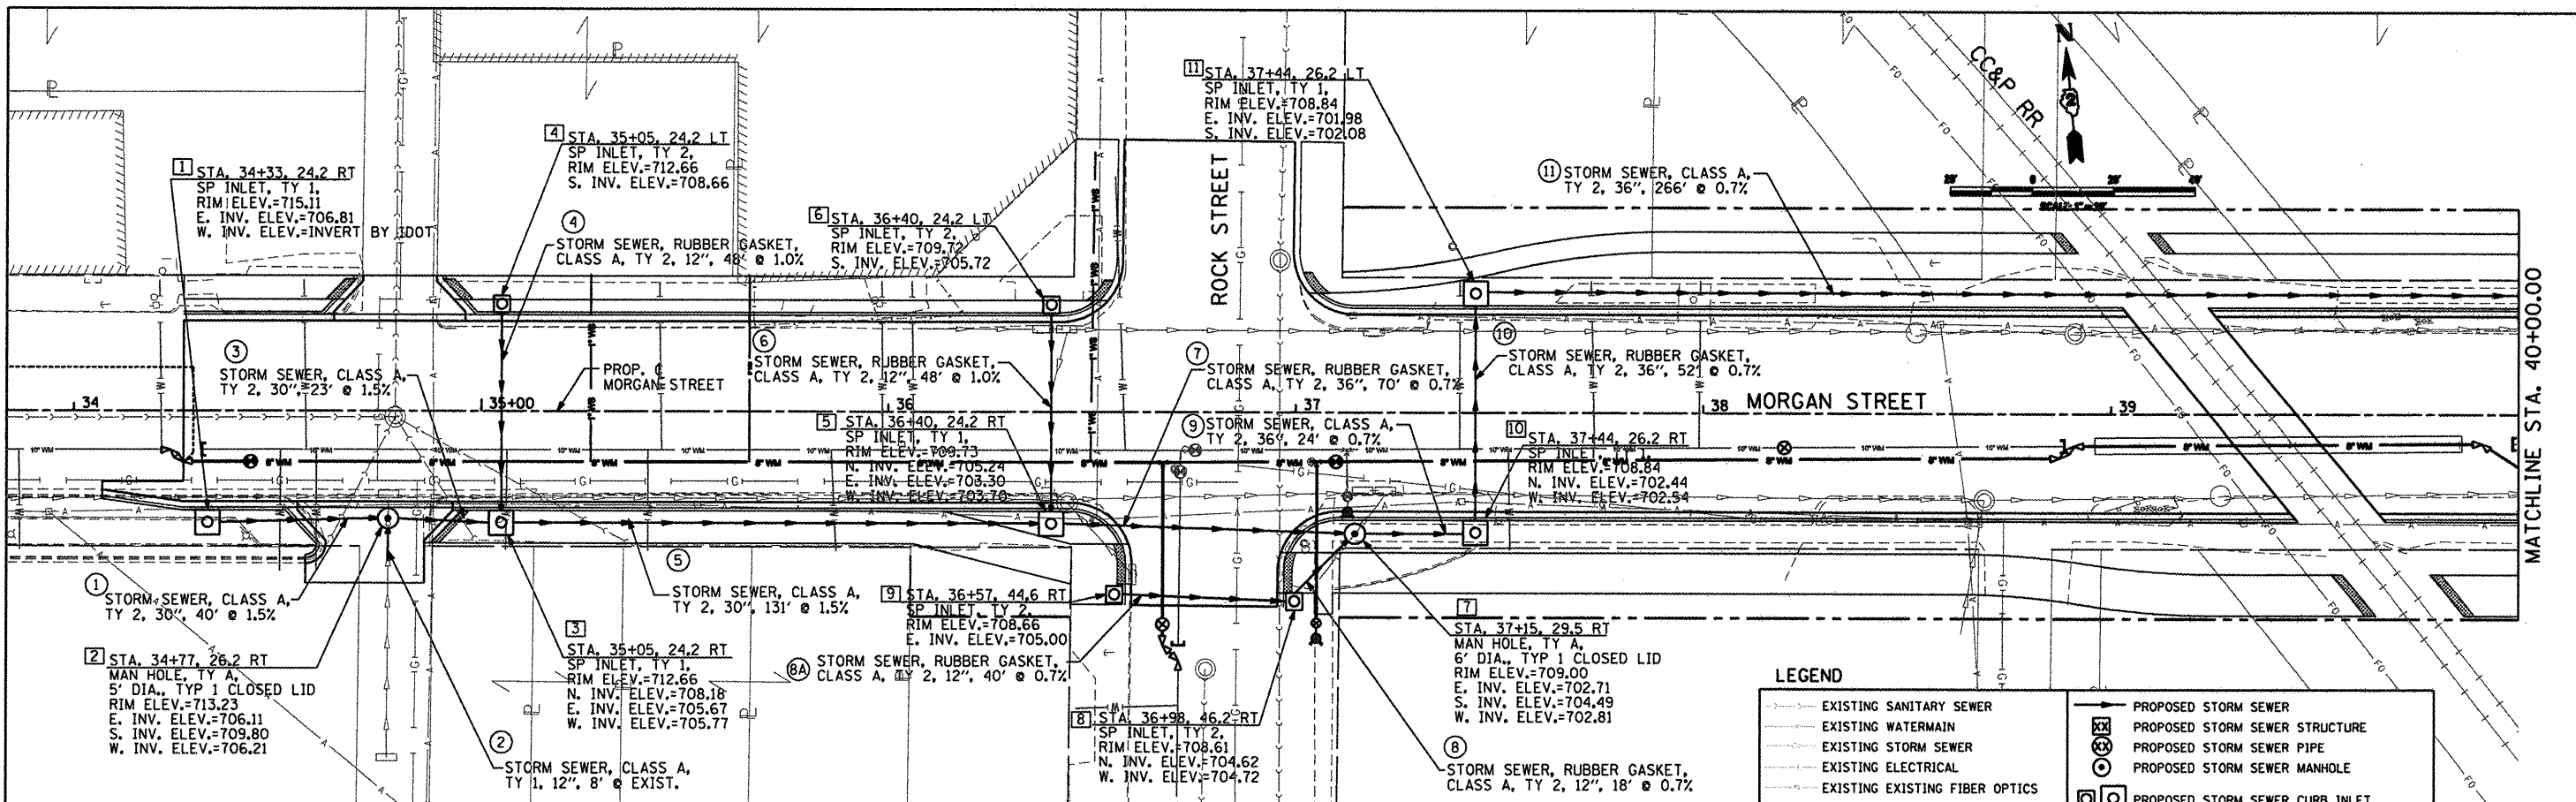

LEGEND

	EXISTING SANITARY SEWER		PROPOSED STORM SEWER STRUCTURE
	EXISTING WATERMAIN		PROPOSED STORM SEWER PIPE
	EXISTING STORM SEWER		PROPOSED STORM SEWER MANHOLE
	EXISTING ELECTRICAL		PROPOSED STORM SEWER CURB INLET
	EXISTING EXISTING FIBER OPTICS		PROPOSED STORM SEWER STD. INLET TY 700
	EXISTING GAS LINE		TIE-IN TO STRUCTURE/PIPE
	EXISTING AERIAL ELECTRICAL		CLEAN EXISTING PIPE
	EXISTING STORM SEWER INLET		
	EXISTING EXISTING MANHOLE		

716.27	715.45	714.65	713.85	713.18	712.51	711.87	711.24	710.64	710.05	709.69	709.45	709.32	709.21	709.27	709.40	709.49	709.56	709.65	709.73	709.94	710.23	710.09	709.77	709.30
34+00	34+50	35+00	35+50	36+00	36+50	37+00	37+50	38+00	38+50	39+00	39+50	40+00	40+00	40+00	40+00	40+00	40+00	40+00	40+00	40+00	40+00	40+00	40+00	40+00



USER NAME = Steve Prange	DESIGNED SJP / MNB	REVISED -
PLOT SCALE = 40,0000 / IN.	DRAWN ERD	REVISED -
PLOT DATE = 02/04/11	CHECKED SJP	REVISED -
	DATE 02/04/2011	REVISED -

**CITY OF ROCKFORD
MORGAN STREET BRIDGE**

**PROPOSED DRAINAGE PLAN & PROFILE
MORGAN STREET / COLLEGE AVENUE**

SCALE: 1" = 20' SHEET NO. 1 OF 11 SHEETS STA. 34+00 TO STA. 40+00

F.A. RTE.	SECTION	COUNTY	TOTAL SHEETS
5077	99-00493-00-BR	WINNEBAGO	253 / 42
CONTRACT NO. 85529		FED. AID PROJECT BRM-50994651	