
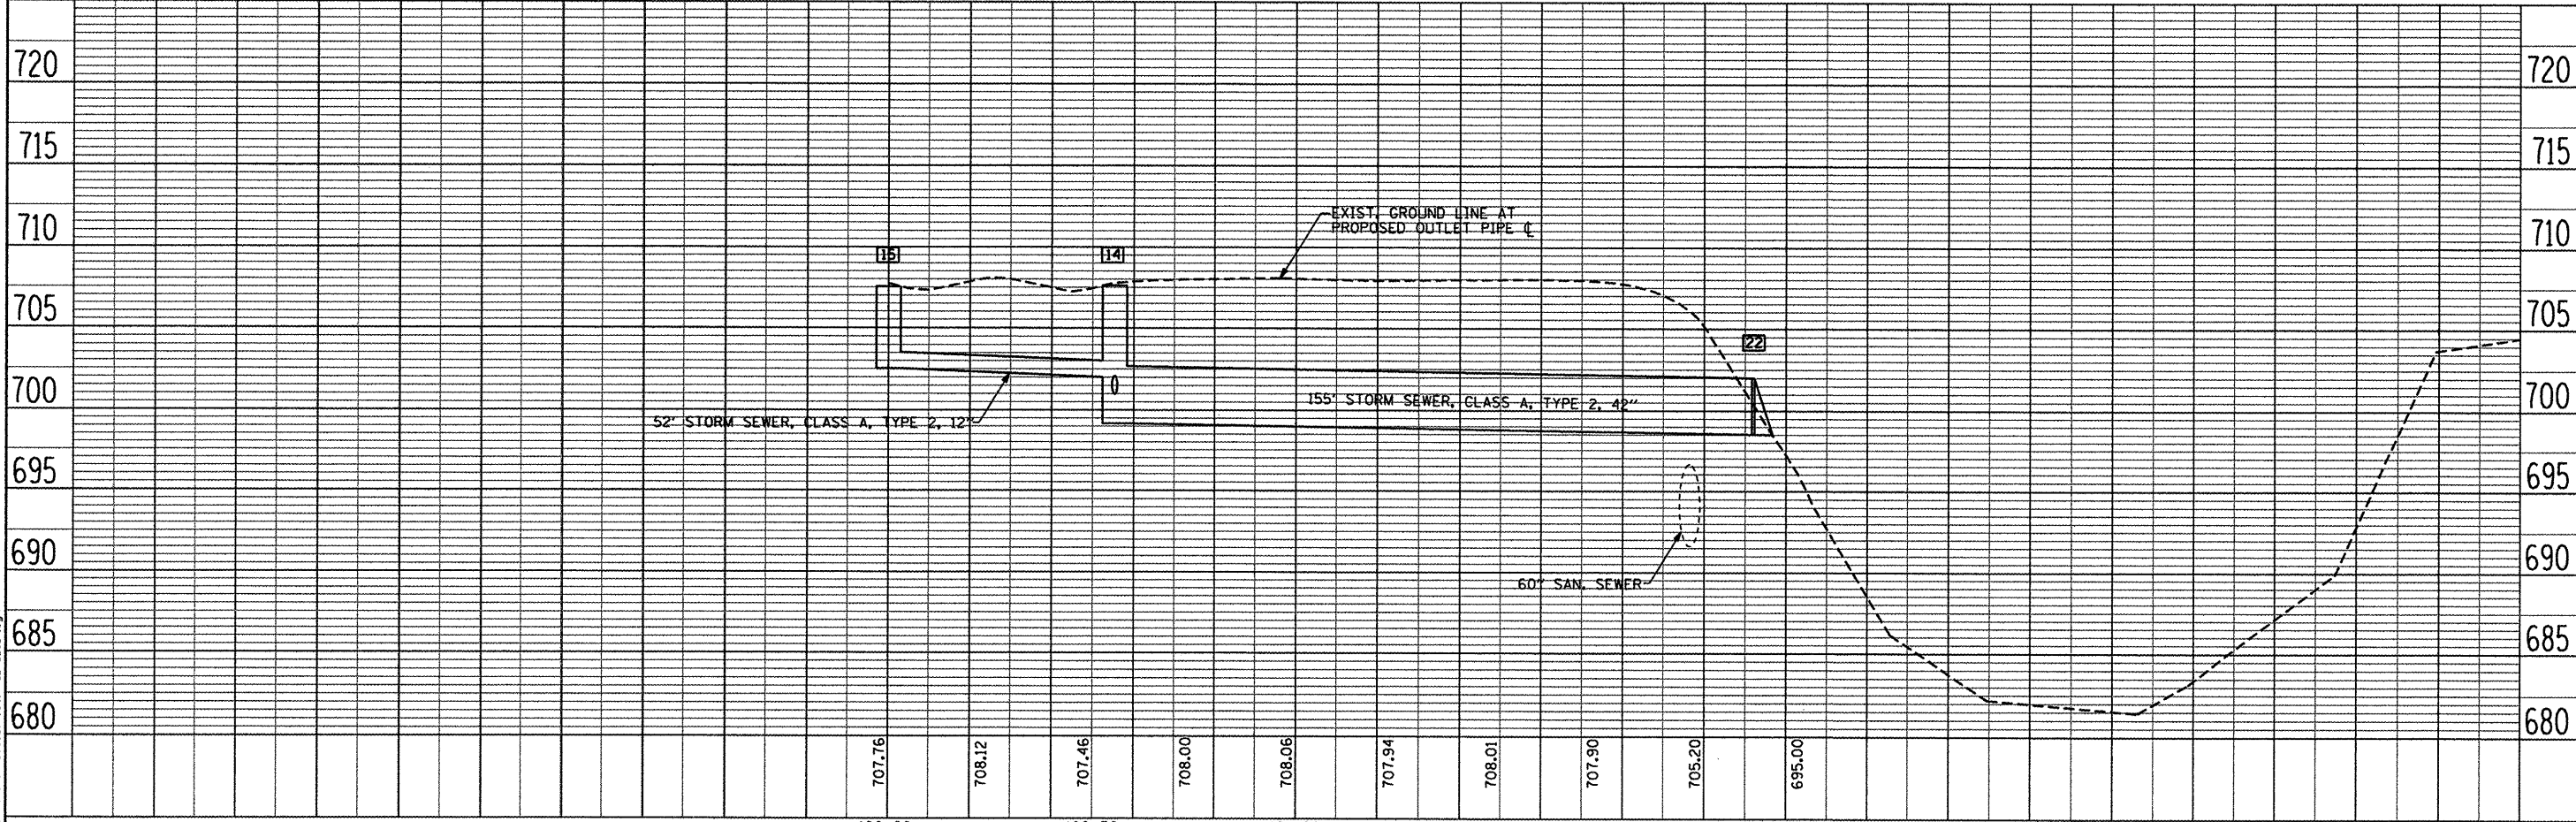


DATE	
BY	
PLANNED	
CHECKED	
ALIGNED	
ASSEMBLED	
FILED	
NO.	
PLAN	
NO.	

DATE	
BY	
DESIGNED	
CHECKED	
GRADES	
PLOTTED	
STRUCTURE	
NOTATION	
NO.	
PROFILE	
NO.	

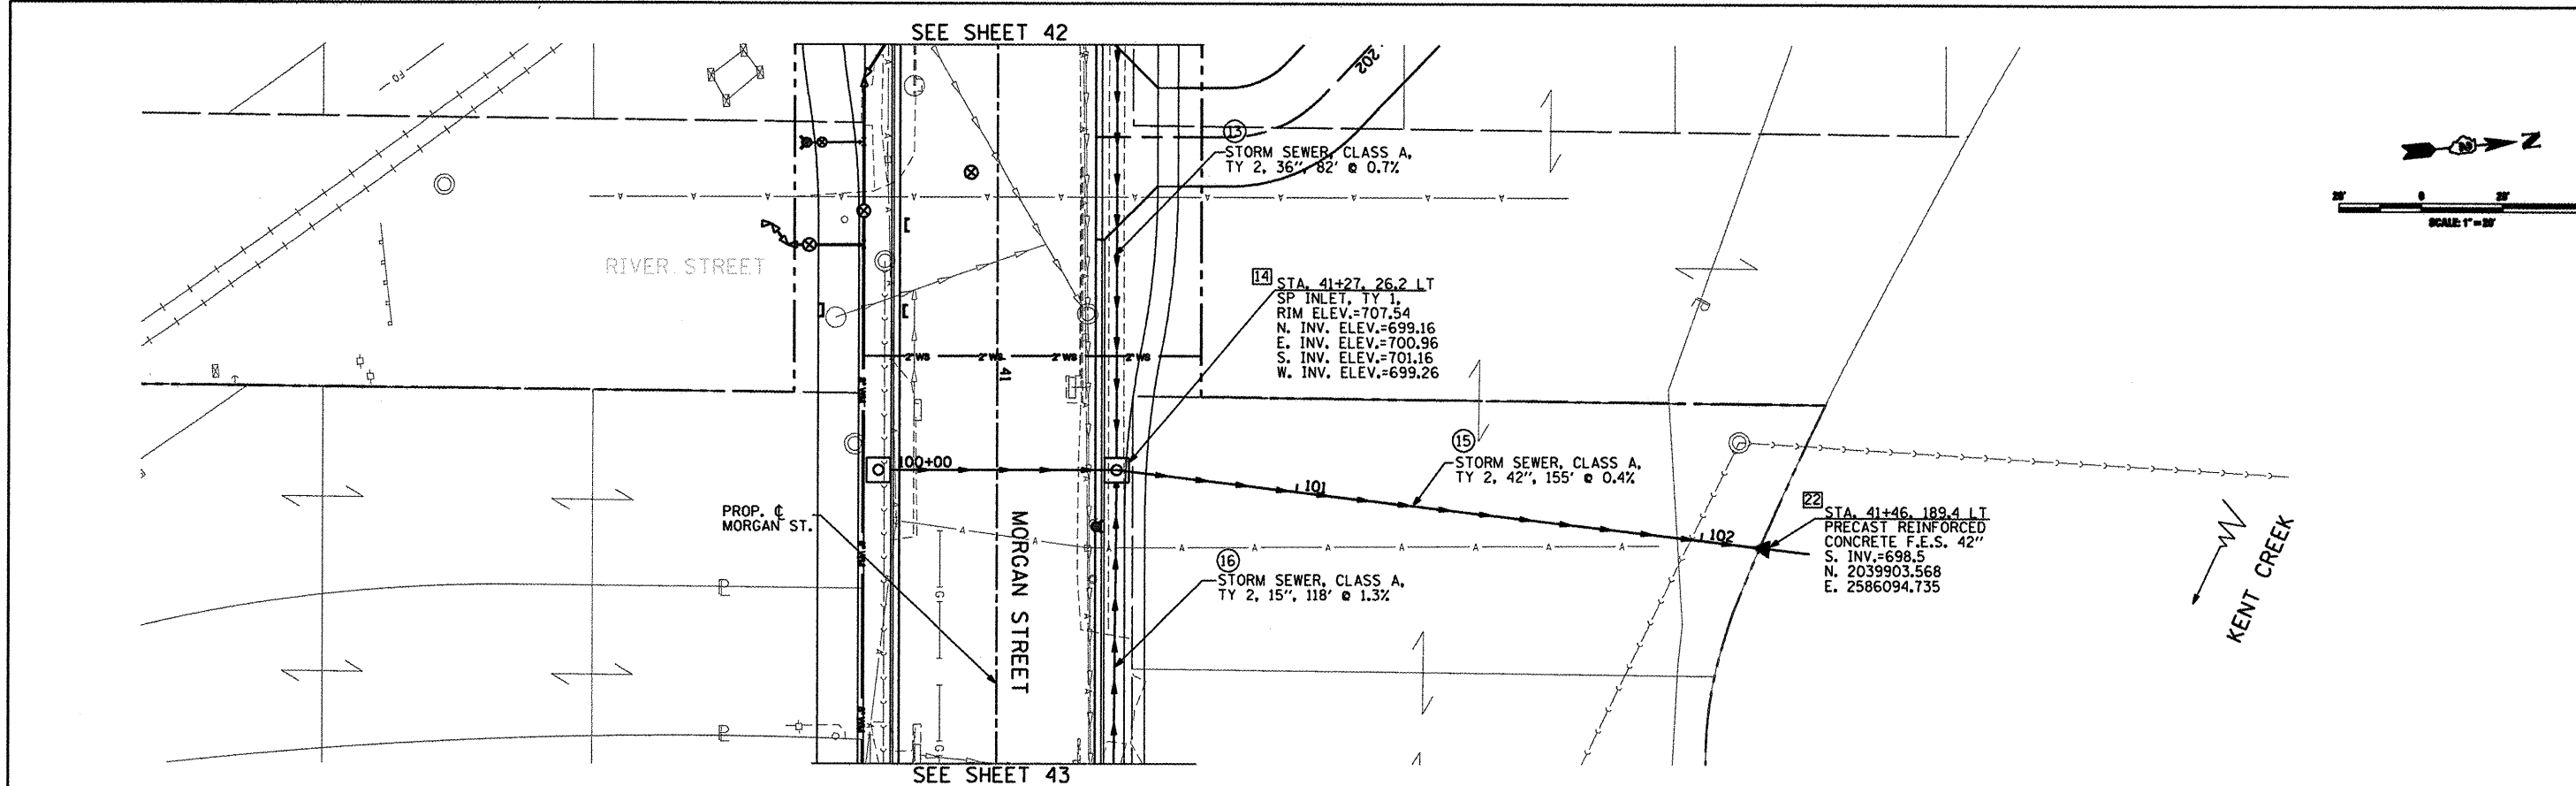

In:\rock\c\04\85529\2\plan\add\morgans\100-28\_9.dgn

<p><b>CMT</b> CRAWFORD, MURPHY &amp; TILLY, INC. CONSULTING ENGINEERS License No. 184-00063</p>	USER NAME = Steve Prange	DESIGNED SJP / MNB	REVISED -	<b>CITY OF ROCKFORD</b> <b>MORGAN STREET BRIDGE</b>	<b>PROPOSED DRAINAGE PLAN &amp; PROFILE</b> <b>OUTLET (KENT CREEK)</b>	F.A. RTE. 5077	SECTION 99-00493-00-BR	COUNTY WINNEBAGO	TOTAL SHEETS 253	SHEET NO. 50			
	PLOT SCALE = 48,0000 "/> IN.	DRAWN ERD	REVISED -			SCALE: 1" = 20'	SHEET NO. 9 OF 11 SHEETS	STA.	TO STA.	CONTRACT NO. 85529			
	PLOT DATE = 02/04/11	CHECKED SJP	REVISED -			FED. ROAD DIST. NO. 2   ILLINOIS							
	DATE 02/04/2011	DATE 02/04/2011	REVISED -			FED. AID PROJECT BRM-5099(6S)							