 

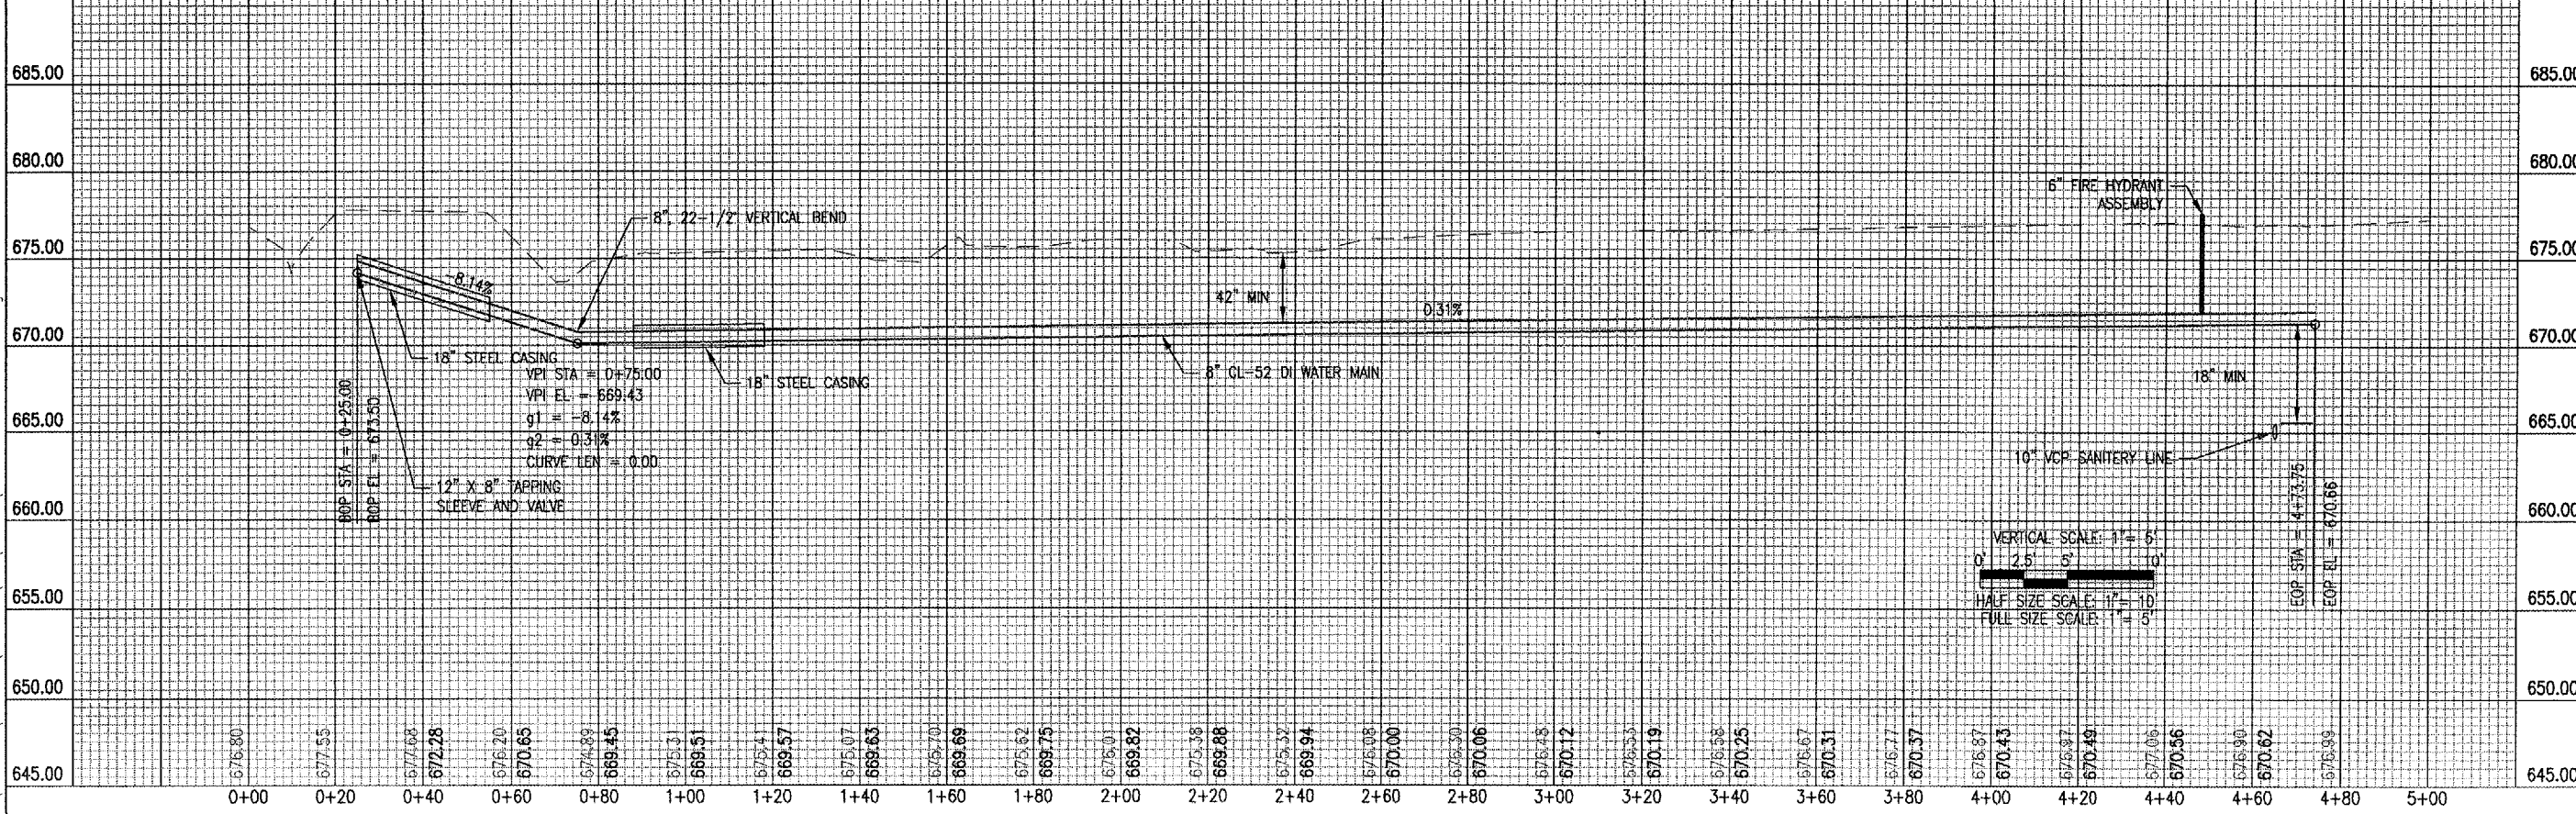


APR 18, 2008 1:31 PM WALLE00723
 I:\AIRPORTS\DECATUR\07A0060\CAD\SHEETS\R-701PWP.DWG - South Leg

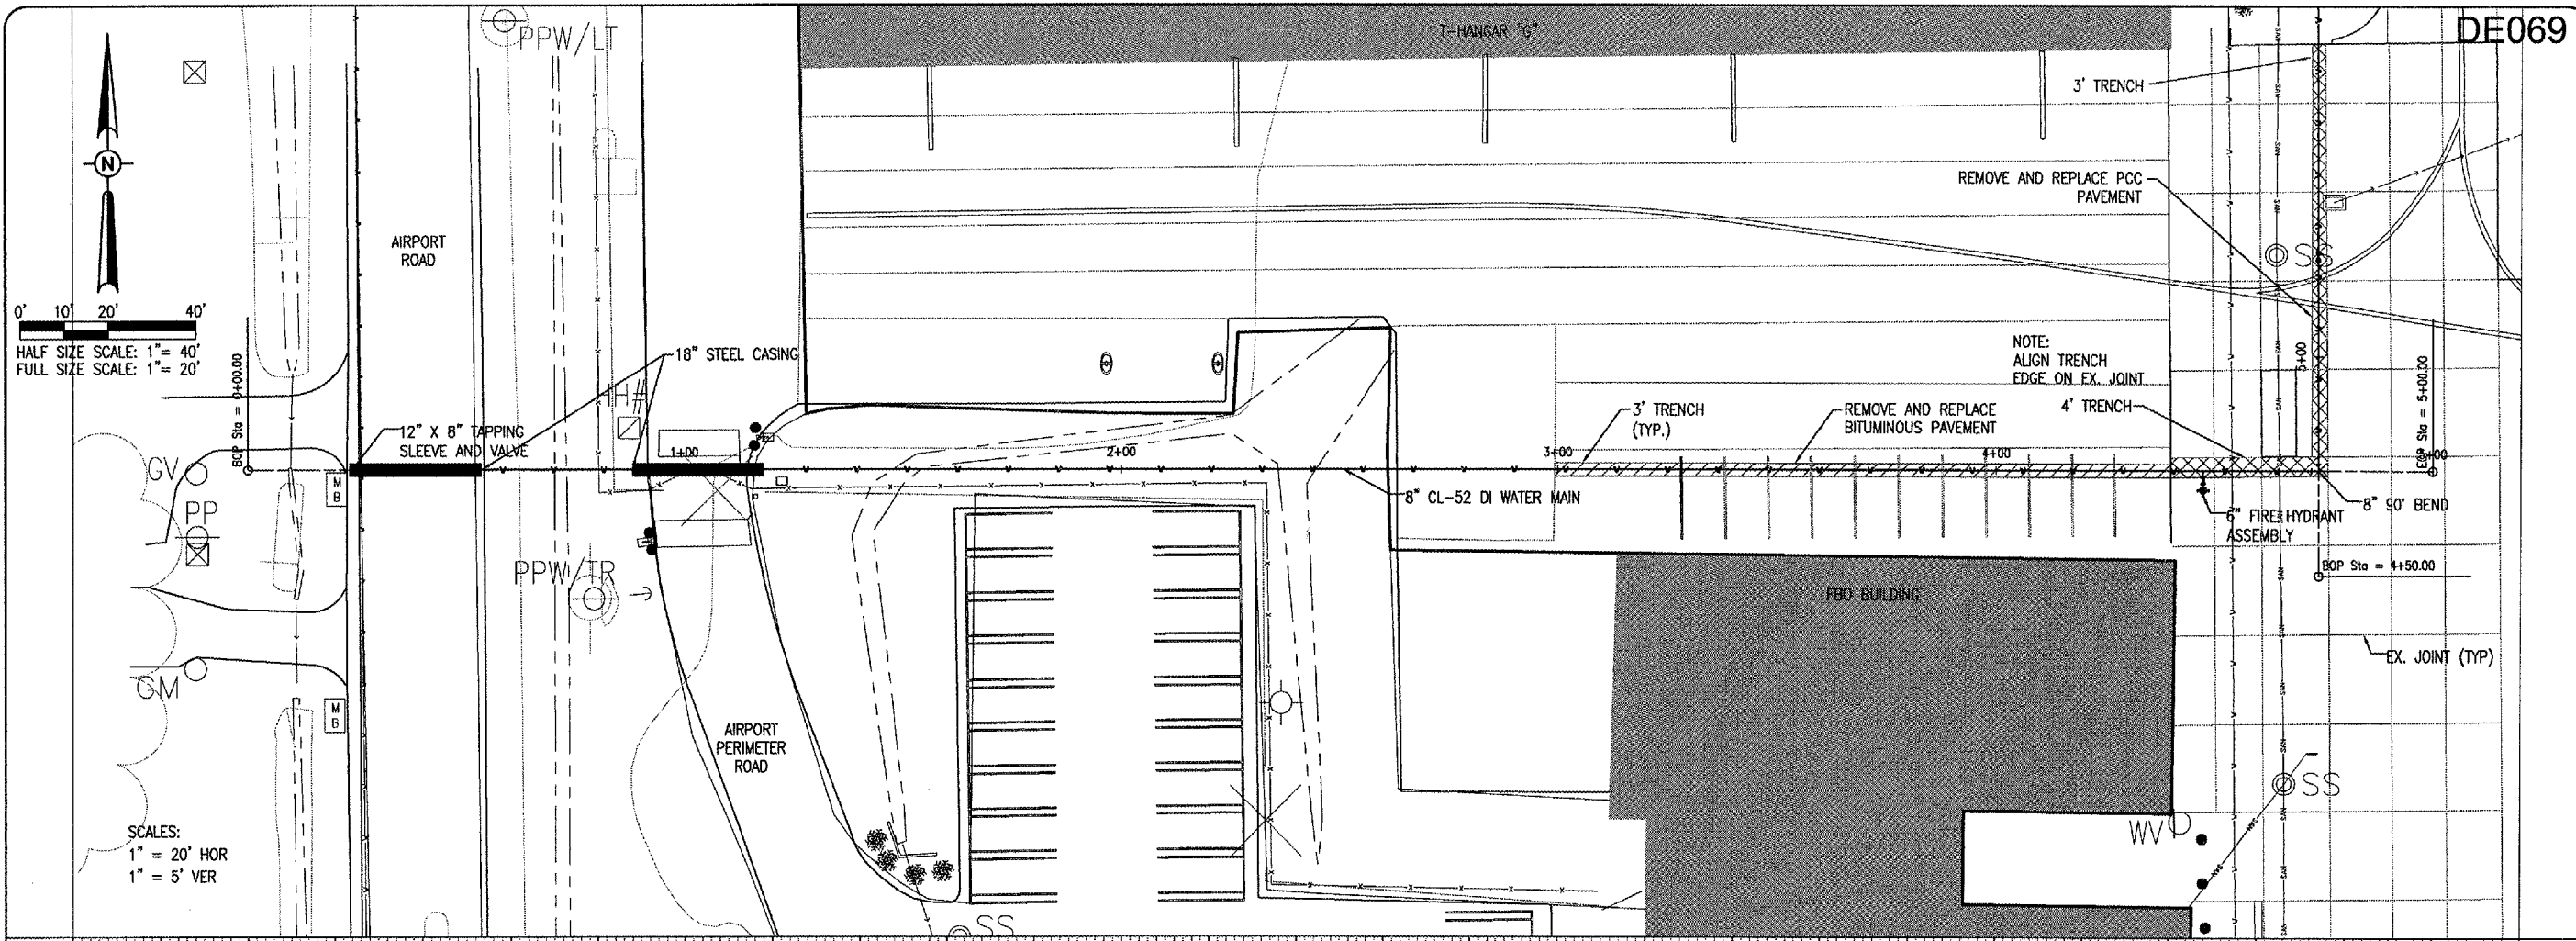

HALF SIZE SCALE: 1" = 40'
 FULL SIZE SCALE: 1" = 20'

SCALES:
 1" = 20' HOR
 1" = 5' VER

DATE	REVISION	BY

DECATUR AIRPORT
DECATUR, ILLINOIS
 IL PROJ. DEC-3801 A.I.P. PROJ. 3-17-0033-XX

REVISION	DATE	BY
LAYOUT	03/14/08	RAW
DRAWN	04/16/08	GRF
REVIEWED	04/16/08	JMR

HANSON
 Hanson Professional Services Inc.
 1025 South Shore Street
 Springfield, IL 62766
 Offices Nationwide

CONSTRUCT
 WATER MAIN
 SOUTH LEG
 PLAN AND PROFILE
 STA. 0+00 TO STA. 5+00