
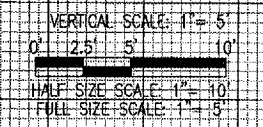
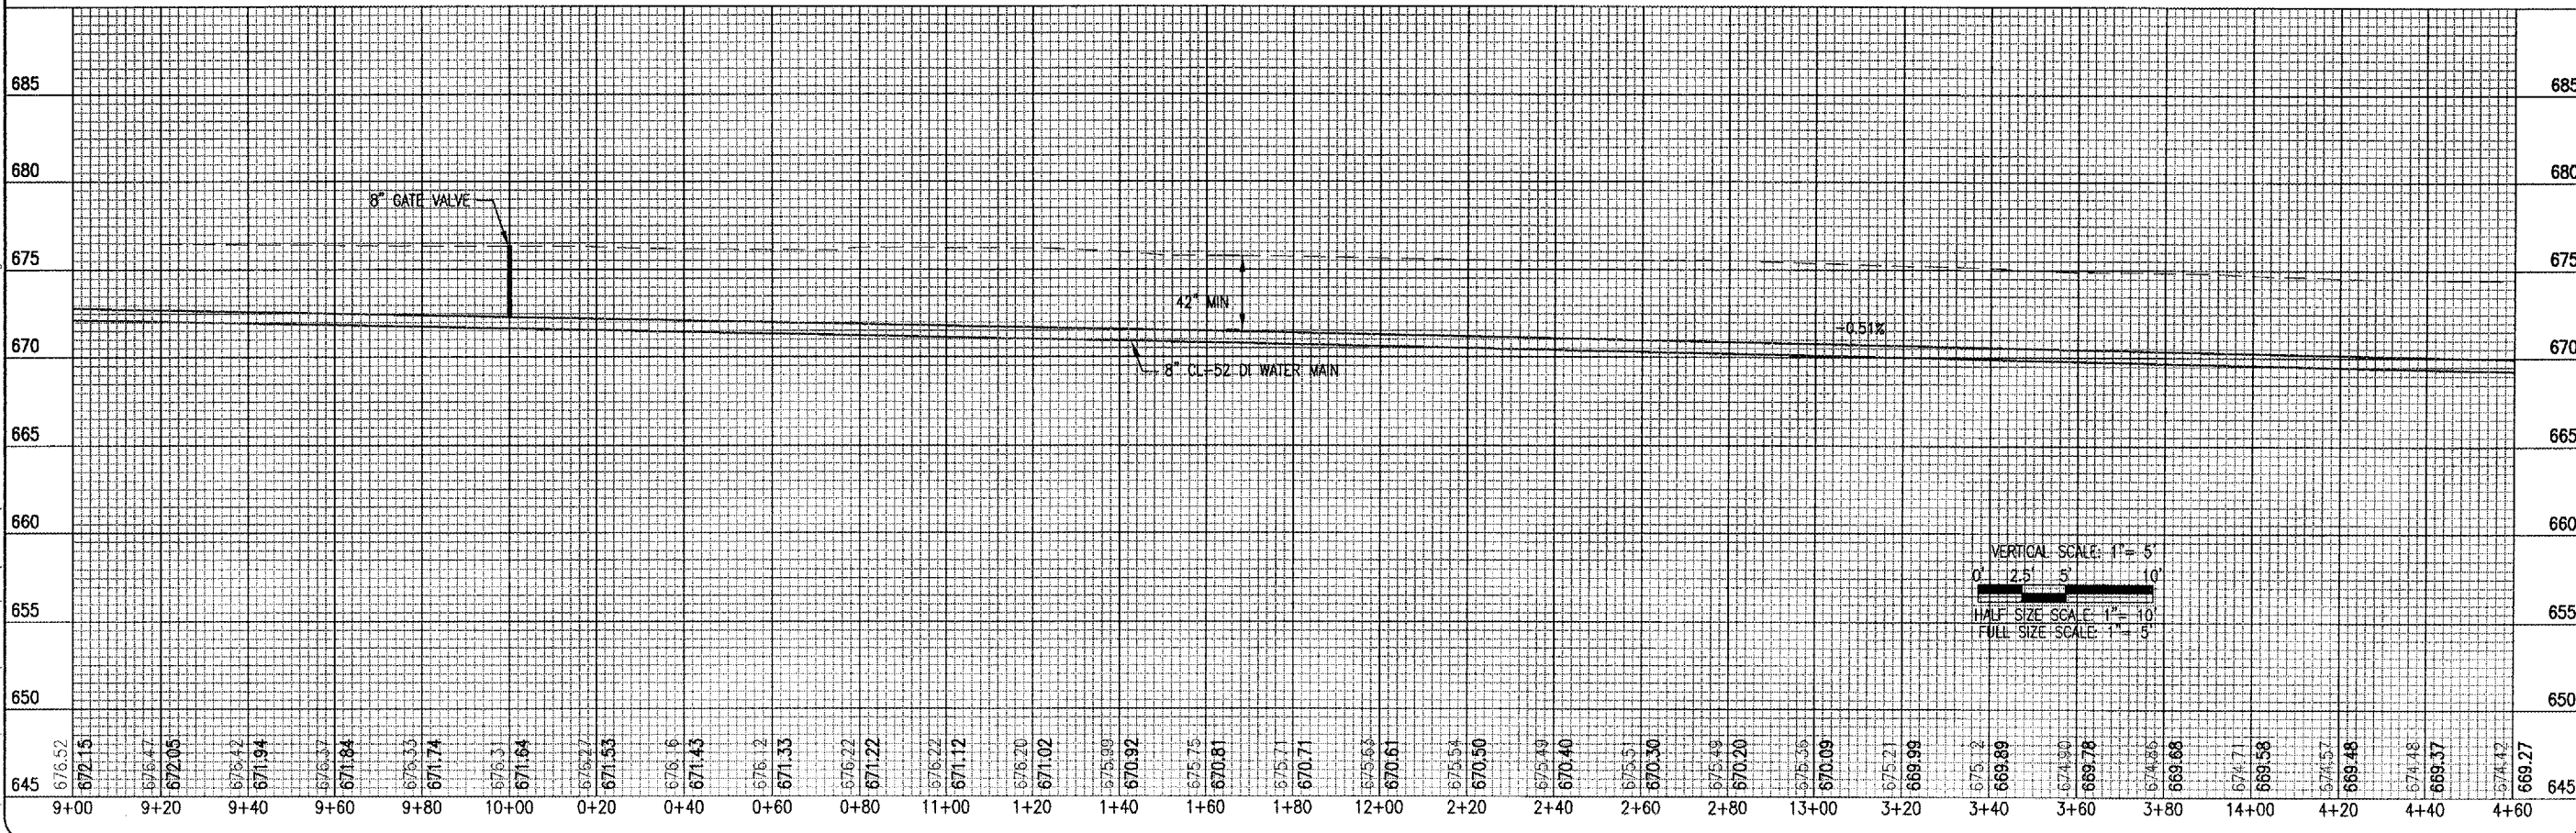
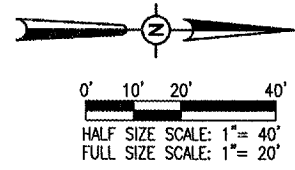


APR 18, 2008 1:32 PM WALLE00723
 I:\AIRPORTS\DECATUR\07A0060\CAD\SHEETS\R-703PNP.DWG - North South Leg - 2

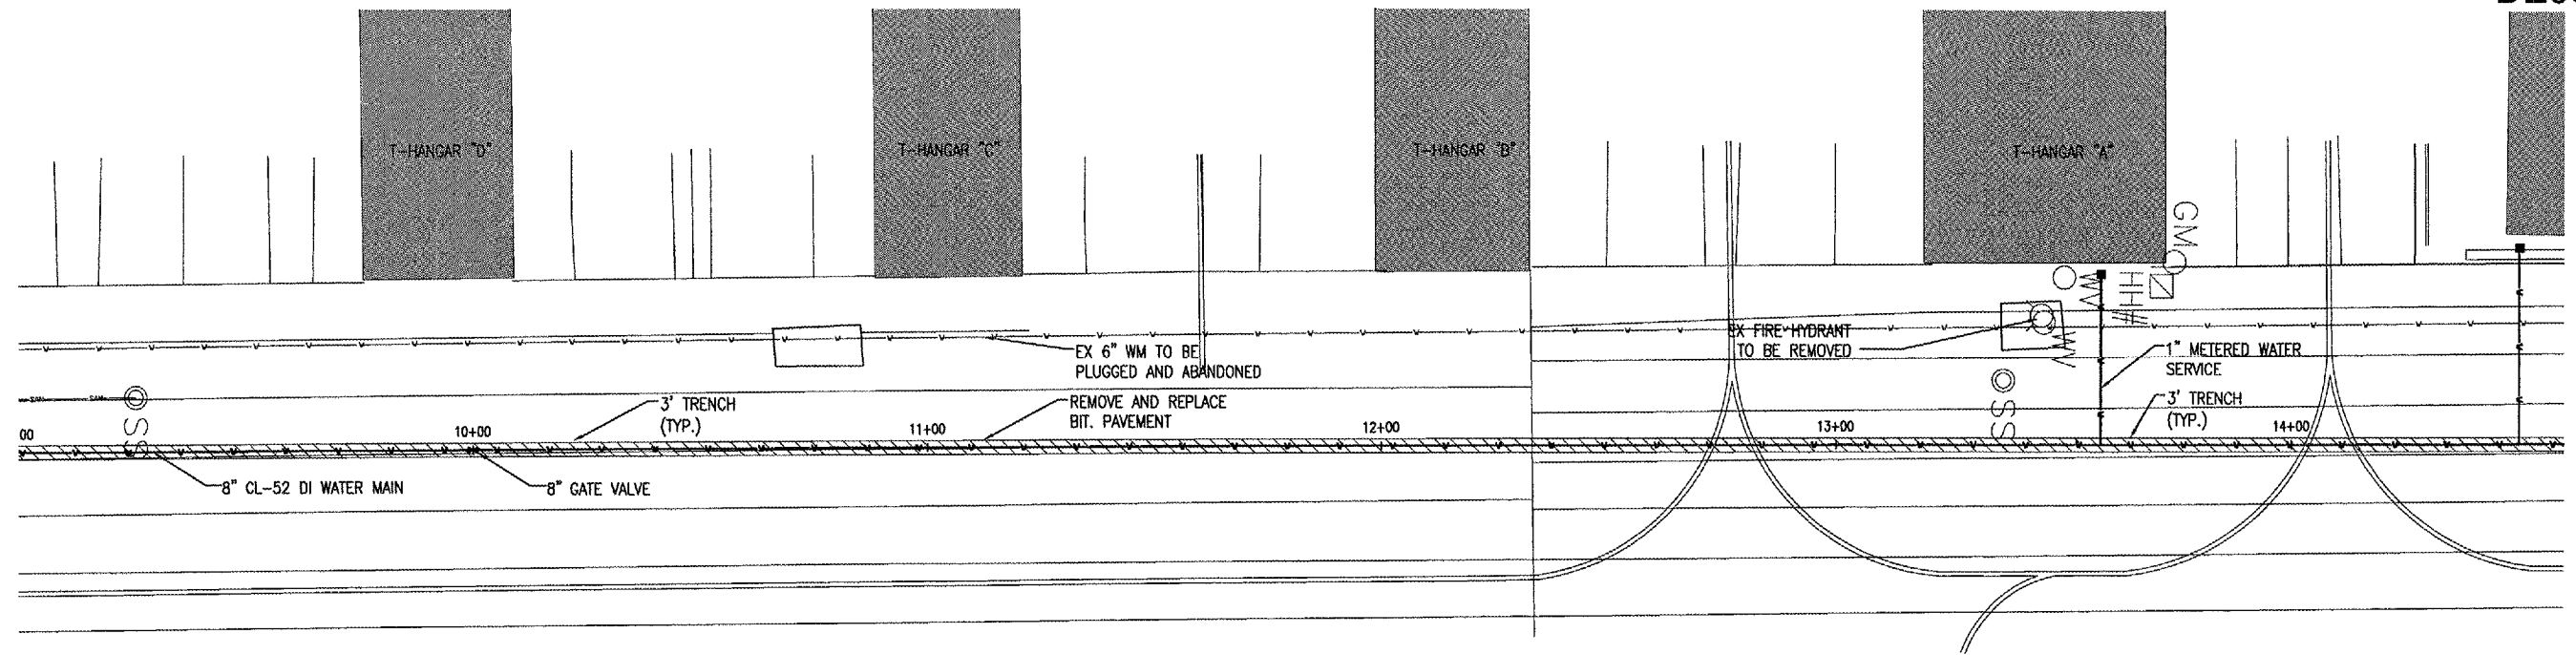

DE069

DATE	REVISION	BY

DECATUR AIRPORT
DECATUR, ILLINOIS
 ILL. PROJ.: DEC-3801 A.I.P. PROJ.: 3-17-0033-XX

IEL Project No. 07A00600-0800 Filename: R-703PNP.DWG Scale: 1" = 20' Date: 04/17/08	LAYOUT DRAWN: GRF REVIEWED: JMR	03/14/08 04/16/08 04/16/08
--	---------------------------------------	----------------------------------

HANSON
 Hanson Professional Services Inc.
 1525 South St.
 Springfield, Illinois 62703-2886
 Offices Nationwide

CONSTRUCT
 WATER MAIN
 NORTH SOUTH LEG
 PLAN AND PROFILE
 STA. 9+60 to STA. 14+60