
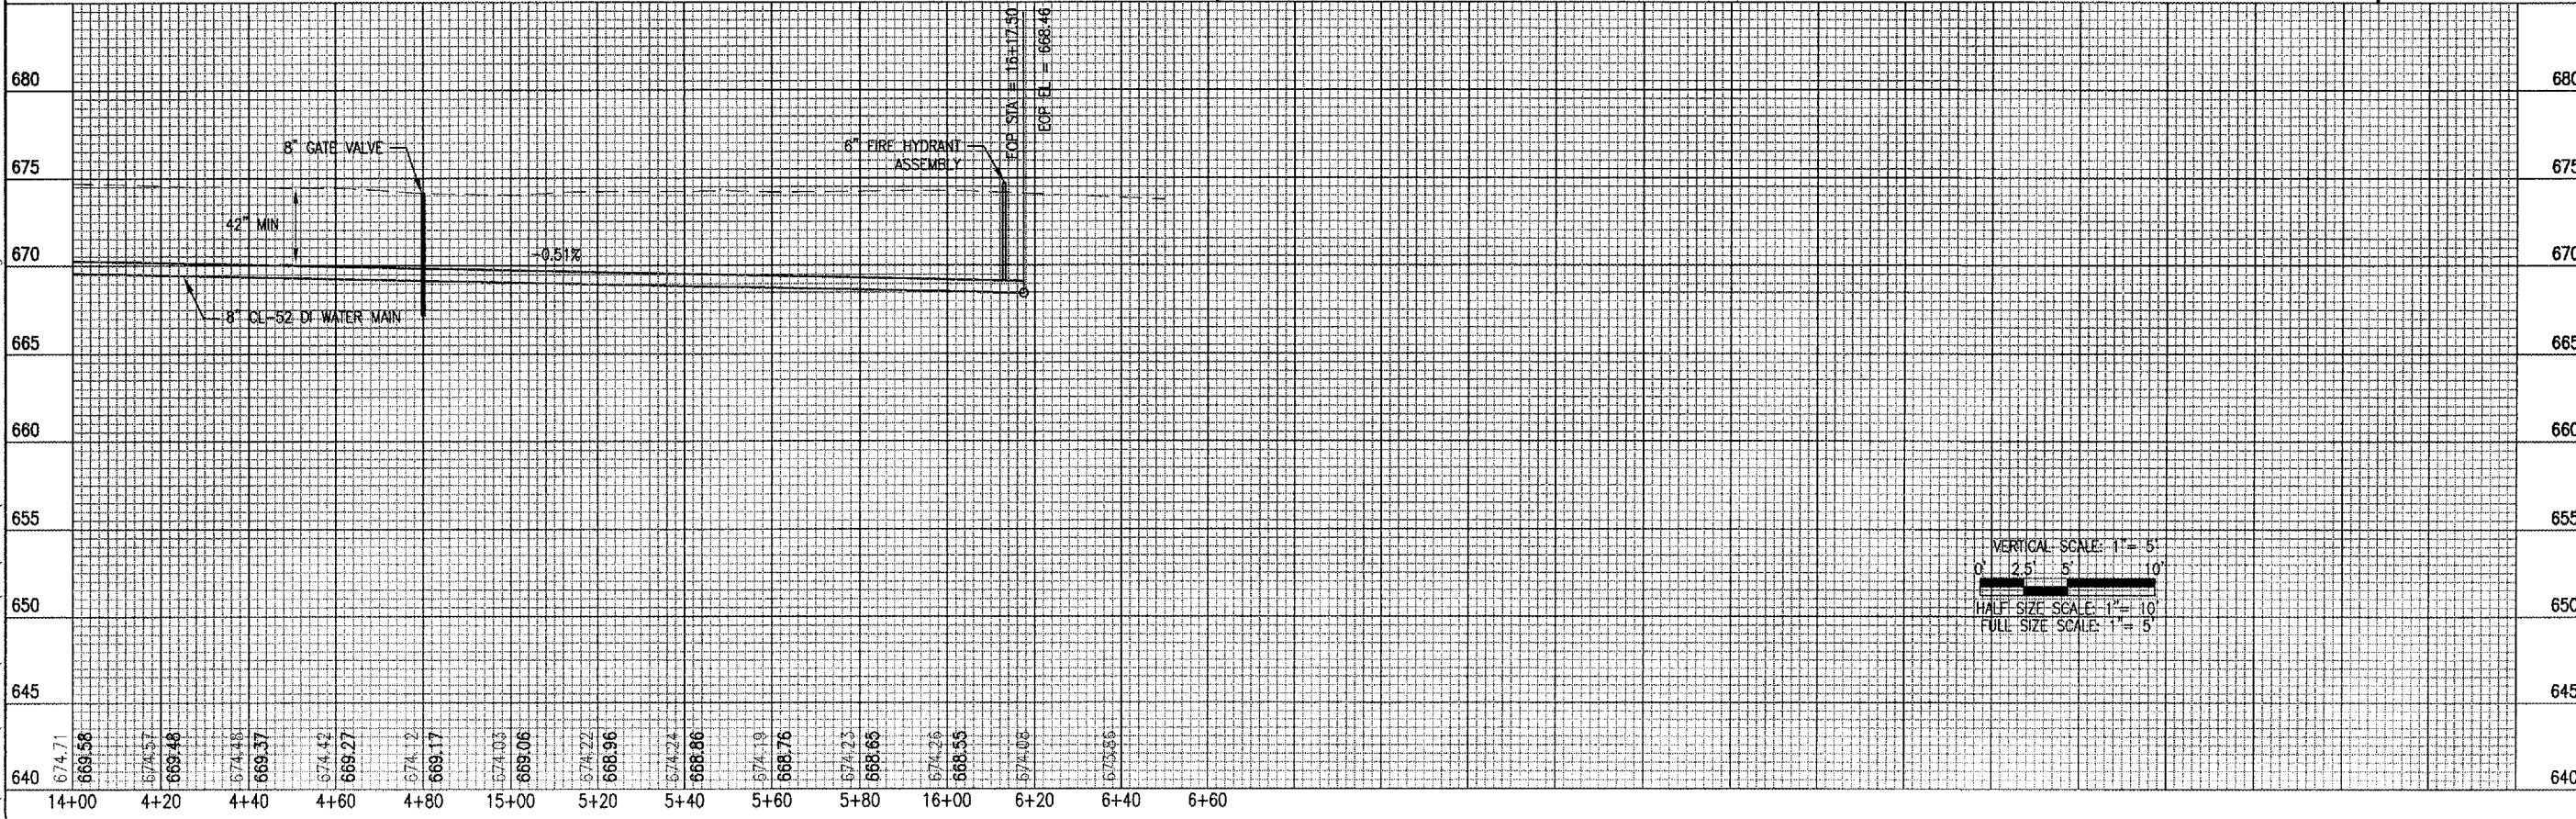



APR 18, 2008 1:45 PM WALLE00723  
 I:\AIRPORTS\DECATUR\07A0060\GAD\SHEETS\R-704RNP.DWG - North South Leg - 3

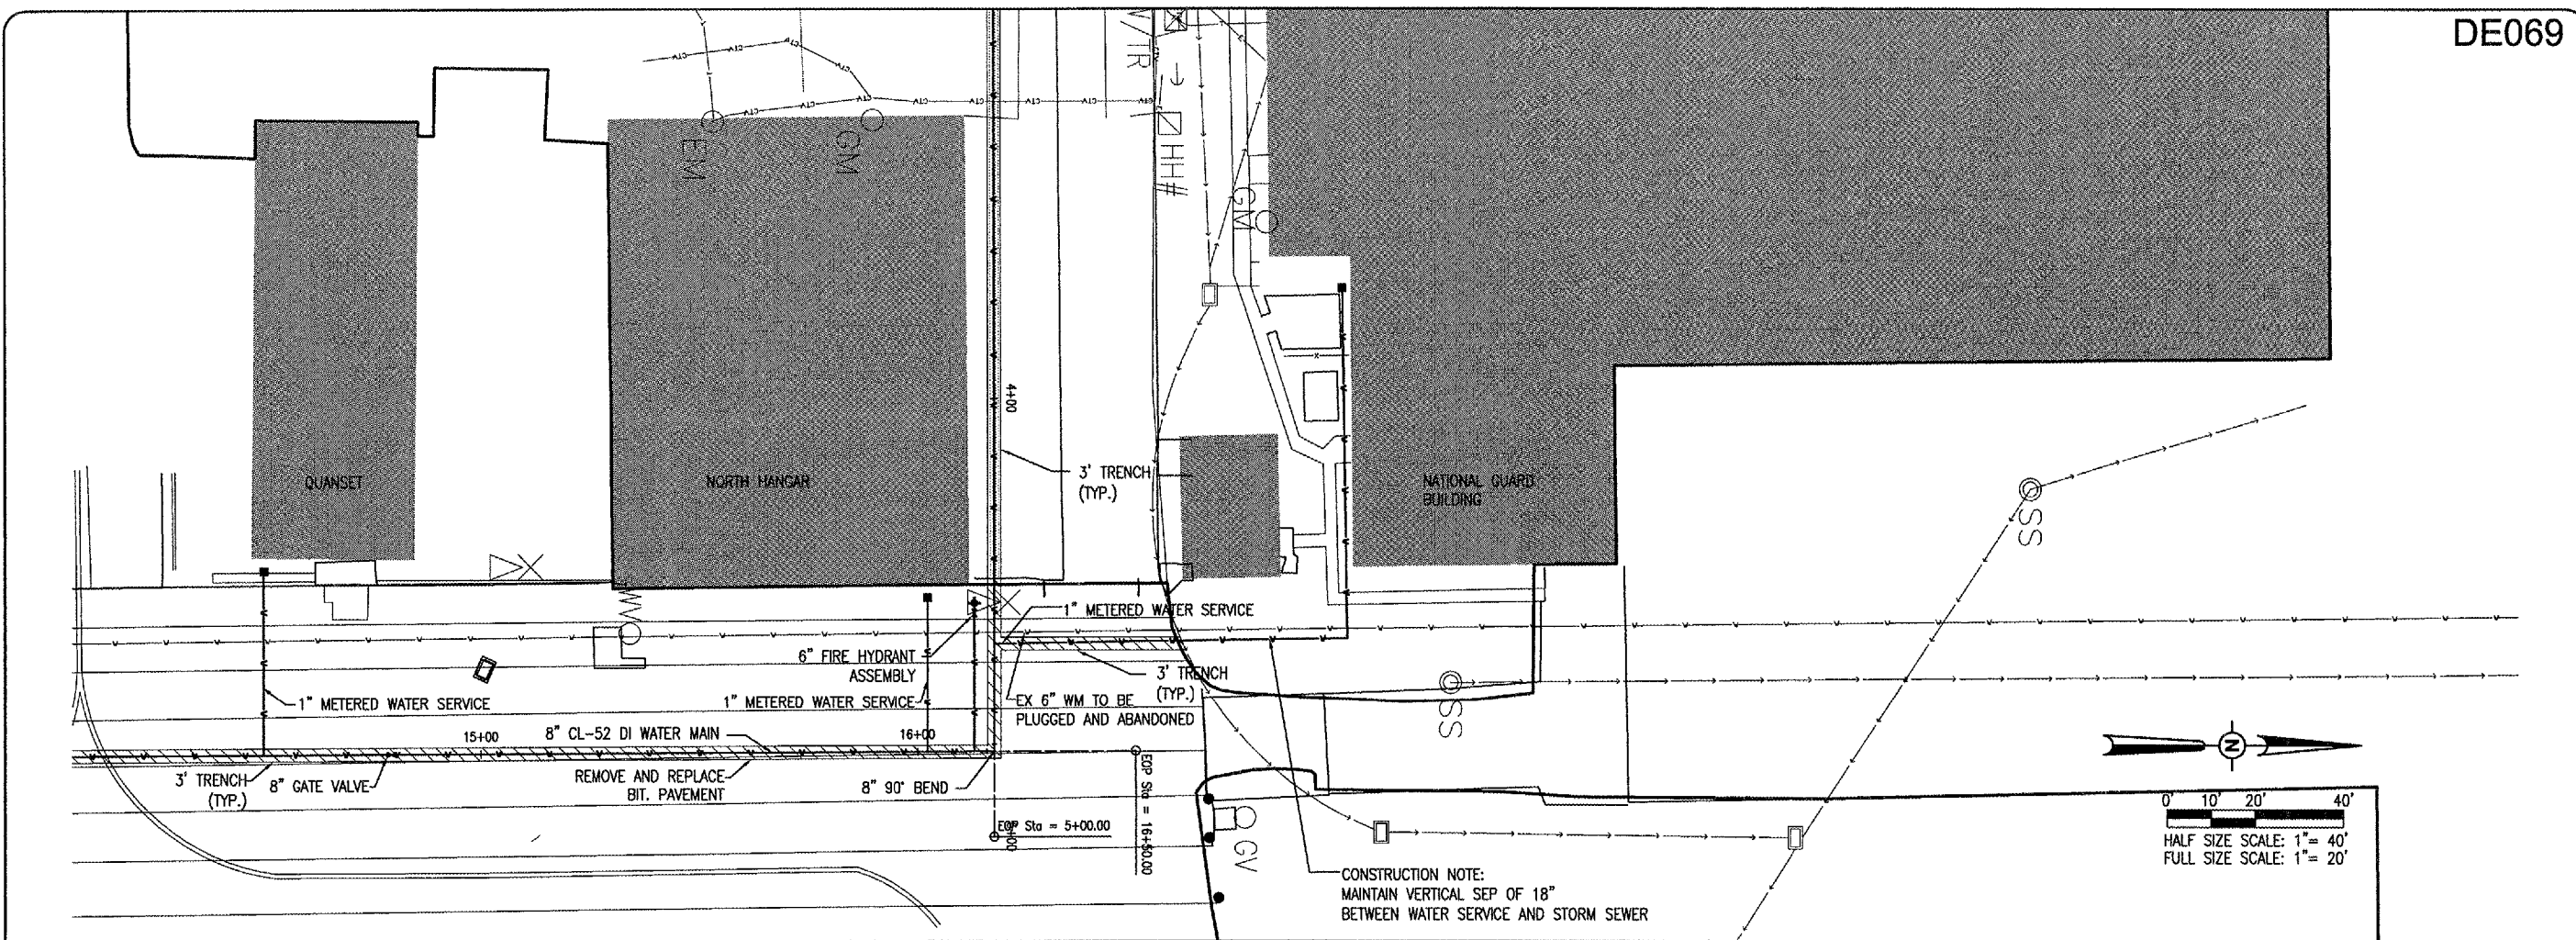


DE069

DATE	REVISION	BY


  
**DECATUR, ILLINOIS**
  
 ILL. PROJ.: DEC-3801      A.I.P. PROJ.: 3-17-0033-XX

IEG Project No. 07A0060D_0800 Filename R-704RNP.DWG Scale 1" = 20' Date 04/17/08	LAYOUT RAW 03/14/08 DRAWN GRF 04/16/08 REVIEWED JMR 04/16/08
---	--


  
**HANSON**
  
 Hanson Professional Services Inc.  
 1545 S. Springfield Avenue, Suite 200  
 Springfield, Illinois 62703-2886  
 Offices Nationwide

**CONSTRUCT WATER MAIN**  
 NORTH SOUTH LEG  
 PLAN AND PROFILE  
 STA. 14+00 to STA. 16+60

10

10 of 15 sheets